

CONSTRUCTION ISSUE

SHEET SCHEDULE

SHEET NUMBER	SHEET NAME	CURRENT REVISION	CURRENT REVISION DATE	ISSUED TO
00	INDEX PAGE	B	05.06.20	CLIENT
01	PROJECT LEGEND	A	05.06.20	CLIENT
FP-01	GROUND FLOOR PLAN	C	05.06.20	CLIENT
FP-02	FIRST FLOOR PLAN	C	05.06.20	CLIENT
FP-03	GROUND FLOOR ELECTRICAL PLAN	A	05.06.20	CLIENT
FP-04	FIRST FLOOR ELECTRICAL PLAN	A	05.06.20	CLIENT
FP-05	GROUND FLOOR FURNITURE PLAN	A	05.06.20	CLIENT
FP-06	FIRST FLOOR FURNITURE PLAN	A	05.06.20	CLIENT
RCP-01	GROUND FLOOR REFLECTED CEILING & LIGHTING PLAN	A	05.06.20	CLIENT
RCP-02	FIRST FLOOR REFLECTED CEILING & LIGHTING PLAN	A	05.06.20	CLIENT
INT-1.01	TYPICAL BEDROOM	A	05.06.20	CLIENT
INT-1.02	TYPICAL BEDROOM	A	05.06.20	CLIENT
INT-1.03	TYPICAL BEDROOM	A	05.06.20	CLIENT
INT-2.01	TYPICAL ENSUITE	A	05.06.20	CLIENT
INT-2.02	TYPICAL ENSUITE	A	05.06.20	CLIENT
INT-3.01	KITCHEN	B	05.06.20	CLIENT
INT-3.02	KITCHEN	A	05.06.20	CLIENT
INT-3.03	KITCHEN	A	05.06.20	CLIENT
INT-3.04	KITCHEN	A	05.06.20	CLIENT
INT-3.05	KITCHEN	A	05.06.20	CLIENT
INT-4.01	DINING	A	05.06.20	CLIENT
INT-4.02	DINING	A	05.06.20	CLIENT
INT-4.03	DINING	A	05.06.20	CLIENT
INT-4.04	DINING	A	05.06.20	CLIENT
INT-5.01	LIVING	A	05.06.20	CLIENT
INT-5.02	LIVING	A	05.06.20	CLIENT
INT-5.03	LIVING	A	05.06.20	CLIENT
INT-6.01	LAUNDRY	A	05.06.20	CLIENT
INT-6.02	LAUNDRY	A	05.06.20	CLIENT
INT-7.01	POWDER	A	05.06.20	CLIENT
INT-7.02	POWDER	A	05.06.20	CLIENT
INT-8.01	TV ROOM	A	05.06.20	CLIENT
INT-8.02	TV ROOM	A	05.06.20	CLIENT
INT-8.03	TV ROOM	A	05.06.20	CLIENT
JD-01	JOINERY DETAILS	A	05.06.20	CLIENT
JD-02	JOINERY DETAILS	A	05.06.20	CLIENT


REVISION STATUS

REV.	DESCRIPTION	DATE
A	REVISION #1 CONCEPT PLANS ISSUED	23.04.20
B	REVISION #3 CONSTRUCTION DOCS ISSUED	05.06.20

JOINERY

AS	ADJUSTABLE SHELF
AL	ALIGN
BAL	BALANCE
BS	BIFOLD SLIDING
CL	CENTRE LINE
DA	DOOR ACTIVATED
DLFH	BLUM DRAWER LEGRABOX FREE HIGH - 177 MM
DLFL	BLUM DRAWER LEGRABOX FREE LOW - 177 MM
DLPC	BLUM DRAWER LEGRABOX PURE C - 177 MM
DLPF	BLUM DRAWER LEGRABOX PURE F - 241 MM
DLPK	BLUM DRAWER LEGRABOX PURE K - 128.5 MM
DLPM	BLUM DRAWER LEGRABOX PURE M - 90.5 MM
DM	BLUM DRAWER MOVENTO (MELAMINE DRAWER BOX)
EQ	EQUAL
FS	FIXED SHELF
FP	FIXED PANNEL
HDB	HINGE DOOR - BLUM ONYX BLACK HINGES
HDN	HINGE DOOR - BLUM NICKEL PLATED HINGES
HF	HINGE FLAP
HR	HANGING RAIL
IAS	INTERNAL ADJUSTABLE SHELF
IDLH	BLUM INTERNAL DRAWER LEGRABOX FREE HIGH - 177 MM
IDLFL	BLUM INTERNAL DRAWER LEGRABOX FREE LOW - 177 MM
IDLPC	BLUM INTERNAL DRAWER LEGRABOX PURE C - 177 MM
IDLPF	BLUM INTERNAL DRAWER LEGRABOX PURE F - 241 MM
IDLPK	BLUM INTERNAL DRAWER LEGRABOX PURE K - 128.5 MM
IDLPM	BLUM INTERNAL DRAWER LEGRABOX PURE M - 90.5 MM
IDM	BLUM INTERNAL DRAWER MOVENTO (MELAMINE DRAWER BOX)
IFS	INTERNAL FIXED SHELF
IHDB	INTERNAL HINGE DOOR - BLUM ONYX BLACK HINGES
IHDN	INTERNAL HINGE DOOR - BLUM NICKEL PLATED HINGES
IPAS	INTERNAL PULLOUT ANGLED SHOE SHELF
IPS	INTERNAL PULLOUT SHELF
IJ	MITRE JOIN
MJ	MITRE JOIN
PS	PULLOUT SHELF
RD	RETRACTABLE DOOR
SL	SEAM LINE
SP	SLIDING PANEL
STSM	SUBJECT TO SITE MEASURE
STAS	SUBJECT TO APPLIANCE SPECS
Ⓟ	BI-FOLD OPERATION
Ⓡ	FINGER GRIP OPERATION WITH BLUMOTION
Ⓜ	MANUAL OPERATION WITH BLUMOTION
Ⓟ	PUSH TOUCH OPERATION WITH BLUM TIP ON FOR DOORS
Ⓡ	TIP ON OPERATION WITH BLUMOTION FOR DRAWERS
Ⓢ	SERVO-DRIVE OPERATION - BLUM
Ⓜ	AMBIALINE - BLUM INNER DIVIDER SYSTEM - LEGRABOX
Ⓜ	ORGALINE - BLUM INNER DIVIDER SYSTEM - MOVENTO

SCALE BAR

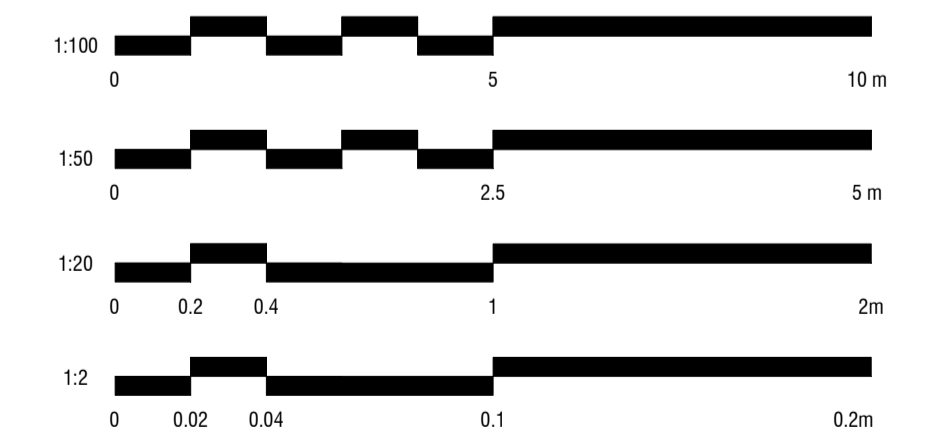

ALL MEASUREMENTS TO BE CHECKED BY TRADES ONSITE*

CHRISTOPHER
ELLIOTT


CHRISTOPHER ELLIOTT DESIGN PTY LTD
ABN 33131218650 ACN 131218650
T+61 (03)9077 8133 M +61 (0)403 653 649
INFO@CHRISTOPHERELLIOTTDESIGN.COM.AU
PO BOX 124 PRAHRAN 3181 VICTORIA AUSTRALIA

CLIENT AUSTRALIAN ALPINE CLUB
PROJECT ALPINE ROAD, HOTHAM HEIGHTS VIC 3741

All rights reserved. This document remains the property of Christopher Elliott Design Pty Ltd and is only to be used for its commissioned purpose. No part of this document may be reproduced, modified or transmitted in any form or by any means without the explicit written authority of Christopher Elliott Design Pty Ltd.
Unauthorised use of this document in any form whatsoever is prohibited.

TITLE INDEX PAGE
SCALE @ A1 AS INDICATED
CHECKED BY CE
SHEET 00

PLOT DATE 05.06.20
DRAWN BY CA
REVISION B

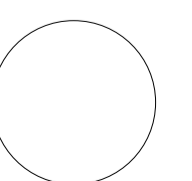

CONSTRUCTION ISSUE

PROJECT LEGEND

REFER TO SCHEDULES FOR FURTHER DETAILS

APPLIANCES

OV-1 OVEN
OV-2 MICROWAVE OVEN
CT-1 COOKTOP
CT-2 COOKTOP
ZT-1 ZIP TAP
FR-1 REFRIGERATOR
FR-2 MILK FRIDGE
DW-1 DISHWASHER
RH-1 RANGEHOOD
TV-1 TELEVISION

DOOR HARDWARE

DH-1 JOINERY PULL
DH-2 FLUSH PULL HANDLE
DH-3 DOOR LEVER
DH-4 ESCUTCHEON
DH-5 DOOR STOP

ELECTRICAL

DA-1 DATA SOCKET
GP-1 TWIN POWER SOCKET OUTLET
GP-2 TWIN POWER SOCKET OUTLET
GP-3 TWIN POWER SOCKET OUTLET WITH USB
GP-4 SINGLE POWER SOCKET OUTLET
GP-5 TWIN POWER SOCKET OUTLET
LS-1 LIGHT SWITCH
LS-2 LIGHT SWITCH WITH DIMMER
LS-3 DOLLY TOGGLE SWITCH
TA-1 TELEVISION ANTENNA SOCKET
WT-1 WINDOW TREATMENT MOLEX CABLE

FIXTURES & FITTINGS

BA-1 BASIN
JA-1 JOINERY ACCESSORY
JA-2 JOINERY ACCESSORY
JA-3 JOINERY ACCESSORY
JA-4 JOINERY ACCESSORY
SI-1 LAUNDRY TROUGH
TO-1 TOILET PAN
TO-1 TOILET PUSH PLATE AND CISTERN
TP-1 MIXER TAP WITH SPRAY
TP-2 MIXER TAP
TP-3 BASIN MIXER TAP AND OUTLET
TP-4 SHOWER WALL MIXER
TP-5 RAIL SHOWER
TR-1 TOWEL RAIL
TR-2 TOILET PAPER HOLDER
TR-3 TOWEL RAIL
TR-4 WALL HOOK
TR-5 ROBE HOOK
WA-1 WASTE TRAP

FURNITURE

FU-1 MODULAR SOFA
FU-2 MODULAR SOFA
FU-3 SOFA
FU-4 ARMCHAIR
FU-5 DINING TABLE - ROUND
FU-6 DINING TABLE - SQUARE
FU-7 DINING TABLE - RECTANGULAR
FU-8 DINING CHAIR
FU-9 DINING TABLE - RECTANGULAR
FU-10 COFFEE TABLE
FU-11 COFFEE TABLE
FU-12 COFFEE TABLE
FU-13 SIDE TABLE
FU-14 SIDE TABLE/STOOL
FU-15 FRAMED ARTWORK
FU-16 FRAMED ARTWORK
FU-17 FRAMED ARTWORK

LIGHTING

DL-1 DOWNLIGHT
LD-1 LED STRIP LIGHT
TR-1 TRACK LIGHT
TR-2 TRACK LIGHT
TR-3 SURFACE MOUNTED LIGHT
TR-4 SURFACE MOUNTED LIGHT
WL-1 WALL LIGHT
WL-2 WALL LIGHT
WL-3 WALL LIGHT
WL-4 WALL LIGHT

FINISHES

CP-1 CARPET
FB-1 FABRIC
FB-2 FABRIC
GL-1 TEXTURED GLASS
GL-2 MIRROR
GL-3 GLASS
LM-1 LAMINATE
LM-2 MELAMINE
LM-3 MELAMINE
PC-1 POWDERCOATED METAL
PC-2 POWDERCOATED METAL
PT-1 PAINT
ST-1 STAINLESS STEEL
ST-2 NATURAL STONE
TB-1 ENGINEERED TIMBER BOARDS
TB-2 TIMBER LINING - MDF
TB-3 TIMBER LINING - MR MDF
TI-1 MOSAIC TILE
TI-2 MOSAIC TILE
TI-3 MOSAIC TILE
TI-4 PORCELAIN TILE
VE-1 VENEER & SOLID TIMBER
VF-1 VINYL FLOORING

GENERAL PROJECT NOTES

BUILDER

- CONFIRM ALL DESIGN AND SITE DISCREPANCIES WITH CED
- CHECK ALL 'ALIGN' & 'CENTRE' TAGS ON JOINERY PLANS TO ENSURE DESIGN INTEGRITY
- ALL WALLS TO BE CLAD IN TB-2/TB-3 UNLESS OTHERWISE SPECIFIED
- ALL WINDOW REVEALS TO BE CLAD IN TB-2/TB-3 TO ALL SIDES (REFER TO DETAIL DRAWINGS)
- ALL DOORS TO BE PAINTED IN PT-1 UNLESS OTHERWISE SPECIFIED
- ALL CEILINGS AND BULKHEADS TO BE PAINTED IN PT-1 UNLESS OTHERWISE SPECIFIED
- ALL EXISTING CARPET TO BE REMOVED FROM STAIRCASES
- ALL EXISTING STAIR TREADS, RISERS AND BALUSTRADES TO BE STAINED TO MATCH VE-1
- ALL SKIRTING TO BE REMOVED. TB-2/TB-3 TO BUTT INTO FLOORING
- ALL CORNICES TO BE REMOVED. TO BE REPLACED WITH TB-2/TB-3 SQUARE SET JUNCTIONS
- ALL WINDOW AND DOOR ARCHITRAVES TO BE REMOVED. TO BE REPLACED WITH TB-2/TB-3 SQUARE SET JUNCTIONS

ELECTRICIAN

- ANY UNSPECIFIED GPOS THAT ARE VISIBLE NEED TO BE APPROVED BY CED
- NO WIRING TO BE VISIBLE

JOINER/CABINET MAKER

- CONFIRM ALL OVERALL MEASUREMENTS ON SITE PRIOR TO MANUFACTURE
- CONFIRM ALL DESIGN AND SITE DISCREPANCIES WITH CED
- JOINERS TO CONFIRM WITH BUILDER ANY ADDITIONAL BRACING/NOGGINS TO WALLS IF REQUIRED
- CHECK ALL 'ALIGN' & 'CENTRE' TAGS ON JOINERY PLANS TO ENSURE DESIGN INTEGRITY
- VENEER GRAIN DIRECTION IS VERTICAL UNLESS OTHERWISE SPECIFIED

PLUMBER

- CONFIRM ALL DESIGN AND SITE DISCREPANCIES WITH CED
- CHECK ALL 'ALIGN' & 'CENTRE' TAGS ON JOINERY PLANS TO ENSURE DESIGN INTEGRITY

TILER

- PROVIDE MATCHING GROUT TO ALL TILES UNLESS OTHERWISE SPECIFIED
- ALL GROUT LINES MINIMAL UNLESS OTHERWISE SPECIFIED

REVISION STATUS


REV.	DESCRIPTION	DATE
A	REVISION #3 CONSTRUCTION DOCS ISSUED	05.06.20

JOINERY

AS	ADJUSTABLE SHELF
AL	ALIGN
BAL	BALANCE
BS	BIFOLD SLIDING
CL	CENTRE LINE
DA	DOOR ACTIVATED
DLFH	BLUM DRAWER LEGRABOX FREE HIGH - 177 MM
DLFL	BLUM DRAWER LEGRABOX FREE LOW - 177 MM
DLPC	BLUM DRAWER LEGRABOX PURE C - 177 MM
DLPK	BLUM DRAWER LEGRABOX PURE F - 241 MM
DLPK	BLUM DRAWER LEGRABOX PURE K - 128.5 MM
DLPM	BLUM DRAWER LEGRABOX PURE M - 90.5 MM
DM	BLUM DRAWER MOVENTO (MELAMINE DRAWER BOX)
EQ	EQUAL
FS	FIXED SHELF
FP	FIXED PANNEL
HDB	HINGE DOOR - BLUM ONYX BLACK HINGES
HDN	HINGE DOOR - BLUM NICKEL PLATED HINGES
HF	HINGE FLAP
HR	HANGING RAIL
IAS	INTERNAL ADJUSTABLE SHELF
IDLFH	BLUM INTERNAL DRAWER LEGRABOX FREE HIGH - 177 MM
IDLFL	BLUM INTERNAL DRAWER LEGRABOX FREE LOW - 177 MM
IDLPC	BLUM INTERNAL DRAWER LEGRABOX PURE C - 177 MM
IDLPF	BLUM INTERNAL DRAWER LEGRABOX PURE F - 241 MM
IDLPK	BLUM INTERNAL DRAWER LEGRABOX PURE K - 128.5 MM
IDLPM	BLUM INTERNAL DRAWER LEGRABOX PURE M - 90.5 MM
IDM	BLUM INTERNAL DRAWER MOVENTO (MELAMINE DRAWER BOX)
IFS	INTERNAL FIXED SHELF
IHDB	INTERNAL HINGE DOOR - BLUM ONYX BLACK HINGES
IHDN	INTERNAL HINGE DOOR - BLUM NICKEL PLATED HINGES
IPAS	INTERNAL PULLOUT ANGLED SHOE SHELF
IPS	INTERNAL PULLOUT SHELF
IJ	MITRE JOIN
PS	PULLOUT SHELF
RD	RETRACTABLE DOOR
SL	SEAM LINE
SP	SLIDING PANEL
STSM	SUBJECT TO SITE MEASURE
STAS	SUBJECT TO APPLIANCE SPECS

Ⓟ	BI-FOLD OPERATION
Ⓡ	FINGER GRIP OPERATION WITH BLUMOTION
Ⓜ	MANUAL OPERATION WITH BLUMOTION
Ⓟ	PUSH TOUCH OPERATION WITH BLUM TIP ON FOR DOORS
Ⓡ	TIP ON OPERATION WITH BLUMOTION FOR DRAWERS
Ⓜ	SERVO-DRIVE OPERATION - BLUM
Ⓡ	AMBIALINE - BLUM INNER DIVIDER SYSTEM - LEGRABOX
Ⓜ	ORGALINE - BLUM INNER DIVIDER SYSTEM - MOVENTO

SCALE BAR

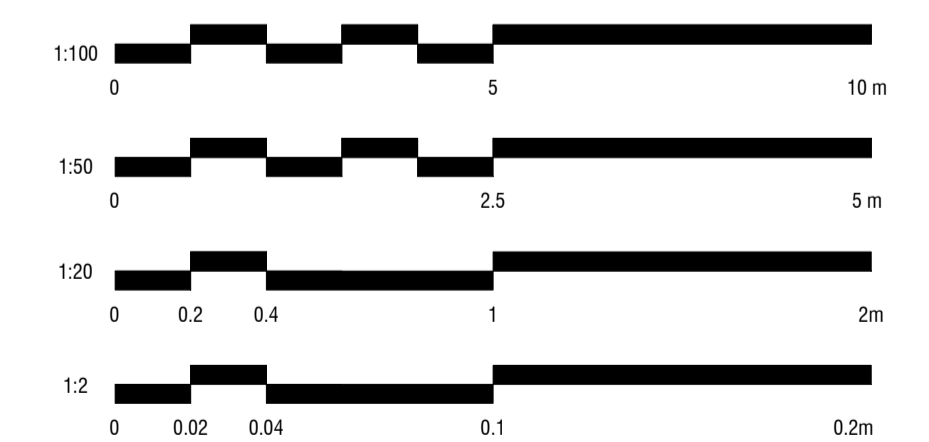

ALL MEASUREMENTS TO BE CHECKED BY TRADES ONSITE*

CHRISTOPHER
ELLIOTT


CHRISTOPHER ELLIOTT DESIGN PTY LTD
ABN 33131218650 ACN 131218650
T+61 (03)9077 8133 M +61 (0)403 653 649
INFO@CHRISTOPHERELLIOTTDISIGN.COM.AU
PO BOX 124 PRAHRAN 3181 VICTORIA AUSTRALIA

CLIENT AUSTRALIAN ALPINE CLUB
PROJECT ALPINE ROAD, HOTHAM HEIGHTS VIC 3741

All rights reserved. This document remains the property of Christopher Elliott Design Pty Ltd and is only to be used for its commissioned purpose. No part of this document may be reproduced, modified or transmitted in any form or by any means without the explicit written authority of Christopher Elliott Design Pty Ltd. Unauthorised use of this document in any form whatsoever is prohibited.

TITLE PROJECT LEGEND
SCALE @ A1 AS INDICATED
CHECKED BY CE
SHEET 01

PLOT DATE 05.06.20
DRAWN BY CA
REVISION A

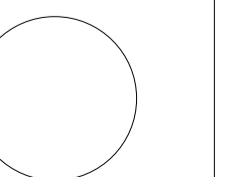

REVISION STATUS


REV.	DESCRIPTION	DATE
A	REVISION #1 CONCEPT PLANS ISSUED	23.04.20
B	REVISION #2 REVISED CONCEPT PLANS ISSUED	07.05.20
C	REVISION #3 CONSTRUCTION DOCS ISSUED	05.06.20



JOINERY

AS	ADJUSTABLE SHELF
AL	ALIGN
BAL	BALANCE
BS	BIFOLD SLIDING
CL	CENTRE LINE
DA	DOOR ACTIVATED
DLFH	BLUM DRAWER LEGRABOX FREE HIGH - 177 MM
DLFL	BLUM DRAWER LEGRABOX FREE LOW - 177 MM
DLPC	BLUM DRAWER LEGRABOX PURE C - 177 MM
DLPF	BLUM DRAWER LEGRABOX PURE F - 241 MM
DLPK	BLUM DRAWER LEGRABOX PURE K - 128.5 MM
DLPM	BLUM DRAWER LEGRABOX PURE M - 90.5 MM
DM	BLUM DRAWER MOVENTO (MELAMINE DRAWER BOX)
EQ	EQUAL
FS	FIXED SHELF
FP	FIXED PANNEL
HDB	HINGE DOOR - BLUM ONYX BLACK HINGES
HDN	HINGE DOOR - BLUM NICKEL PLATED HINGES
HF	HINGE FLAP
HR	HANGING RAIL
IAS	INTERNAL ADJUSTABLE SHELF
IDLFH	BLUM INTERNAL DRAWER LEGRABOX FREE HIGH - 177 MM
IDLFL	BLUM INTERNAL DRAWER LEGRABOX FREE LOW - 177 MM
IDLPC	BLUM INTERNAL DRAWER LEGRABOX PURE C - 177 MM
IDLPF	BLUM INTERNAL DRAWER LEGRABOX PURE F - 241 MM
IDLPK	BLUM INTERNAL DRAWER LEGRABOX PURE K - 128.5 MM
IDLPM	BLUM INTERNAL DRAWER LEGRABOX PURE M - 90.5 MM
IDM	BLUM INTERNAL DRAWER MOVENTO (MELAMINE DRAWER BOX)
IFS	INTERNAL FIXED SHELF
IHDB	INTERNAL HINGE DOOR - BLUM ONYX BLACK HINGES
IHDN	INTERNAL HINGE DOOR - BLUM NICKEL PLATED HINGES
IPAS	INTERNAL PULLOUT ANGLED SHOE SHELF
IPS	INTERNAL PULLOUT SHELF
MJ	MITRE JOIN
PS	PULLOUT SHELF
RD	RETRACTABLE DOOR
SL	SEAM LINE
SP	SLIDING PANEL
STSM	SUBJECT TO SITE MEASURE
STAS	SUBJECT TO APPLIANCE SPECS
Ⓟ	BI-FOLD OPERATION
Ⓡ	FINGER GRIP OPERATION WITH BLUMOTION
Ⓜ	MANUAL OPERATION WITH BLUMOTION
Ⓟ	PUSH TOUCH OPERATION WITH BLUM TIP ON FOR DOORS
Ⓡ	TIP ON OPERATION WITH BLUMOTION FOR DRAWERS
Ⓢ	SERVO-DRIVE OPERATION - BLUM
Ⓜ	AMBIALINE - BLUM INNER DIVIDER SYSTEM - LEGRABOX
Ⓜ	ORGALINE - BLUM INNER DIVIDER SYSTEM - MOVENTO

SCALE BAR

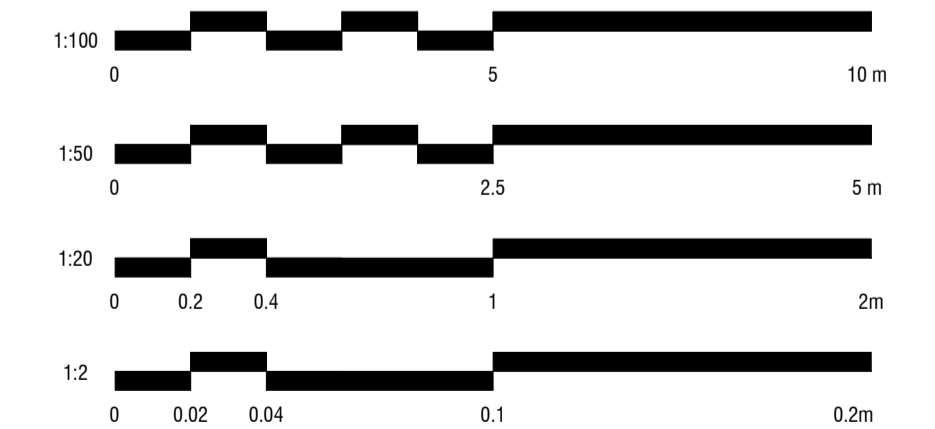

ALL MEASUREMENTS TO BE CHECKED BY TRADES ONSITE*

1 FFL GROUND FLOOR PLAN
1:50

CHRISTOPHER
ELLIOTT


CHRISTOPHER ELLIOTT DESIGN PTY LTD
ABN 33131218650 ACN 131218650
T+61 (03)9077 8133 M +61 (0)403 653 649
INFO@CHRISTOPHERELLIOTTDESIGN.COM.AU
PO BOX 124 PRAHRAN 3181 VICTORIA AUSTRALIA

CLIENT AUSTRALIAN ALPINE CLUB
PROJECT ALPINE ROAD, HOTHAM HEIGHTS VIC 3741

All rights reserved. This document remains the property of Christopher Elliott Design Pty Ltd and is only to be used for its commissioned purpose. No part of this document may be reproduced, modified or transmitted in any form or by any means without the explicit written authority of Christopher Elliott Design Pty Ltd. Unauthorised use of this document in any form whatsoever is prohibited.

TITLE GROUND FLOOR PLAN
SCALE @ A1 AS INDICATED
CHECKED BY CE
SHEET FP-01

PLOT DATE 05.06.20
DRAWN BY CA
REVISION C

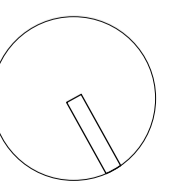

REVISION STATUS


REV.	DESCRIPTION	DATE
A	REVISION #1 CONCEPT PLANS ISSUED	23.04.20
B	REVISION #2 REVISED CONCEPT PLANS ISSUED	07.05.20
C	REVISION #3 CONSTRUCTION DCS ISSUED	05.06.20



JOINERY

AS	ADJUSTABLE SHELF
AL	ALIGN
BAL	BALANCE
BS	BIFOLD SLIDING
CL	CENTRE LINE
DA	DOOR ACTIVATED
DLFH	BLUM DRAWER LEGRABOX FREE HIGH - 177 MM
DLFL	BLUM DRAWER LEGRABOX FREE LOW - 177 MM
DLPC	BLUM DRAWER LEGRABOX PURE C - 177 MM
DLPF	BLUM DRAWER LEGRABOX PURE F - 241 MM
DLPK	BLUM DRAWER LEGRABOX PURE K - 128.5 MM
DLPM	BLUM DRAWER LEGRABOX PURE M - 90.5 MM
DM	BLUM DRAWER MOVENTO (MELAMINE DRAWER BOX)
EQ	EQUAL
FS	FIXED SHELF
FP	FIXED PANNEL
HDB	HINGE DOOR - BLUM ONYX BLACK HINGES
HDN	HINGE DOOR - BLUM NICKEL PLATED HINGES
HF	HINGE FLAP
HR	HANGING RAIL
IAS	INTERNAL ADJUSTABLE SHELF
IDLFH	BLUM INTERNAL DRAWER LEGRABOX FREE HIGH - 177 MM
IDLFL	BLUM INTERNAL DRAWER LEGRABOX FREE LOW - 177 MM
IDLPC	BLUM INTERNAL DRAWER LEGRABOX PURE C - 177 MM
IDLPF	BLUM INTERNAL DRAWER LEGRABOX PURE F - 241 MM
IDLPK	BLUM INTERNAL DRAWER LEGRABOX PURE K - 128.5 MM
IDLPM	BLUM INTERNAL DRAWER LEGRABOX PURE M - 90.5 MM
IDM	BLUM INTERNAL DRAWER MOVENTO (MELAMINE DRAWER BOX)
IFS	INTERNAL FIXED SHELF
IHDB	INTERNAL HINGE DOOR - BLUM ONYX BLACK HINGES
IHDN	INTERNAL HINGE DOOR - BLUM NICKEL PLATED HINGES
IPAS	INTERNAL PULLOUT ANGLED SHOE SHELF
IPS	INTERNAL PULLOUT SHELF
IJ	MITRE JOIN
PS	PULLOUT SHELF
RD	RETRACTABLE DOOR
SL	SEAM LINE
SP	SLIDING PANNEL
STSM	SUBJECT TO SITE MEASURE
STAS	SUBJECT TO APPLIANCE SPECS
ⓑ	BI-FOLD OPERATION
Ⓕ	FINGER GRIP OPERATION WITH BLUMOTION
Ⓜ	MANUAL OPERATION WITH BLUMOTION
Ⓟ	PUSH TOUCH OPERATION WITH BLUM TIP ON FOR DOORS
Ⓡ	TIP ON OPERATION WITH BLUMOTION FOR DRAWERS
Ⓢ	SERVO-DRIVE OPERATION - BLUM
Ⓜ	AMBIALINE - BLUM INNER DIVIDER SYSTEM - LEGRABOX
Ⓞ	ORGALINE - BLUM INNER DIVIDER SYSTEM - MOVENTO

SCALE BAR

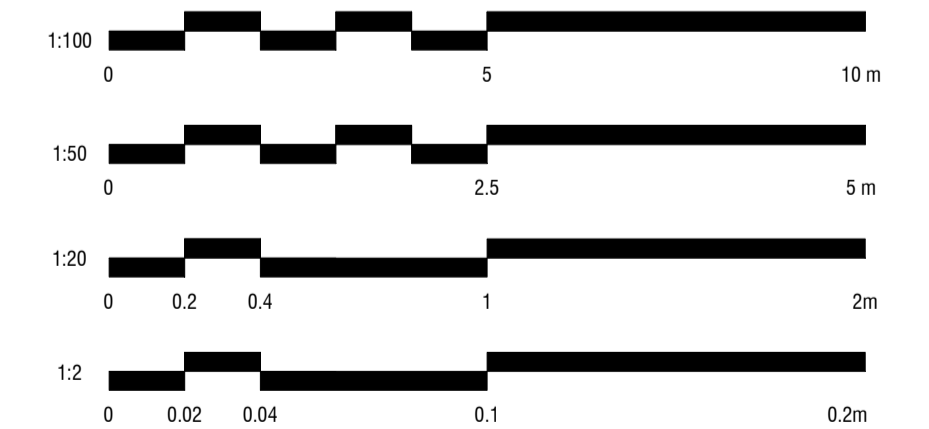

ALL MEASUREMENTS TO BE CHECKED BY TRADES ONSITE*

1 FFL FIRST FLOOR PLAN
1:50

CHRISTOPHER
ELLIOTT


CHRISTOPHER ELLIOTT DESIGN PTY LTD
ABN 33131218650 ACN 131218650
T+61 (03)9077 8133 M +61 (0)403 653 649
INFO@CHRISTOPHERELLIOTTDESIGN.COM.AU
PO BOX 124 PRAHRAN 3181 VICTORIA AUSTRALIA

CLIENT AUSTRALIAN ALPINE CLUB
PROJECT ALPINE ROAD, HOTHAM HEIGHTS VIC 3741

All rights reserved. This document remains the property of Christopher Elliott Design Pty Ltd and is only to be used for its commissioned purpose. No part of this document may be reproduced, modified or transmitted in any form or by any means without the explicit written authority of Christopher Elliott Design Pty Ltd. Unauthorised use of this document in any form whatsoever is prohibited.

TITLE FIRST FLOOR PLAN
SCALE @ A1 AS INDICATED
CHECKED BY CE
SHEET FP-02

PLOT DATE 05.06.20
DRAWN BY CA
REVISION C

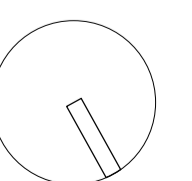

REVISION STATUS


REV.	DESCRIPTION	DATE
A	REVISION #3 CONSTRUCTION DOCS ISSUED	05.06.20



JOINERY

AS	ADJUSTABLE SHELF
AL	ALIGN
BAL	BALANCE
BS	BIFOLD SLIDING
CL	CENTRE LINE
DA	DOOR ACTIVATED
DLFH	BLUM DRAWER LEGRABOX FREE HIGH - 177 MM
DLFL	BLUM DRAWER LEGRABOX FREE LOW - 177 MM
DLPC	BLUM DRAWER LEGRABOX PURE C - 177 MM
DLPF	BLUM DRAWER LEGRABOX PURE F - 241 MM
DLPK	BLUM DRAWER LEGRABOX PURE K - 128.5 MM
DLPM	BLUM DRAWER LEGRABOX PURE M - 90.5 MM
DM	BLUM DRAWER MOVENTO (MELAMINE DRAWER BOX)
EQ	EQUAL
FS	FIXED SHELF
FP	FIXED PANNEL
HDB	HINGE DOOR - BLUM ONYX BLACK HINGES
HDN	HINGE DOOR - BLUM NICKEL PLATED HINGES
HF	HINGE FLAP
HR	HANGING RAIL
IAS	INTERNAL ADJUSTABLE SHELF
IDLFH	BLUM INTERNAL DRAWER LEGRABOX FREE HIGH - 177 MM
IDLFL	BLUM INTERNAL DRAWER LEGRABOX FREE LOW - 177 MM
IDLPC	BLUM INTERNAL DRAWER LEGRABOX PURE C - 177 MM
IDLPF	BLUM INTERNAL DRAWER LEGRABOX PURE F - 241 MM
IDLPK	BLUM INTERNAL DRAWER LEGRABOX PURE K - 128.5 MM
IDLPM	BLUM INTERNAL DRAWER LEGRABOX PURE M - 90.5 MM
IDM	BLUM INTERNAL DRAWER MOVENTO (MELAMINE DRAWER BOX)
IFS	INTERNAL FIXED SHELF
IHDB	INTERNAL HINGE DOOR - BLUM ONYX BLACK HINGES
IHDN	INTERNAL HINGE DOOR - BLUM NICKEL PLATED HINGES
IPAS	INTERNAL PULLOUT ANGLED SHOE SHELF
IPS	INTERNAL PULLOUT SHELF
IJ	MITRE JOIN
PS	PULLOUT SHELF
RD	RETRACTABLE DOOR
SL	SEAM LINE
SP	SLIDING PANEL
STSM	SUBJECT TO SITE MEASURE
STAS	SUBJECT TO APPLIANCE SPECS
Ⓟ	BI-FOLD OPERATION
Ⓡ	FINGER GRIP OPERATION WITH BLUMOTION
Ⓜ	MANUAL OPERATION WITH BLUMOTION
Ⓟ	PUSH TOUCH OPERATION WITH BLUM TIP ON FOR DOORS
Ⓡ	TIP ON OPERATION WITH BLUMOTION FOR DRAWERS
Ⓢ	SERVO-DRIVE OPERATION - BLUM
Ⓜ	AMBIALINE - BLUM INNER DIVIDER SYSTEM - LEGRABOX
Ⓜ	ORGALINE - BLUM INNER DIVIDER SYSTEM - MOVENTO

SCALE BAR

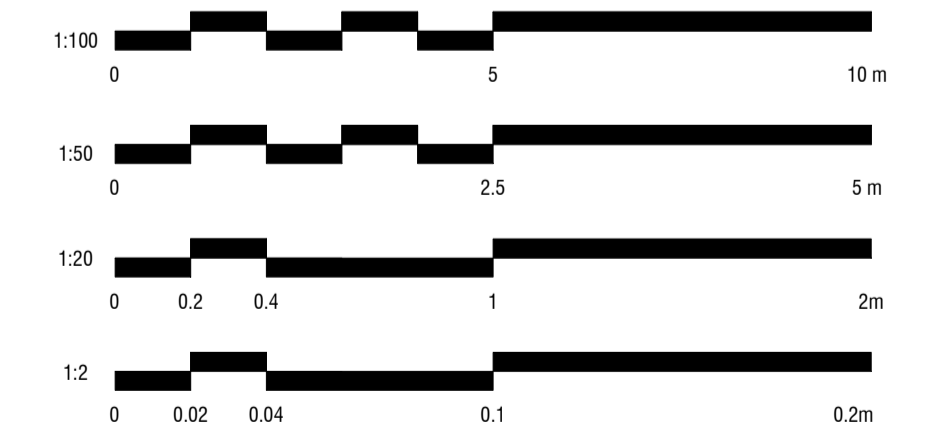

ALL MEASUREMENTS TO BE CHECKED BY TRADES ONSITE*

1 FFL GROUND FLOOR ELECTRICAL PLAN
1:50


CHRISTOPHER
ELLIOTT

CHRISTOPHER ELLIOTT DESIGN PTY LTD
ABN 33131218650 ACN 131218650
T+61 (03)9077 8133 M +61 (0)403 653 649
INFO@CHRISTOPHERELLIOTTDESIGN.COM.AU
PO BOX 124 PRAHRAN 3181 VICTORIA AUSTRALIA

CLIENT AUSTRALIAN ALPINE CLUB
PROJECT ALPINE ROAD, HOTHAM HEIGHTS VIC 3741


All rights reserved. This document remains the property of Christopher Elliott Design Pty Ltd and is only to be used for its commissioned purpose. No part of this document may be reproduced, modified or transmitted in any form or by any means without the explicit written authority of Christopher Elliott Design Pty Ltd. Unauthorised use of this document in any form whatsoever is prohibited.

TITLE GROUND FLOOR ELECTRICAL PLAN
SCALE @ A1 AS INDICATED PLOT DATE 05.06.20
CHECKED BY CE DRAWN BY CA
SHEET FP-03 REVISION A

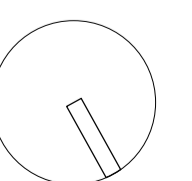

REVISION STATUS

REV.	DESCRIPTION	DATE
A	REVISION #3 CONSTRUCTION DOCS ISSUED	05.06.20

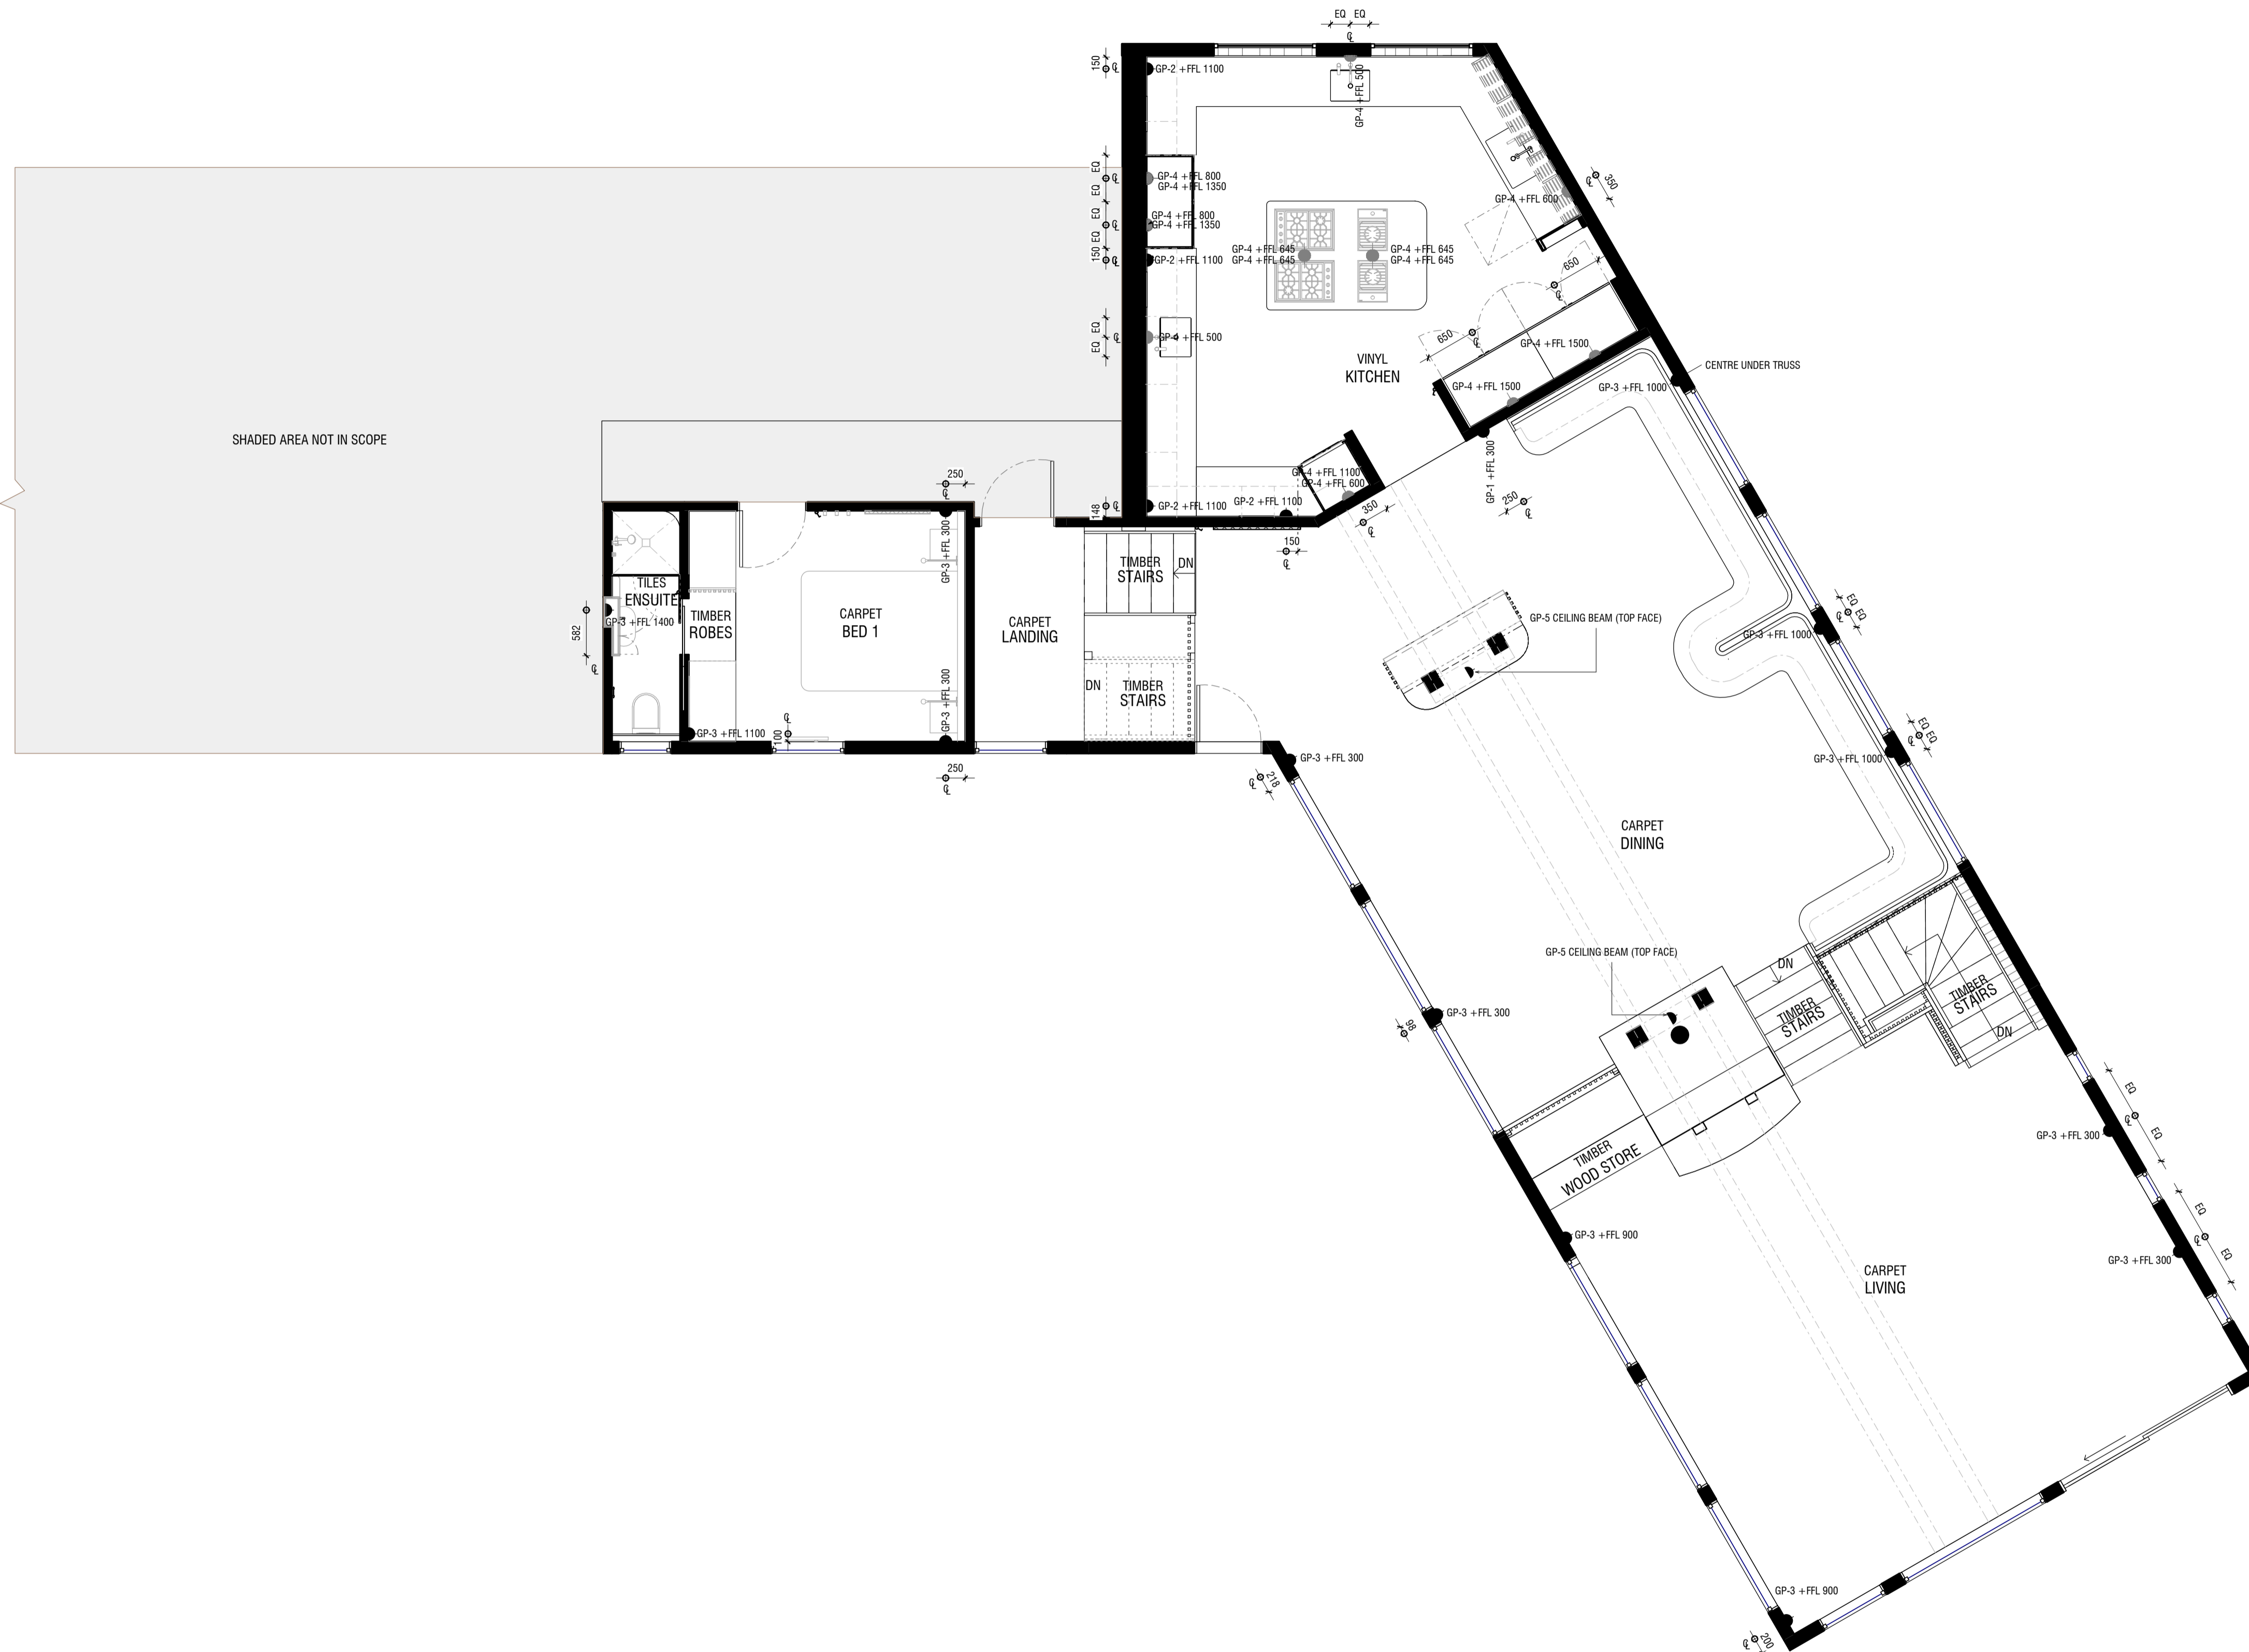


SHADED AREA NOT IN SCOPE

JOINERY

AS	ADJUSTABLE SHELF
AL	ALIGN
BAL	BALANCE
BS	BIFOLD SLIDING
CL	CENTRE LINE
DA	DOOR ACTIVATED
DLFH	BLUM DRAWER LEGRABOX FREE HIGH - 177 MM
DLFL	BLUM DRAWER LEGRABOX FREE LOW - 177 MM
DLPC	BLUM DRAWER LEGRABOX PURE C - 177 MM
DLPF	BLUM DRAWER LEGRABOX PURE F - 241 MM
DLPK	BLUM DRAWER LEGRABOX PURE K - 128.5 MM
DLPM	BLUM DRAWER LEGRABOX PURE M - 90.5 MM
DM	BLUM DRAWER MOVENTO (MELAMINE DRAWER BOX)
EQ	EQUAL
FS	FIXED SHELF
FP	FIXED PANNEL
HDB	HINGE DOOR - BLUM ONYX BLACK HINGES
HDN	HINGE DOOR - BLUM NICKEL PLATED HINGES
HF	HINGE FLAP
HR	HANGING RAIL
IAS	INTERNAL ADJUSTABLE SHELF
IDLFH	BLUM INTERNAL DRAWER LEGRABOX FREE HIGH - 177 MM
IDLFL	BLUM INTERNAL DRAWER LEGRABOX FREE LOW - 177 MM
IDLPC	BLUM INTERNAL DRAWER LEGRABOX PURE C - 177 MM
IDLPF	BLUM INTERNAL DRAWER LEGRABOX PURE F - 241 MM
IDLPK	BLUM INTERNAL DRAWER LEGRABOX PURE K - 128.5 MM
IDLPM	BLUM INTERNAL DRAWER LEGRABOX PURE M - 90.5 MM
IDM	BLUM INTERNAL DRAWER MOVENTO (MELAMINE DRAWER BOX)
IFS	INTERNAL FIXED SHELF
IHDB	INTERNAL HINGE DOOR - BLUM ONYX BLACK HINGES
IHDN	INTERNAL HINGE DOOR - BLUM NICKEL PLATED HINGES
IPAS	INTERNAL PULLOUT ANGLED SHOE SHELF
IPS	INTERNAL PULLOUT SHELF
IJ	MITRE JOIN
PS	PULLOUT SHELF
RD	RETRACTABLE DOOR
SL	SEAM LINE
SP	SLIDING PANNEL
STSM	SUBJECT TO SITE MEASURE
STAS	SUBJECT TO APPLIANCE SPECS
ⓑ	BI-FOLD OPERATION
Ⓕ	FINGER GRIP OPERATION WITH BLUMOTION
Ⓜ	MANUAL OPERATION WITH BLUMOTION
Ⓟ	PUSH TOUCH OPERATION WITH BLUM TIP ON FOR DOORS
Ⓡ	TIP ON OPERATION WITH BLUMOTION FOR DRAWERS
Ⓢ	SERVO-DRIVE OPERATION - BLUM
Ⓛ	AMBIALINE - BLUM INNER DIVIDER SYSTEM - LEGRABOX
Ⓞ	ORGALINE - BLUM INNER DIVIDER SYSTEM - MOVENTO

SCALE BAR

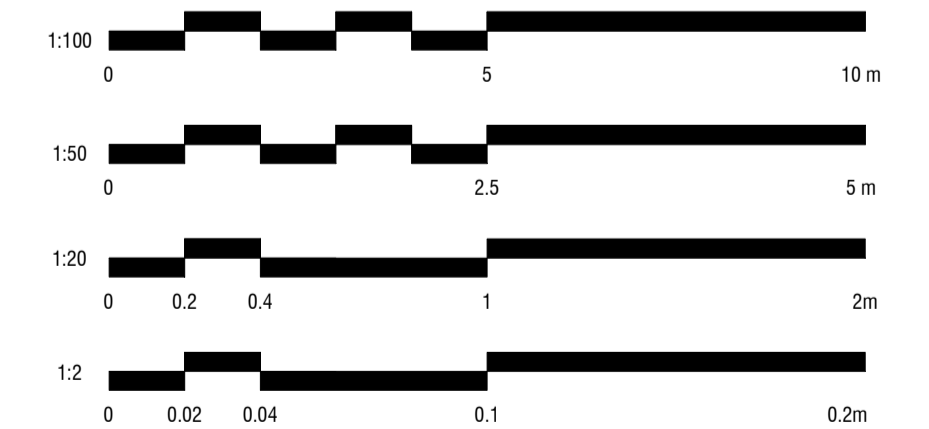

ALL MEASUREMENTS TO BE CHECKED BY TRADES ONSITE

1 FFL FIRST FLOOR ELECTRICAL PLAN
1:50

CHRISTOPHER
ELLIOTT


CHRISTOPHER ELLIOTT DESIGN PTY LTD
ABN 33131218650 ACN 131218650
T+61 (03)9077 8133 M +61 (0)403 653 649
INFO@CHRISTOPHERELLIOTTDESIGN.COM.AU
PO BOX 124 PRAHRAN 3181 VICTORIA AUSTRALIA

CLIENT AUSTRALIAN ALPINE CLUB
PROJECT ALPINE ROAD, HOTHAM HEIGHTS VIC 3741

All rights reserved. This document remains the property of Christopher Elliott Design Pty Ltd and is only to be used for its commissioned purpose. No part of this document may be reproduced, modified or transmitted in any form or by any means without the explicit written authority of Christopher Elliott Design Pty Ltd. Unauthorised use of this document in any form whatsoever is prohibited.

TITLE FIRST FLOOR ELECTRICAL PLAN
SCALE @ A1 AS INDICATED
CHECKED BY CE
SHEET FP-04

PLOT DATE 05.06.20
DRAWN BY CA
REVISION A

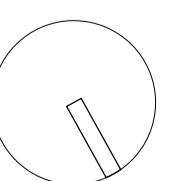

REVISION STATUS


REV.	DESCRIPTION	DATE
A	REVISION #3 CONSTRUCTION DOCS ISSUED	05.06.20



JOINERY

AS	ADJUSTABLE SHELF
AL	ALIGN
BAL	BALANCE
BS	BIFOLD SLIDING
CL	CENTRE LINE
DA	DOOR ACTIVATED
DLFH	BLUM DRAWER LEGRABOX FREE HIGH - 177 MM
DLFL	BLUM DRAWER LEGRABOX FREE LOW - 177 MM
DLPC	BLUM DRAWER LEGRABOX PURE C - 177 MM
DLPF	BLUM DRAWER LEGRABOX PURE F - 241 MM
DLPK	BLUM DRAWER LEGRABOX PURE K - 128.5 MM
DLPM	BLUM DRAWER LEGRABOX PURE M - 90.5 MM
DM	BLUM DRAWER MOVENTO (MELAMINE DRAWER BOX)
EQ	EQUAL
FS	FIXED SHELF
FP	FIXED PANNEL
HDB	HINGE DOOR - BLUM ONYX BLACK HINGES
HDN	HINGE DOOR - BLUM NICKEL PLATED HINGES
HF	HINGE FLAP
HR	HANGING RAIL
IAS	INTERNAL ADJUSTABLE SHELF
IDLFH	BLUM INTERNAL DRAWER LEGRABOX FREE HIGH - 177 MM
IDLFL	BLUM INTERNAL DRAWER LEGRABOX FREE LOW - 177 MM
IDLPC	BLUM INTERNAL DRAWER LEGRABOX PURE C - 177 MM
IDLPF	BLUM INTERNAL DRAWER LEGRABOX PURE F - 241 MM
IDLPK	BLUM INTERNAL DRAWER LEGRABOX PURE K - 128.5 MM
IDLPM	BLUM INTERNAL DRAWER LEGRABOX PURE M - 90.5 MM
IDM	BLUM INTERNAL DRAWER MOVENTO (MELAMINE DRAWER BOX)
IFS	INTERNAL FIXED SHELF
IHDB	INTERNAL HINGE DOOR - BLUM ONYX BLACK HINGES
IHDN	INTERNAL HINGE DOOR - BLUM NICKEL PLATED HINGES
IPAS	INTERNAL PULLOUT ANGLED SHOE SHELF
IPS	INTERNAL PULLOUT SHELF
IJS	INTERNAL JOINT
PS	PULLOUT SHELF
RD	RETRACTABLE DOOR
SL	SEAM LINE
SP	SLIDING PANEL
STSM	SUBJECT TO SITE MEASURE
STAS	SUBJECT TO APPLIANCE SPECS
Ⓚ	BI-FOLD OPERATION
Ⓛ	FINGER GRIP OPERATION WITH BLUMOTION
Ⓜ	MANUAL OPERATION WITH BLUMOTION
Ⓟ	PUSH TOUCH OPERATION WITH BLUM TIP ON FOR DOORS
Ⓡ	TIP ON OPERATION WITH BLUMOTION FOR DRAWERS
Ⓢ	SERVO-DRIVE OPERATION - BLUM
Ⓜ	AMBIALINE - BLUM INNER DIVIDER SYSTEM - LEGRABOX
Ⓜ	ORGALINE - BLUM INNER DIVIDER SYSTEM - MOVENTO

SCALE BAR

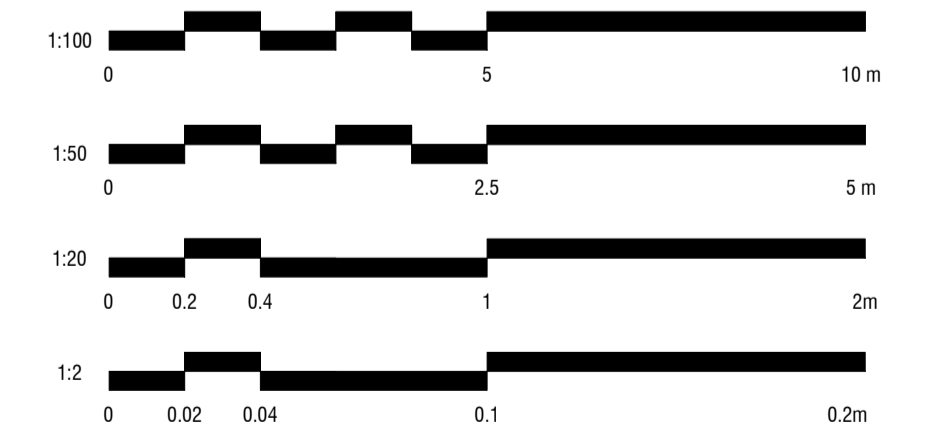

ALL MEASUREMENTS TO BE CHECKED BY TRADES ONSITE*

1 FFL GROUND FLOOR FURNITURE PLAN
1:50

**CHRISTOPHER
ELLIOTT**


CHRISTOPHER ELLIOTT DESIGN PTY LTD
ABN 33131218650 ACN 131218650
T+61 (03)9077 8133 M +61 (0)403 653 649
INFO@CHRISTOPHERELLIOTTDESIGN.COM.AU
PO BOX 124 PRAHRAN 3181 VICTORIA AUSTRALIA

CLIENT AUSTRALIAN ALPINE CLUB
PROJECT ALPINE ROAD, HOTHAM HEIGHTS VIC 3741

All rights reserved. This document remains the property of Christopher Elliott Design Pty Ltd and is only to be used for its commissioned purpose. No part of this document may be reproduced, modified or transmitted in any form or by any means without the explicit written authority of Christopher Elliott Design Pty Ltd. Unauthorised use of this document in any form whatsoever is prohibited.

TITLE GROUND FLOOR FURNITURE PLAN
SCALE @ A1 AS INDICATED
CHECKED BY CE
SHEET FP-05

PLOT DATE 05.06.20
DRAWN BY CA
REVISION A

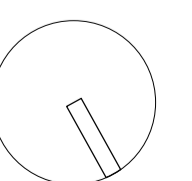

REVISION STATUS


REV.	DESCRIPTION	DATE
A	REVISION #3 CONSTRUCTION DOCS ISSUED	05.06.20



JOINERY

AS	ADJUSTABLE SHELF
AL	ALIGN
BAL	BALANCE
BS	BIFOLD SLIDING
CL	CENTRE LINE
DA	DOOR ACTIVATED
DLFH	BLUM DRAWER LEGRABOX FREE HIGH - 177 MM
DLFL	BLUM DRAWER LEGRABOX FREE LOW - 177 MM
DLPC	BLUM DRAWER LEGRABOX PURE C - 177 MM
DLPF	BLUM DRAWER LEGRABOX PURE F - 241 MM
DLPK	BLUM DRAWER LEGRABOX PURE K - 128.5 MM
DLPM	BLUM DRAWER LEGRABOX PURE M - 90.5 MM
DM	BLUM DRAWER MOVENTO (MELAMINE DRAWER BOX)
EQ	EQUAL
FS	FIXED SHELF
FP	FIXED PANNEL
HDB	HINGE DOOR - BLUM ONYX BLACK HINGES
HDN	HINGE DOOR - BLUM NICKEL PLATED HINGES
HF	HINGE FLAP
HR	HANGING RAIL
IAS	INTERNAL ADJUSTABLE SHELF
IDLFH	BLUM INTERNAL DRAWER LEGRABOX FREE HIGH - 177 MM
IDLFL	BLUM INTERNAL DRAWER LEGRABOX FREE LOW - 177 MM
IDLPC	BLUM INTERNAL DRAWER LEGRABOX PURE C - 177 MM
IDLPF	BLUM INTERNAL DRAWER LEGRABOX PURE F - 241 MM
IDLPK	BLUM INTERNAL DRAWER LEGRABOX PURE K - 128.5 MM
IDLPM	BLUM INTERNAL DRAWER LEGRABOX PURE M - 90.5 MM
IDM	BLUM INTERNAL DRAWER MOVENTO (MELAMINE DRAWER BOX)
IFS	INTERNAL FIXED SHELF
IHDB	INTERNAL HINGE DOOR - BLUM ONYX BLACK HINGES
IHDN	INTERNAL HINGE DOOR - BLUM NICKEL PLATED HINGES
IPAS	INTERNAL PULLOUT ANGLED SHOE SHELF
IPS	INTERNAL PULLOUT SHELF
IJ	MITRE JOIN
PS	PULLOUT SHELF
RD	RETRACTABLE DOOR
SL	SEAM LINE
SP	SLIDING PANEL
STSM	SUBJECT TO SITE MEASURE
STAS	SUBJECT TO APPLIANCE SPECS
Ⓟ	BI-FOLD OPERATION
Ⓡ	FINGER GRIP OPERATION WITH BLUMOTION
Ⓜ	MANUAL OPERATION WITH BLUMOTION
Ⓟ	PUSH TOUCH OPERATION WITH BLUM TIP ON FOR DOORS
Ⓡ	TIP ON OPERATION WITH BLUMOTION FOR DRAWERS
Ⓢ	SERVO-DRIVE OPERATION - BLUM
Ⓜ	AMBIALINE - BLUM INNER DIVIDER SYSTEM - LEGRABOX
Ⓜ	ORGALINE - BLUM INNER DIVIDER SYSTEM - MOVENTO

SCALE BAR

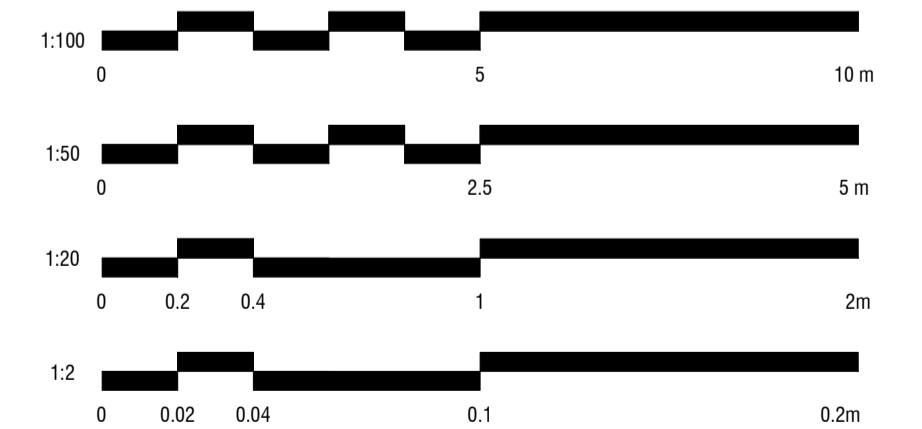

ALL MEASUREMENTS TO BE CHECKED BY TRADES ONSITE*

1 FFL FIRST FLOOR FURNITURE PLAN
1:50

CHRISTOPHER
ELLIOTT


CHRISTOPHER ELLIOTT DESIGN PTY LTD
ABN 33131218650 ACN 131218650
T+61 (03)9077 8133 M +61 (0)403 653 649
INFO@CHRISTOPHERELLIOTTDESIGN.COM.AU
PO BOX 124 PRAHRAN 3181 VICTORIA AUSTRALIA

CLIENT AUSTRALIAN ALPINE CLUB
PROJECT ALPINE ROAD, HOTHAM HEIGHTS VIC 3741

All rights reserved. This document remains the property of Christopher Elliott Design Pty Ltd and is only to be used for its commissioned purpose. No part of this document may be reproduced, modified or transmitted in any form or by any means without the explicit written authority of Christopher Elliott Design Pty Ltd. Unauthorised use of this document in any form whatsoever is prohibited.

TITLE FIRST FLOOR FURNITURE PLAN
SCALE @ A1 AS INDICATED
CHECKED BY CE
SHEET FP-06

PLOT DATE 05.06.20
DRAWN BY CA
REVISION A

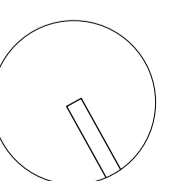

REVISION STATUS


REV.	DESCRIPTION	DATE
A	REVISION #3 CONSTRUCTION DOCS ISSUED	05.06.20

JOINERY


AS	ADJUSTABLE SHELF
AL	ALIGN
BAL	BALANCE
BS	BIFOLD SLIDING
CL	CENTRE LINE
DA	DOOR ACTIVATED
DLFH	BLUM DRAWER LEGRABOX FREE HIGH - 177 MM
DLFL	BLUM DRAWER LEGRABOX FREE LOW - 177 MM
DLPC	BLUM DRAWER LEGRABOX PURE C - 177 MM
DLPF	BLUM DRAWER LEGRABOX PURE F - 241 MM
DLPK	BLUM DRAWER LEGRABOX PURE K - 128.5 MM
DLPM	BLUM DRAWER LEGRABOX PURE M - 90.5 MM
DM	BLUM DRAWER MOVENTO (MELAMINE DRAWER BOX)
EQ	EQUAL
FS	FIXED SHELF
FP	FIXED PANNEL
HDB	HINGE DOOR - BLUM ONYX BLACK HINGES
HDN	HINGE DOOR - BLUM NICKEL PLATED HINGES
HF	HINGE FLAP
HR	HANGING RAIL
IAS	INTERNAL ADJUSTABLE SHELF
IDLFH	BLUM INTERNAL DRAWER LEGRABOX FREE HIGH - 177 MM
IDLFL	BLUM INTERNAL DRAWER LEGRABOX FREE LOW - 177 MM
IDLPC	BLUM INTERNAL DRAWER LEGRABOX PURE C - 177 MM
IDLPF	BLUM INTERNAL DRAWER LEGRABOX PURE F - 241 MM
IDLPK	BLUM INTERNAL DRAWER LEGRABOX PURE K - 128.5 MM
IDLPM	BLUM INTERNAL DRAWER LEGRABOX PURE M - 90.5 MM
IDM	BLUM INTERNAL DRAWER MOVENTO (MELAMINE DRAWER BOX)
IFS	INTERNAL FIXED SHELF
IFB	INTERNAL HINGE DOOR - BLUM ONYX BLACK HINGES
IFD	INTERNAL HINGE DOOR - BLUM NICKEL PLATED HINGES
IPAS	INTERNAL PULLOUT ANGLED SHOE SHELF
IPS	INTERNAL PULLOUT SHELF
MJ	MITRE JOIN
PS	PULLOUT SHELF
RD	RETRACTABLE DOOR
SL	SEAM LINE
SP	SLIDING PANEL
STSM	SUBJECT TO SITE MEASURE
STAS	SUBJECT TO APPLIANCE SPECS

Ⓟ	BI-FOLD OPERATION
Ⓡ	FINGER GRIP OPERATION WITH BLUMOTION
Ⓜ	MANUAL OPERATION WITH BLUMOTION
Ⓟ	PUSH TOUCH OPERATION WITH BLUM TIP ON FOR DOORS
Ⓡ	TIP ON OPERATION WITH BLUMOTION FOR DRAWERS
Ⓢ	SERVO-DRIVE OPERATION - BLUM
Ⓜ	AMBIALINE - BLUM INNER DIVIDER SYSTEM - LEGRABOX
Ⓢ	ORGALINE - BLUM INNER DIVIDER SYSTEM - MOVENTO

SCALE BAR

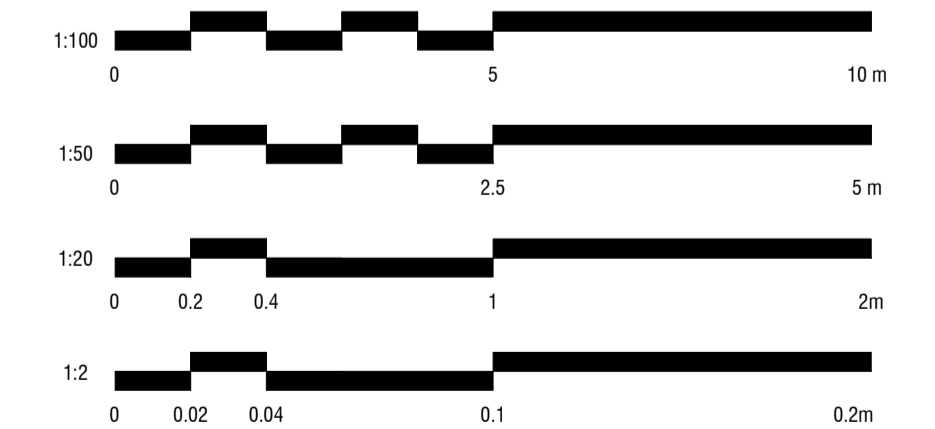

ALL MEASUREMENTS TO BE CHECKED BY TRADES ONSITE*

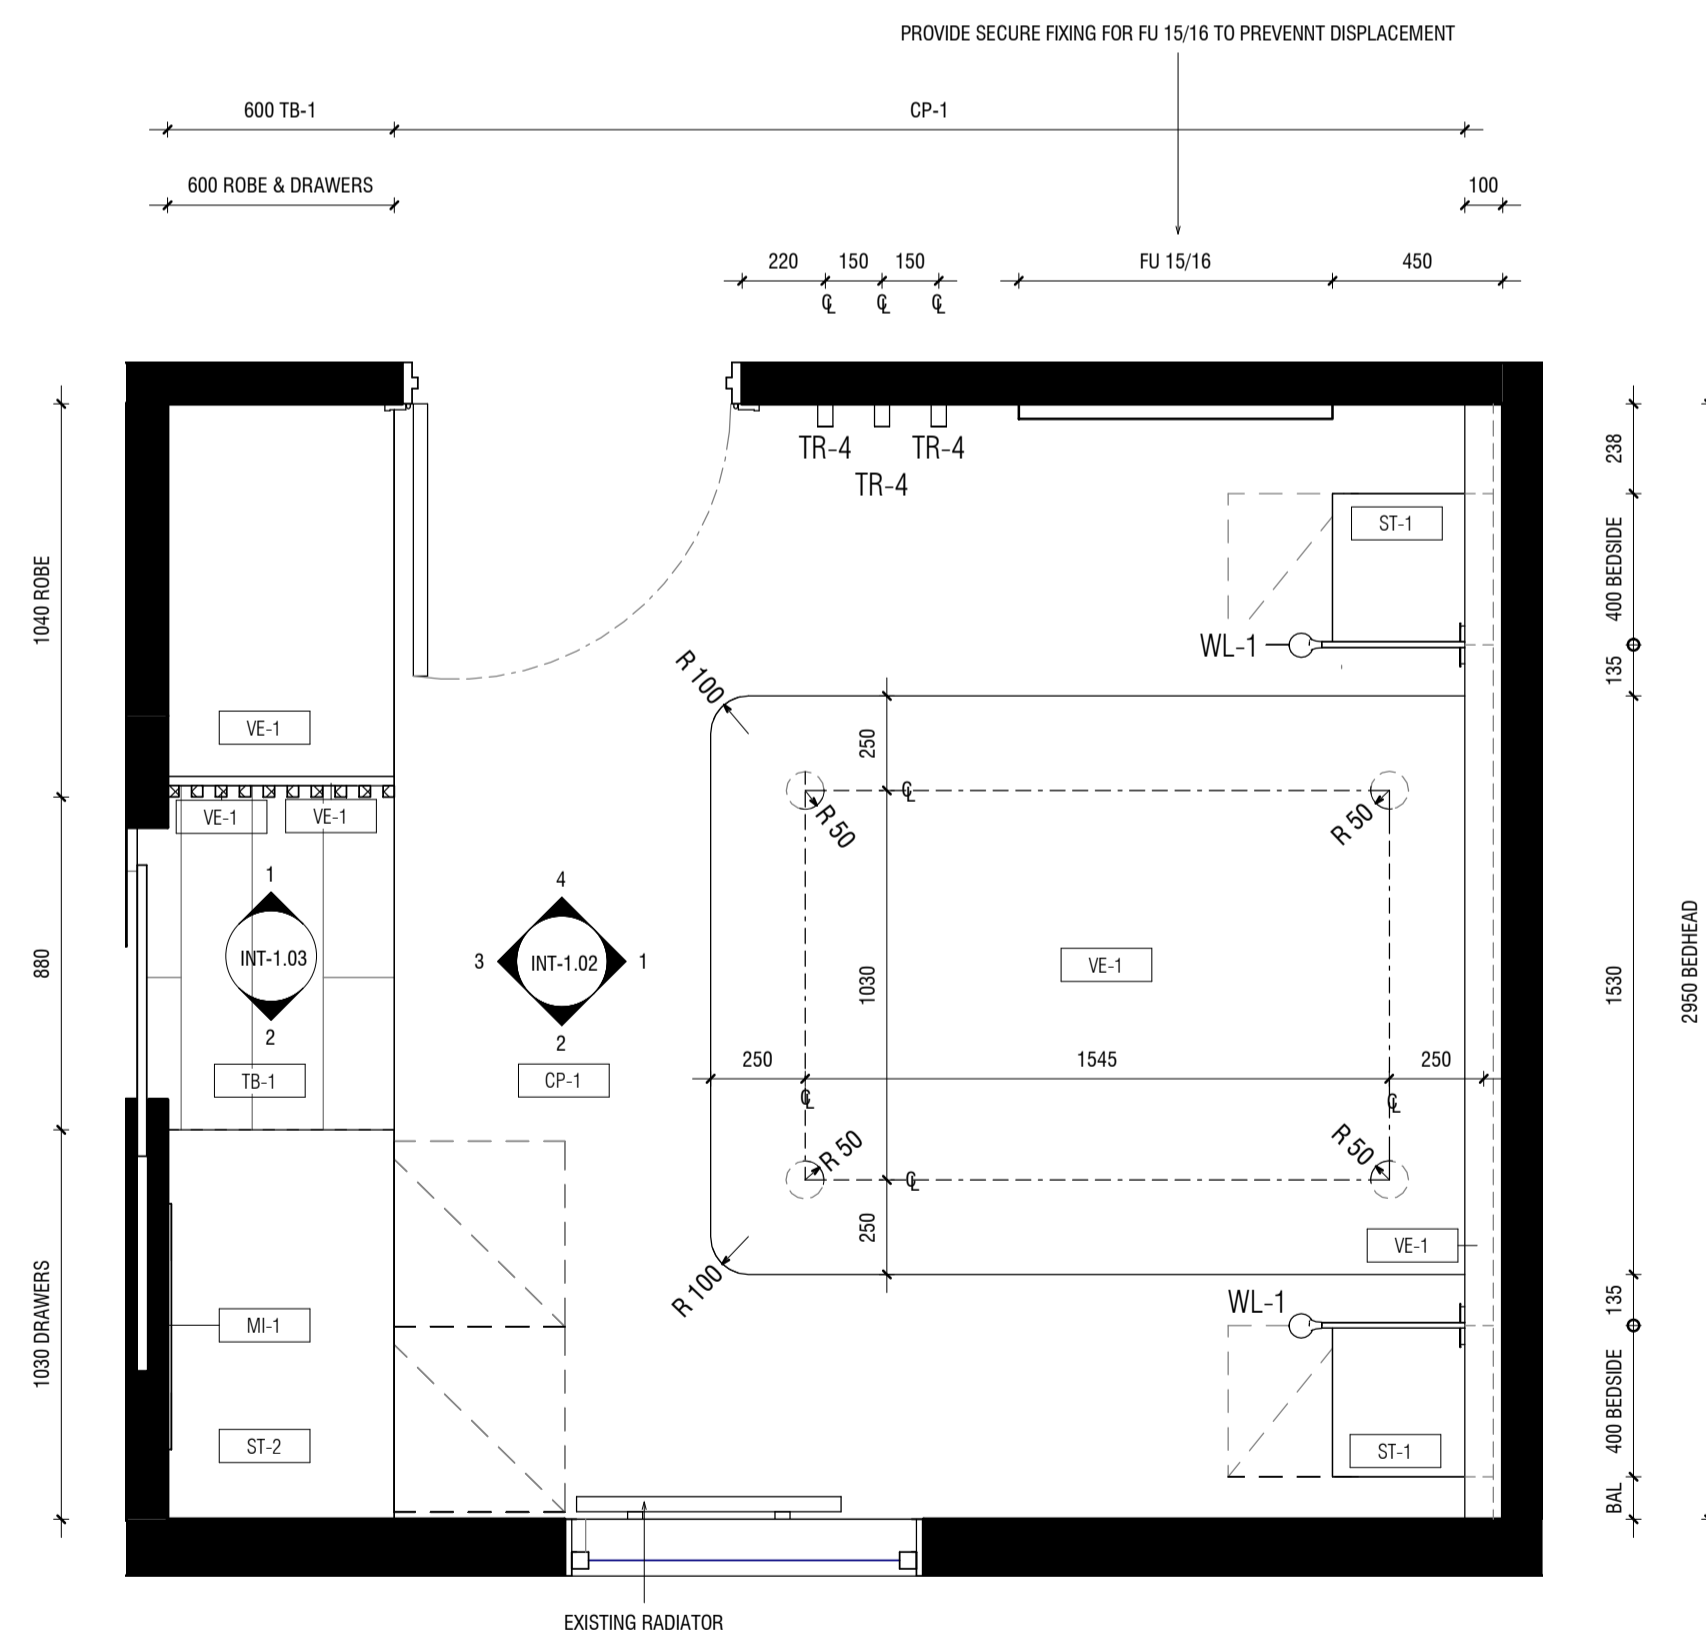

NOTE: TB-2 TO RUN INTO WINDOW REVEAL ON ALL FACES

1 TYPICAL BEDROOM FLOOR PLAN
1:20

CHRISTOPHER
ELLIOTT


CHRISTOPHER ELLIOTT DESIGN PTY LTD
ABN 33131218650 ACN 131218650
T+61 (03)9077 8133 M +61 (0)403 653 649
INFO@CHRISTOPHERELLIOTTDESIGN.COM.AU
PO BOX 124 PRAHRAN 3181 VICTORIA AUSTRALIA

CLIENT AUSTRALIAN ALPINE CLUB
PROJECT ALPINE ROAD, HOTHAM HEIGHTS VIC 3741

All rights reserved. This document remains the property of Christopher Elliott Design Pty Ltd and is only to be used for its commissioned purpose. No part of this document may be reproduced, modified or transmitted in any form or by any means without the explicit written authority of Christopher Elliott Design Pty Ltd. Unauthorised use of this document in any form whatsoever is prohibited.

TITLE TYPICAL BEDROOM
SCALE @ A1 AS INDICATED
CHECKED BY CE
SHEET INT-1.01


PLOT DATE 05.06.20
DRAWN BY CA
REVISION A

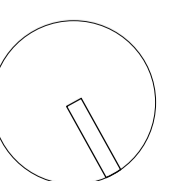


CONSTRUCTION ISSUE

REVISION STATUS

REV.	DESCRIPTION	DATE
A	REVISION #3 CONSTRUCTION DOCS ISSUED	05.06.20

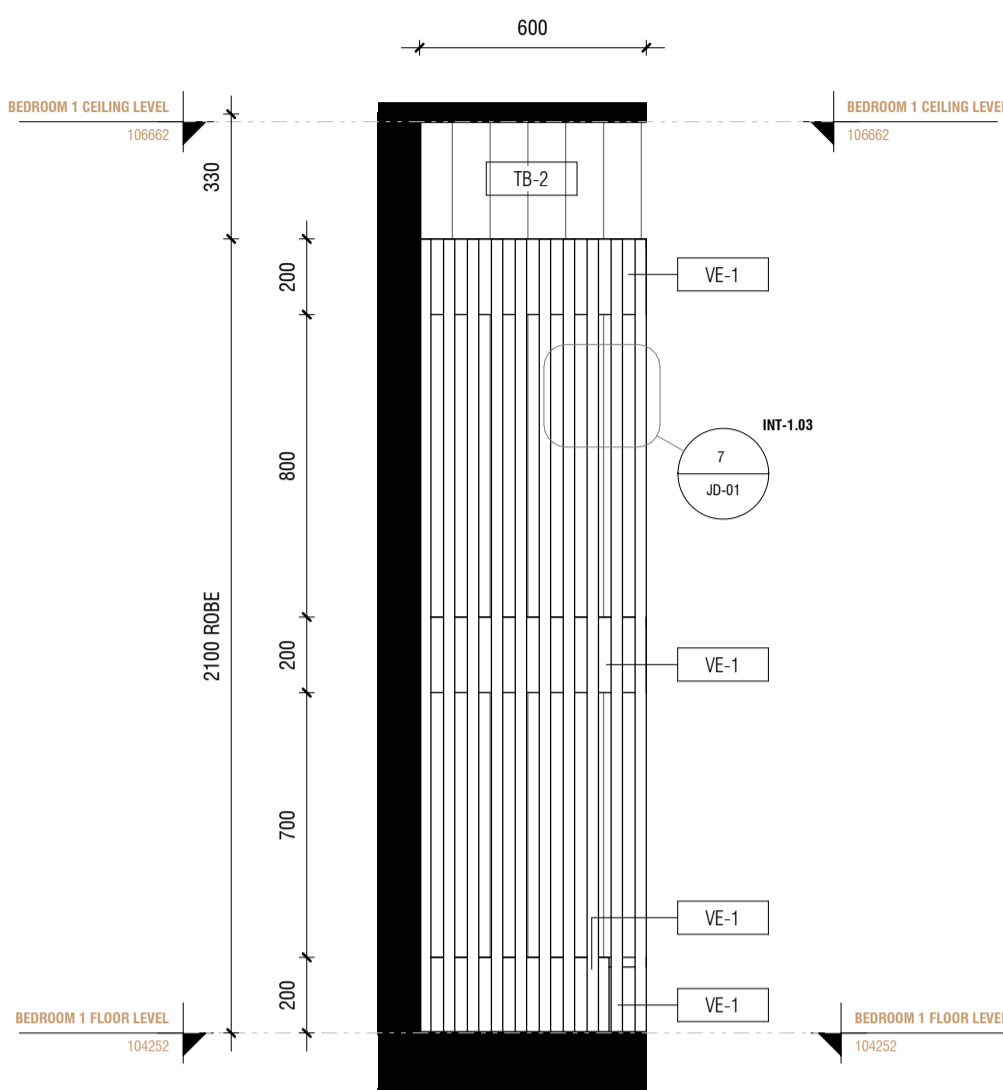

1 INT-1.03 TYPICAL BEDROOM ELEVATION 1
1 : 20

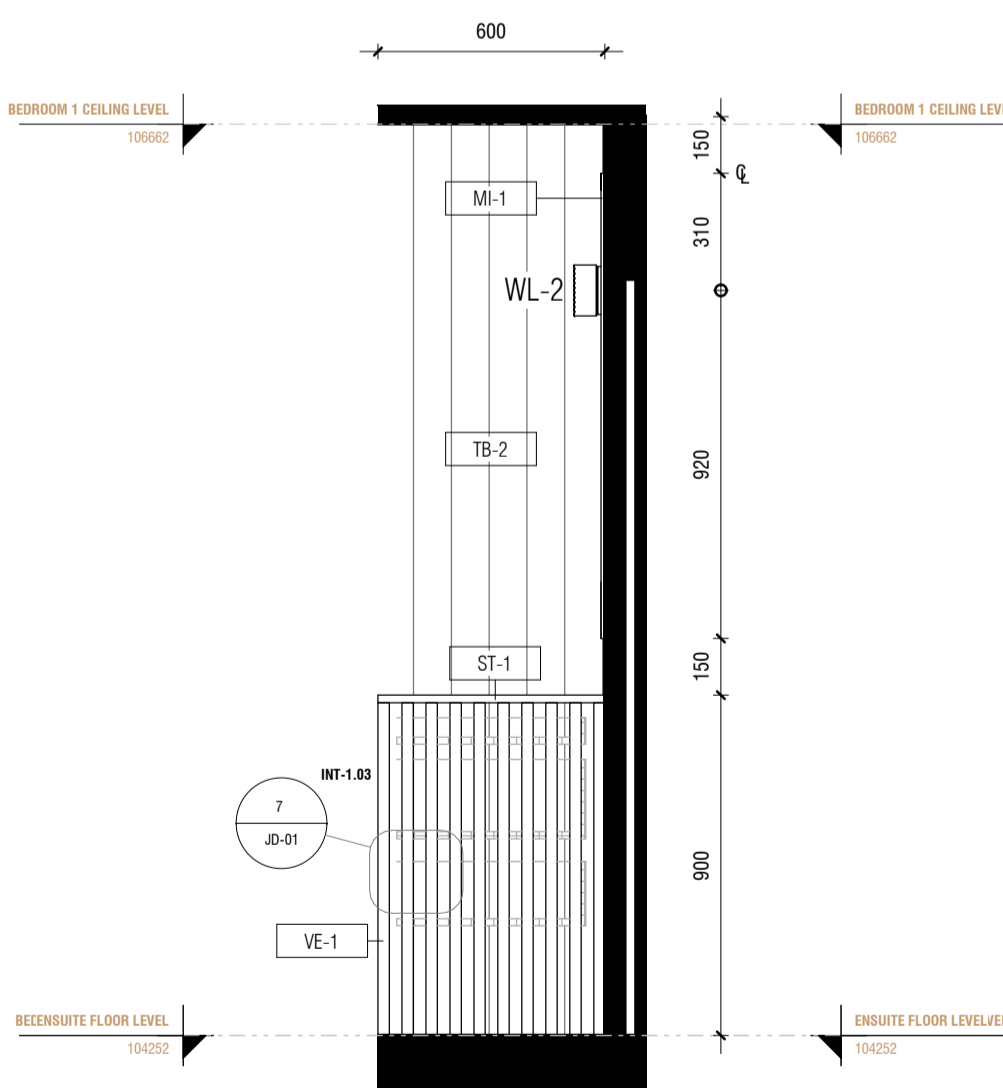


2 INT-1.03 TYPICAL BEDROOM ELEVATION 2
1 : 20

JOINERY

AS	ADJUSTABLE SHELF
AL	ALIGN
BAL	BALANCE
BS	BIFOLD SLIDING
CL	CENTRE LINE
DA	DOOR ACTIVATED
DLFH	BLUM DRAWER LEGRABOX FREE HIGH - 177 MM
DLFL	BLUM DRAWER LEGRABOX FREE LOW - 177 MM
DLPC	BLUM DRAWER LEGRABOX PURE C - 177 MM
DLPF	BLUM DRAWER LEGRABOX PURE F - 241 MM
DLPK	BLUM DRAWER LEGRABOX PURE K - 128.5 MM
DLPM	BLUM DRAWER LEGRABOX PURE M - 90.5 MM
DM	BLUM DRAWER MOVENTO (MELAMINE DRAWER BOX)
EQ	EQUAL
FS	FIXED SHELF
FP	FIXED PANNEL
HDB	HINGE DOOR - BLUM ONYX BLACK HINGES
HDN	HINGE DOOR - BLUM NICKEL PLATED HINGES
HF	HINGE FLAP
HR	HANGING RAIL
IAS	INTERNAL ADJUSTABLE SHELF
IDLFH	BLUM INTERNAL DRAWER LEGRABOX FREE HIGH - 177 MM
IDLFL	BLUM INTERNAL DRAWER LEGRABOX FREE LOW - 177 MM
IDLPC	BLUM INTERNAL DRAWER LEGRABOX PURE C - 177 MM
IDLPF	BLUM INTERNAL DRAWER LEGRABOX PURE F - 241 MM
IDLPK	BLUM INTERNAL DRAWER LEGRABOX PURE K - 128.5 MM
IDLPM	BLUM INTERNAL DRAWER LEGRABOX PURE M - 90.5 MM
IDM	BLUM INTERNAL DRAWER MOVENTO (MELAMINE DRAWER BOX)
IFS	INTERNAL FIXED SHELF
IHDB	INTERNAL HINGE DOOR - BLUM ONYX BLACK HINGES
IHDN	INTERNAL HINGE DOOR - BLUM NICKEL PLATED HINGES
IPAS	INTERNAL PULLOUT ANGLED SHOE SHELF
IPS	INTERNAL PULLOUT SHELF
IJ	MITRE JOIN
PS	PULLOUT SHELF
RD	RETRACTABLE DOOR
SL	SEAM LINE
SP	SLIDING PANEL
STSM	SUBJECT TO SITE MEASURE
STAS	SUBJECT TO APPLIANCE SPECS
ⓑ	BI-FOLD OPERATION
Ⓕ	FINGER GRIP OPERATION WITH BLUMOTION
Ⓜ	MANUAL OPERATION WITH BLUMOTION
Ⓟ	PUSH TOUCH OPERATION WITH BLUM TIP ON FOR DOORS
Ⓣ	TIP ON OPERATION WITH BLUMOTION FOR DRAWERS
Ⓢ	SERVO-DRIVE OPERATION - BLUM
ⓐ	AMBIALINE - BLUM INNER DIVIDER SYSTEM - LEGRABOX
ⓑ	ORGALINE - BLUM INNER DIVIDER SYSTEM - MOVENTO

SCALE BAR

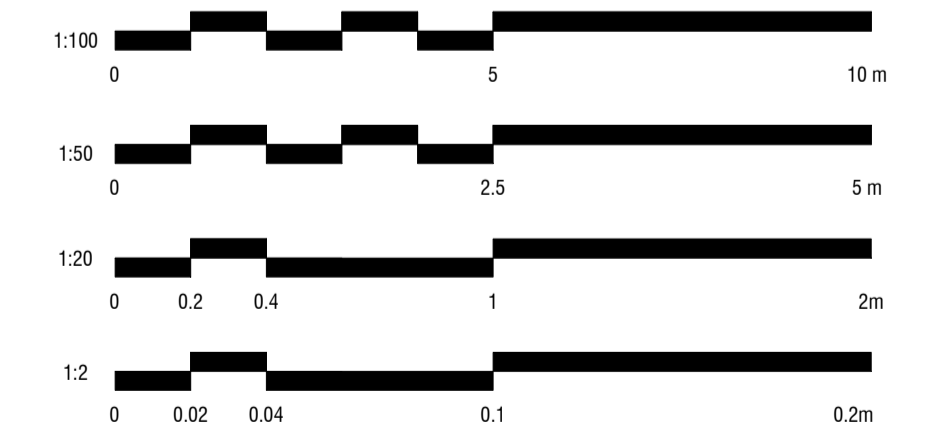

ALL MEASUREMENTS TO BE CHECKED BY TRADES ONSITE*

CHRISTOPHER
ELLIOTT


CHRISTOPHER ELLIOTT DESIGN PTY LTD
ABN 33131218650 ACN 131218650
T+61 (03)9077 8133 M +61 (0)403 653 649
INFO@CHRISTOPHERELLIOTTDESIGN.COM.AU
PO BOX 124 PRAHRAN 3181 VICTORIA AUSTRALIA

CLIENT AUSTRALIAN ALPINE CLUB
PROJECT ALPINE ROAD, HOTHAM HEIGHTS VIC 3741

All rights reserved. This document remains the property of Christopher Elliott Design Pty Ltd and is only to be used for its commissioned purpose. No part of this document may be reproduced, modified or transmitted in any form or by any means without the explicit written authority of Christopher Elliott Design Pty Ltd. Unauthorised use of this document in any form whatsoever is prohibited.

TITLE TYPICAL BEDROOM
SCALE @ A1 AS INDICATED
CHECKED BY CE
SHEET INT-1.03

PLOT DATE 05.06.20
DRAWN BY CA
REVISION A

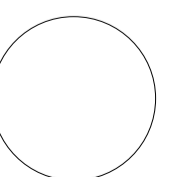

REVISION STATUS


REV.	DESCRIPTION	DATE
A	REVISION #3 CONSTRUCTION DOCS ISSUED	05.06.20

JOINERY


AS	ADJUSTABLE SHELF
AL	ALIGN
BAL	BALANCE
BS	BIFOLD SLIDING
CL	CENTRE LINE
DA	DOOR ACTIVATED
DLFH	BLUM DRAWER LEGRABOX FREE HIGH - 177 MM
DLFL	BLUM DRAWER LEGRABOX FREE LOW - 177 MM
DLPC	BLUM DRAWER LEGRABOX PURE C - 177 MM
DLPF	BLUM DRAWER LEGRABOX PURE F - 241 MM
DLPK	BLUM DRAWER LEGRABOX PURE K - 128.5 MM
DLPM	BLUM DRAWER LEGRABOX PURE M - 90.5 MM
DM	BLUM DRAWER MOVENTO (MELAMINE DRAWER BOX)
EQ	EQUAL
FS	FIXED SHELF
FP	FIXED PANNEL
HDB	HINGE DOOR - BLUM ONYX BLACK HINGES
HDN	HINGE DOOR - BLUM NICKEL PLATED HINGES
HF	HINGE FLAP
HR	HANGING RAIL
IAS	INTERNAL ADJUSTABLE SHELF
IDLFH	BLUM INTERNAL DRAWER LEGRABOX FREE HIGH - 177 MM
IDLFL	BLUM INTERNAL DRAWER LEGRABOX FREE LOW - 177 MM
IDLPC	BLUM INTERNAL DRAWER LEGRABOX PURE C - 177 MM
IDLPF	BLUM INTERNAL DRAWER LEGRABOX PURE F - 241 MM
IDLPK	BLUM INTERNAL DRAWER LEGRABOX PURE K - 128.5 MM
IDLPM	BLUM INTERNAL DRAWER LEGRABOX PURE M - 90.5 MM
IDM	BLUM INTERNAL DRAWER MOVENTO (MELAMINE DRAWER BOX)
IFS	INTERNAL FIXED SHELF
IHDB	INTERNAL HINGE DOOR - BLUM ONYX BLACK HINGES
IHDN	INTERNAL HINGE DOOR - BLUM NICKEL PLATED HINGES
IPAS	INTERNAL PULLOUT ANGLED SHOE SHELF
IPS	INTERNAL PULLOUT SHELF
IJ	MITRE JOIN
IS	PULLOUT SHELF
RD	RETRACTABLE DOOR
SL	SEAM LINE
SP	SLIDING PANEL
STSM	SUBJECT TO SITE MEASURE
STAS	SUBJECT TO APPLIANCE SPECS

Ⓚ	BI-FOLD OPERATION
Ⓛ	FINGER GRIP OPERATION WITH BLUMOTION
Ⓜ	MANUAL OPERATION WITH BLUMOTION
Ⓟ	PUSH TOUCH OPERATION WITH BLUM TIP ON FOR DOORS
Ⓡ	TIP ON OPERATION WITH BLUMOTION FOR DRAWERS
Ⓢ	SERVO-DRIVE OPERATION - BLUM
Ⓛ	AMBIALINE - BLUM INNER DIVIDER SYSTEM - LEGRABOX
Ⓞ	ORGALINE - BLUM INNER DIVIDER SYSTEM - MOVENTO

SCALE BAR

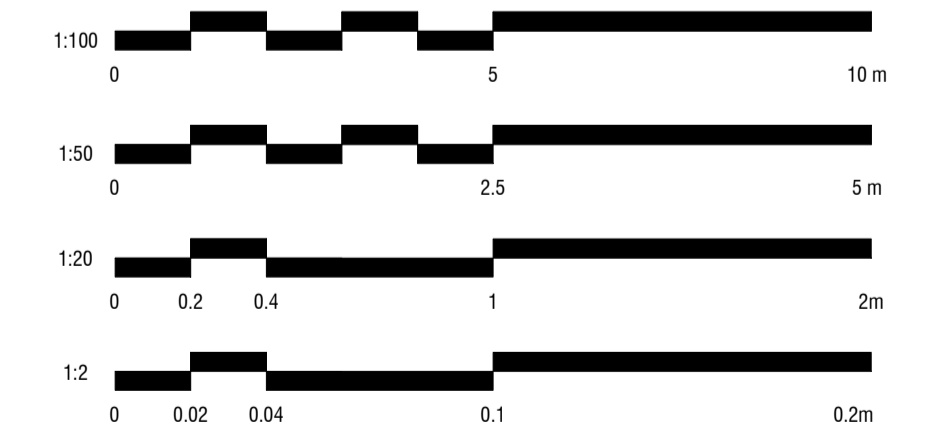

ALL MEASUREMENTS TO BE CHECKED BY TRADES ONSITE*

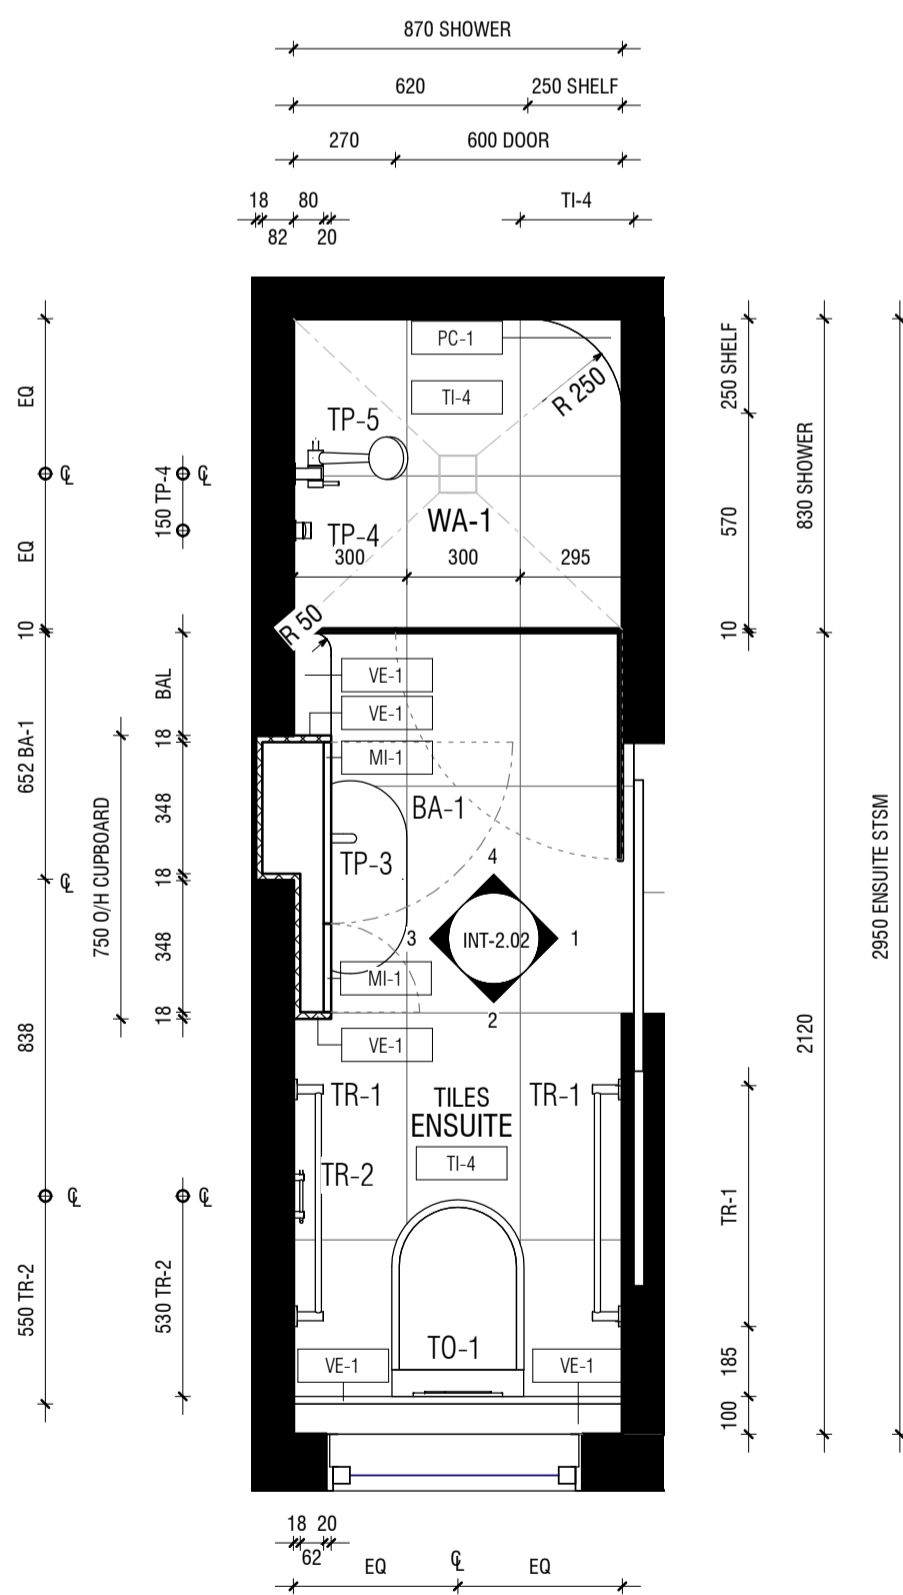

NOTE: EZY REVEAL TO WINDOW REVEAL

1 TYPICAL ENSUITE FLOOR PLAN
1 : 20

CHRISTOPHER
ELLIOTT


CHRISTOPHER ELLIOTT DESIGN PTY LTD
ABN 33131218650 ACN 131218650
T +61 (03)9077 8133 M +61 (0)403 653 649
INFO@CHRISTOPHERELLIOTTDESIGN.COM.AU
PO BOX 124 PRAHRAN 3181 VICTORIA AUSTRALIA

CLIENT AUSTRALIAN ALPINE CLUB
PROJECT ALPINE ROAD, HOTHAM HEIGHTS VIC 3741

All rights reserved. This document remains the property of Christopher Elliott Design Pty Ltd and is only to be used for its commissioned purpose. No part of this document may be reproduced, modified or transmitted in any form or by any means without the explicit written authority of Christopher Elliott Design Pty Ltd. Unauthorised use of this document in any form whatsoever is prohibited.

TITLE TYPICAL ENSUITE
SCALE @ A1 AS INDICATED
CHECKED BY CE
SHEET INT-2.01

PLOT DATE 05.06.20
DRAWN BY CA
REVISION A

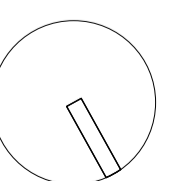

REVISION STATUS


REV.	DESCRIPTION	DATE
A	REVISION #3 CONSTRUCTION DOCS ISSUED	05.06.20

JOINERY


AS	ADJUSTABLE SHELF
AL	ALIGN
BAL	BALANCE
BS	BIFOLD SLIDING
CL	CENTRE LINE
DA	DOOR ACTIVATED
DLFH	BLUM DRAWER LEGRABOX FREE HIGH - 177 MM
DLFL	BLUM DRAWER LEGRABOX FREE LOW - 177 MM
DLPC	BLUM DRAWER LEGRABOX PURE C - 177 MM
DLPF	BLUM DRAWER LEGRABOX PURE F - 241 MM
DLPK	BLUM DRAWER LEGRABOX PURE K - 128.5 MM
DLPM	BLUM DRAWER LEGRABOX PURE M - 90.5 MM
DM	BLUM DRAWER MOVENTO (MELAMINE DRAWER BOX)
EQ	EQUAL
FS	FIXED SHELF
FP	FIXED PANNEL
HDB	HINGE DOOR - BLUM ONYX BLACK HINGES
HDN	HINGE DOOR - BLUM NICKEL PLATED HINGES
HF	HINGE FLAP
HR	HANGING RAIL
IAS	INTERNAL ADJUSTABLE SHELF
IDLFH	BLUM INTERNAL DRAWER LEGRABOX FREE HIGH - 177 MM
IDLFL	BLUM INTERNAL DRAWER LEGRABOX FREE LOW - 177 MM
IDLPC	BLUM INTERNAL DRAWER LEGRABOX PURE C - 177 MM
IDLPF	BLUM INTERNAL DRAWER LEGRABOX PURE F - 241 MM
IDLPK	BLUM INTERNAL DRAWER LEGRABOX PURE K - 128.5 MM
IDLPM	BLUM INTERNAL DRAWER LEGRABOX PURE M - 90.5 MM
IDM	BLUM INTERNAL DRAWER MOVENTO (MELAMINE DRAWER BOX)
IFS	INTERNAL FIXED SHELF
IHDB	INTERNAL HINGE DOOR - BLUM ONYX BLACK HINGES
IHDN	INTERNAL HINGE DOOR - BLUM NICKEL PLATED HINGES
IPAS	INTERNAL PULLOUT ANGLED SHOE SHELF
IPS	INTERNAL PULLOUT SHELF
MJ	MITRE JOIN
PS	PULLOUT SHELF
RD	RETRACTABLE DOOR
SL	SEAM LINE
SP	SLIDING PANEL
STSM	SUBJECT TO SITE MEASURE
STAS	SUBJECT TO APPLIANCE SPECS

Ⓟ	BI-FOLD OPERATION
Ⓡ	FINGER GRIP OPERATION WITH BLUMOTION
Ⓜ	MANUAL OPERATION WITH BLUMOTION
Ⓟ	PUSH TOUCH OPERATION WITH BLUM TIP ON FOR DOORS
Ⓡ	TIP ON OPERATION WITH BLUMOTION FOR DRAWERS
Ⓢ	SERVO-DRIVE OPERATION - BLUM
Ⓜ	AMBIALINE - BLUM INNER DIVIDER SYSTEM - LEGRABOX
Ⓡ	ORGALINE - BLUM INNER DIVIDER SYSTEM - MOVENTO


SCALE BAR

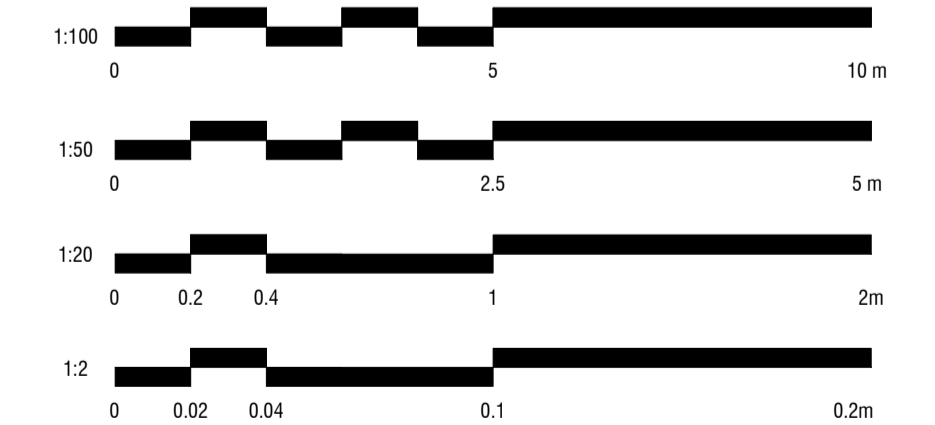


ALL MEASUREMENTS TO BE CHECKED BY TRADES ONSITE*

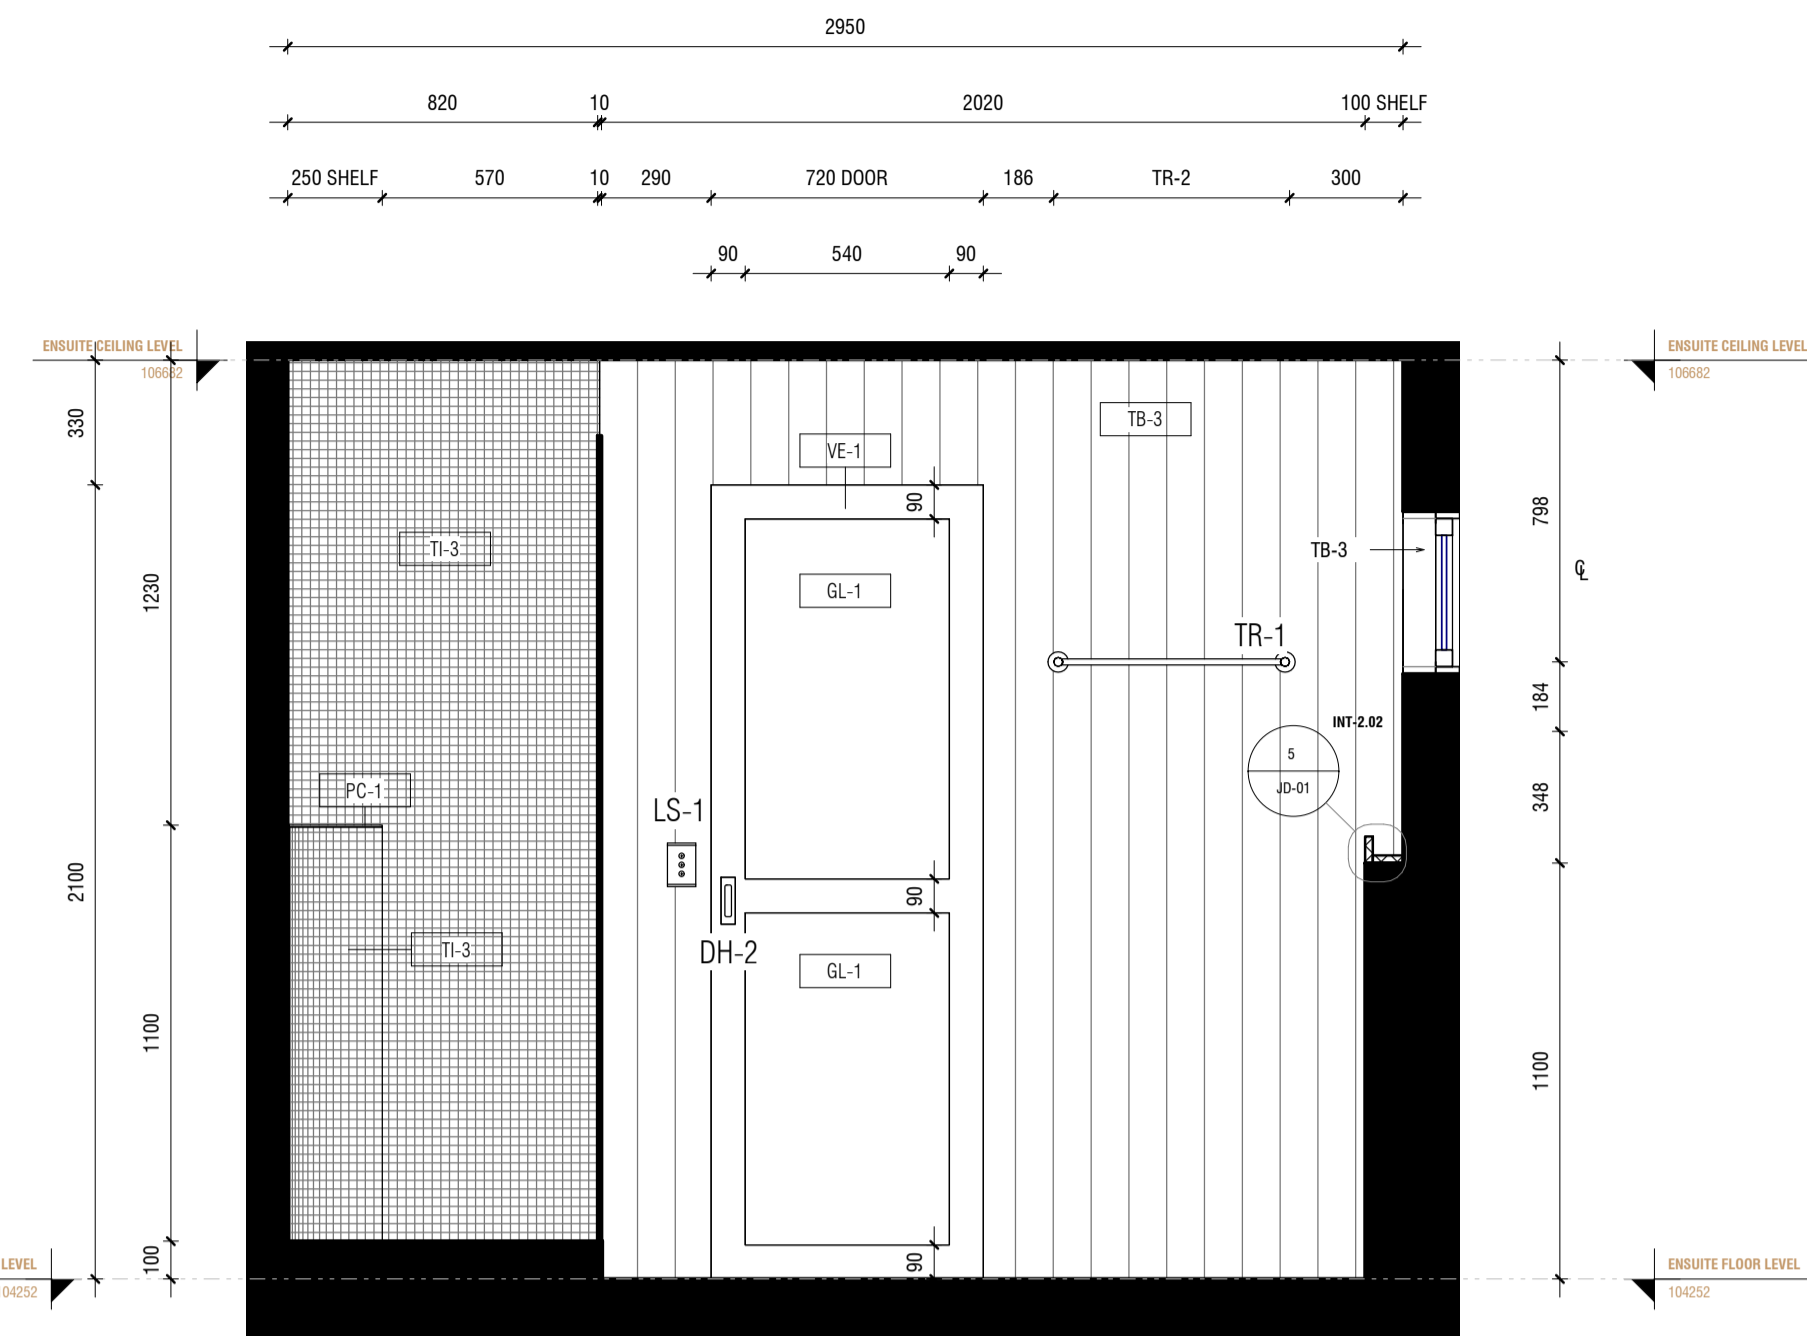


1 INT-2.01 TYPICAL ENSUITE ELEVATION 1
1 : 20

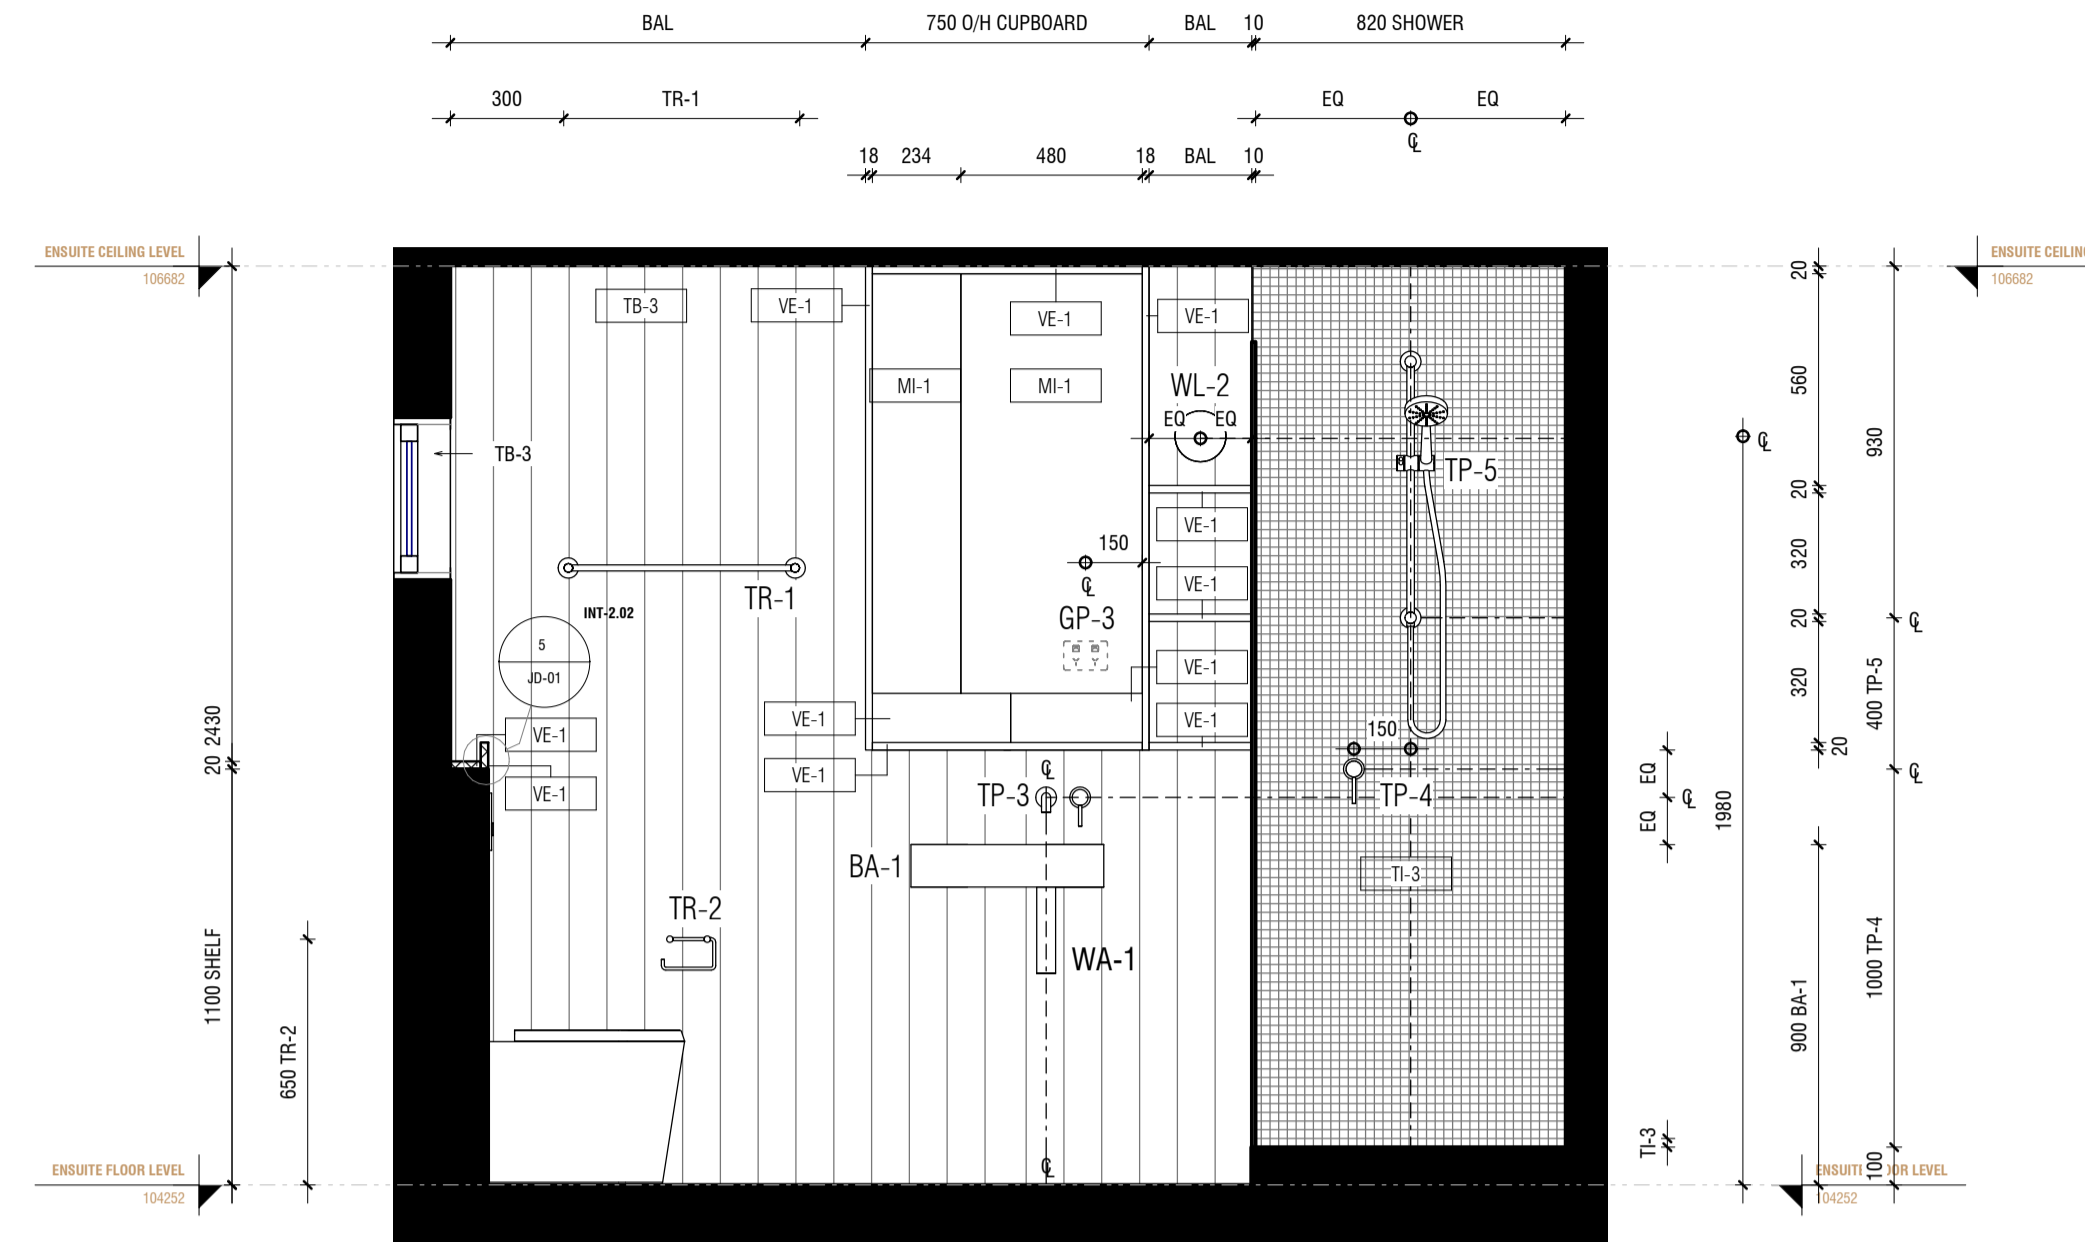

3 INT-2.01 TYPICAL ENSUITE ELEVATION 3
1 : 20

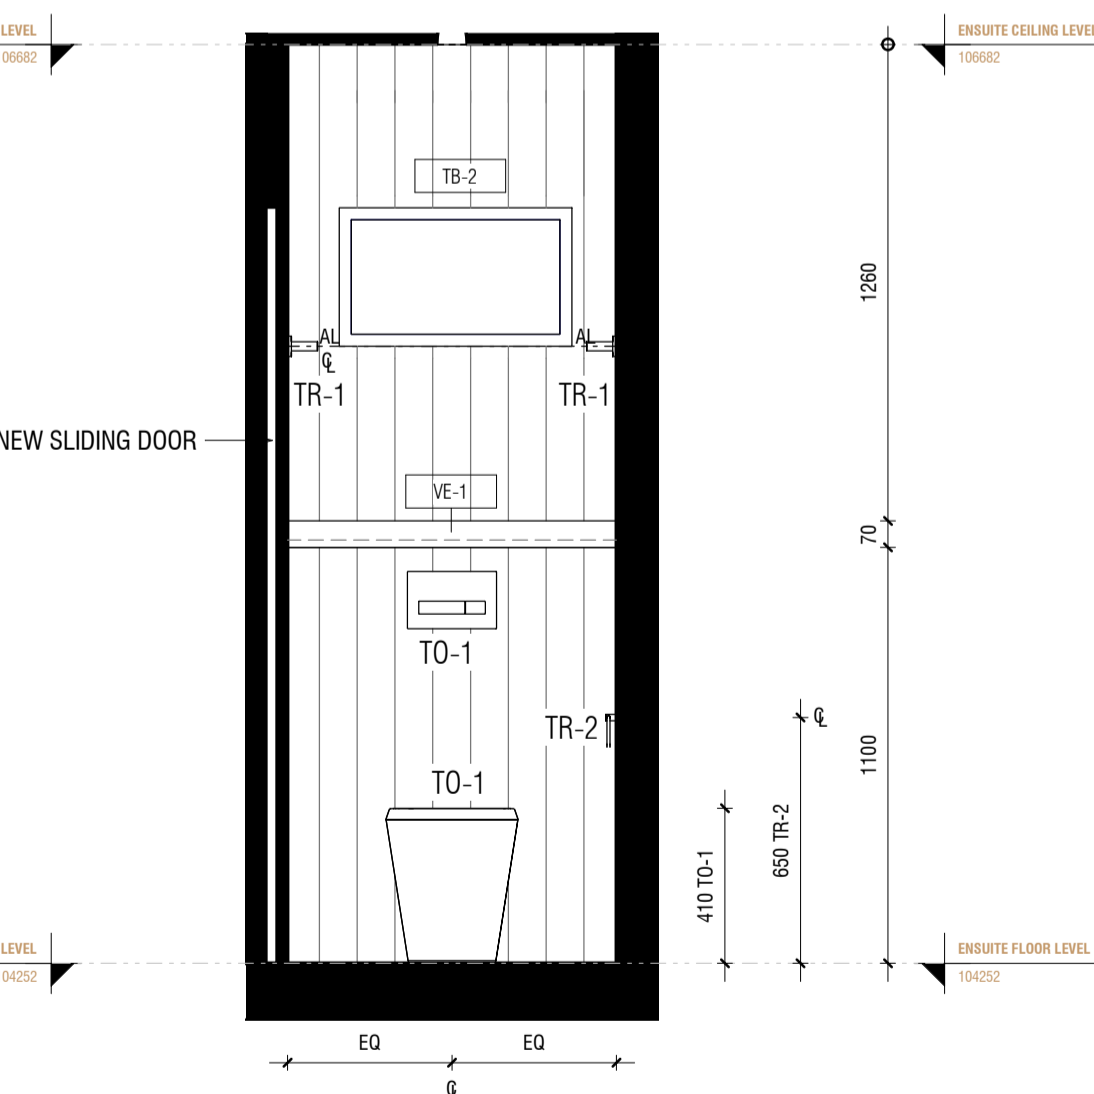

2 INT-2.01 TYPICAL ENSUITE ELEVATION 2
1 : 20

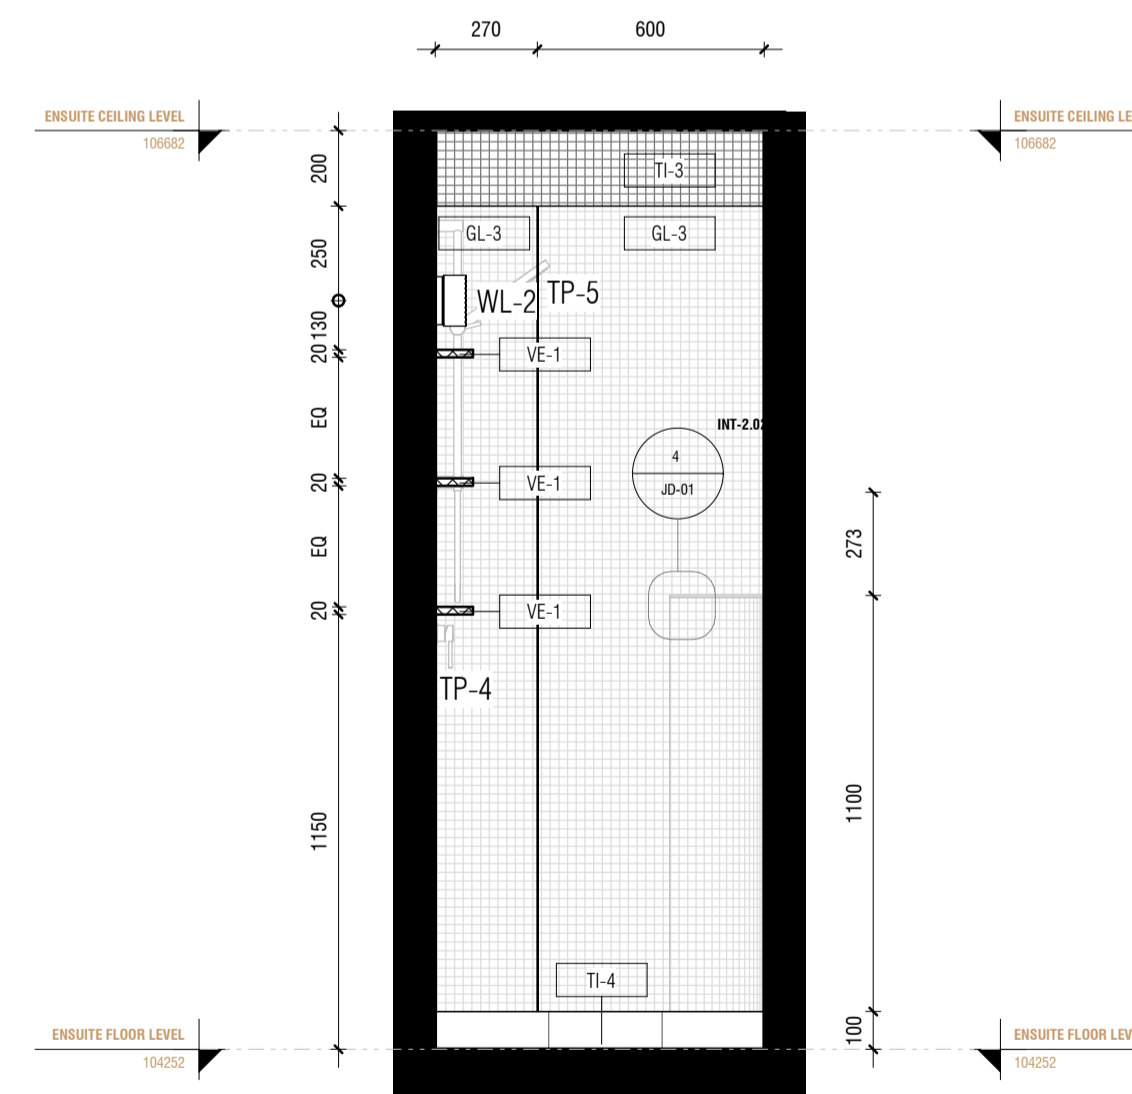

4 INT-2.01 TYPICAL ENSUITE ELEVATION 4
1 : 20

CHRISTOPHER
ELLIOTT


CHRISTOPHER ELLIOTT DESIGN PTY LTD
ABN 33131218650 ACN 131218650
T +61 (03)9077 8133 M +61 (0)403 653 649
INFO@CHRISTOPHERELLIOTTDESIGN.COM.AU
PO BOX 124 PRAHRAN 3181 VICTORIA AUSTRALIA

CLIENT AUSTRALIAN ALPINE CLUB
PROJECT ALPINE ROAD, HOTHAM HEIGHTS VIC 3741

All rights reserved. This document remains the property of Christopher Elliott Design Pty Ltd and is only to be used for its commissioned purpose. No part of this document may be reproduced, modified or transmitted in any form or by any means without the explicit written authority of Christopher Elliott Design Pty Ltd. Unauthorised use of this document in any form whatsoever is prohibited.


TITLE TYPICAL ENSUITE
SCALE @ A1 AS INDICATED
CHECKED BY CE
SHEET INT-2.02

PLOT DATE 05.06.20
DRAWN BY CA
REVISION A

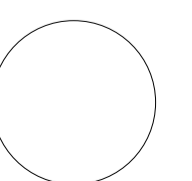

REVISION STATUS

REV.	DESCRIPTION	DATE
A	REVISION #1 CONCEPT PLANS ISSUED	23.04.20
B	REVISION #3 CONSTRUCTION DOCS ISSUED	05.06.20


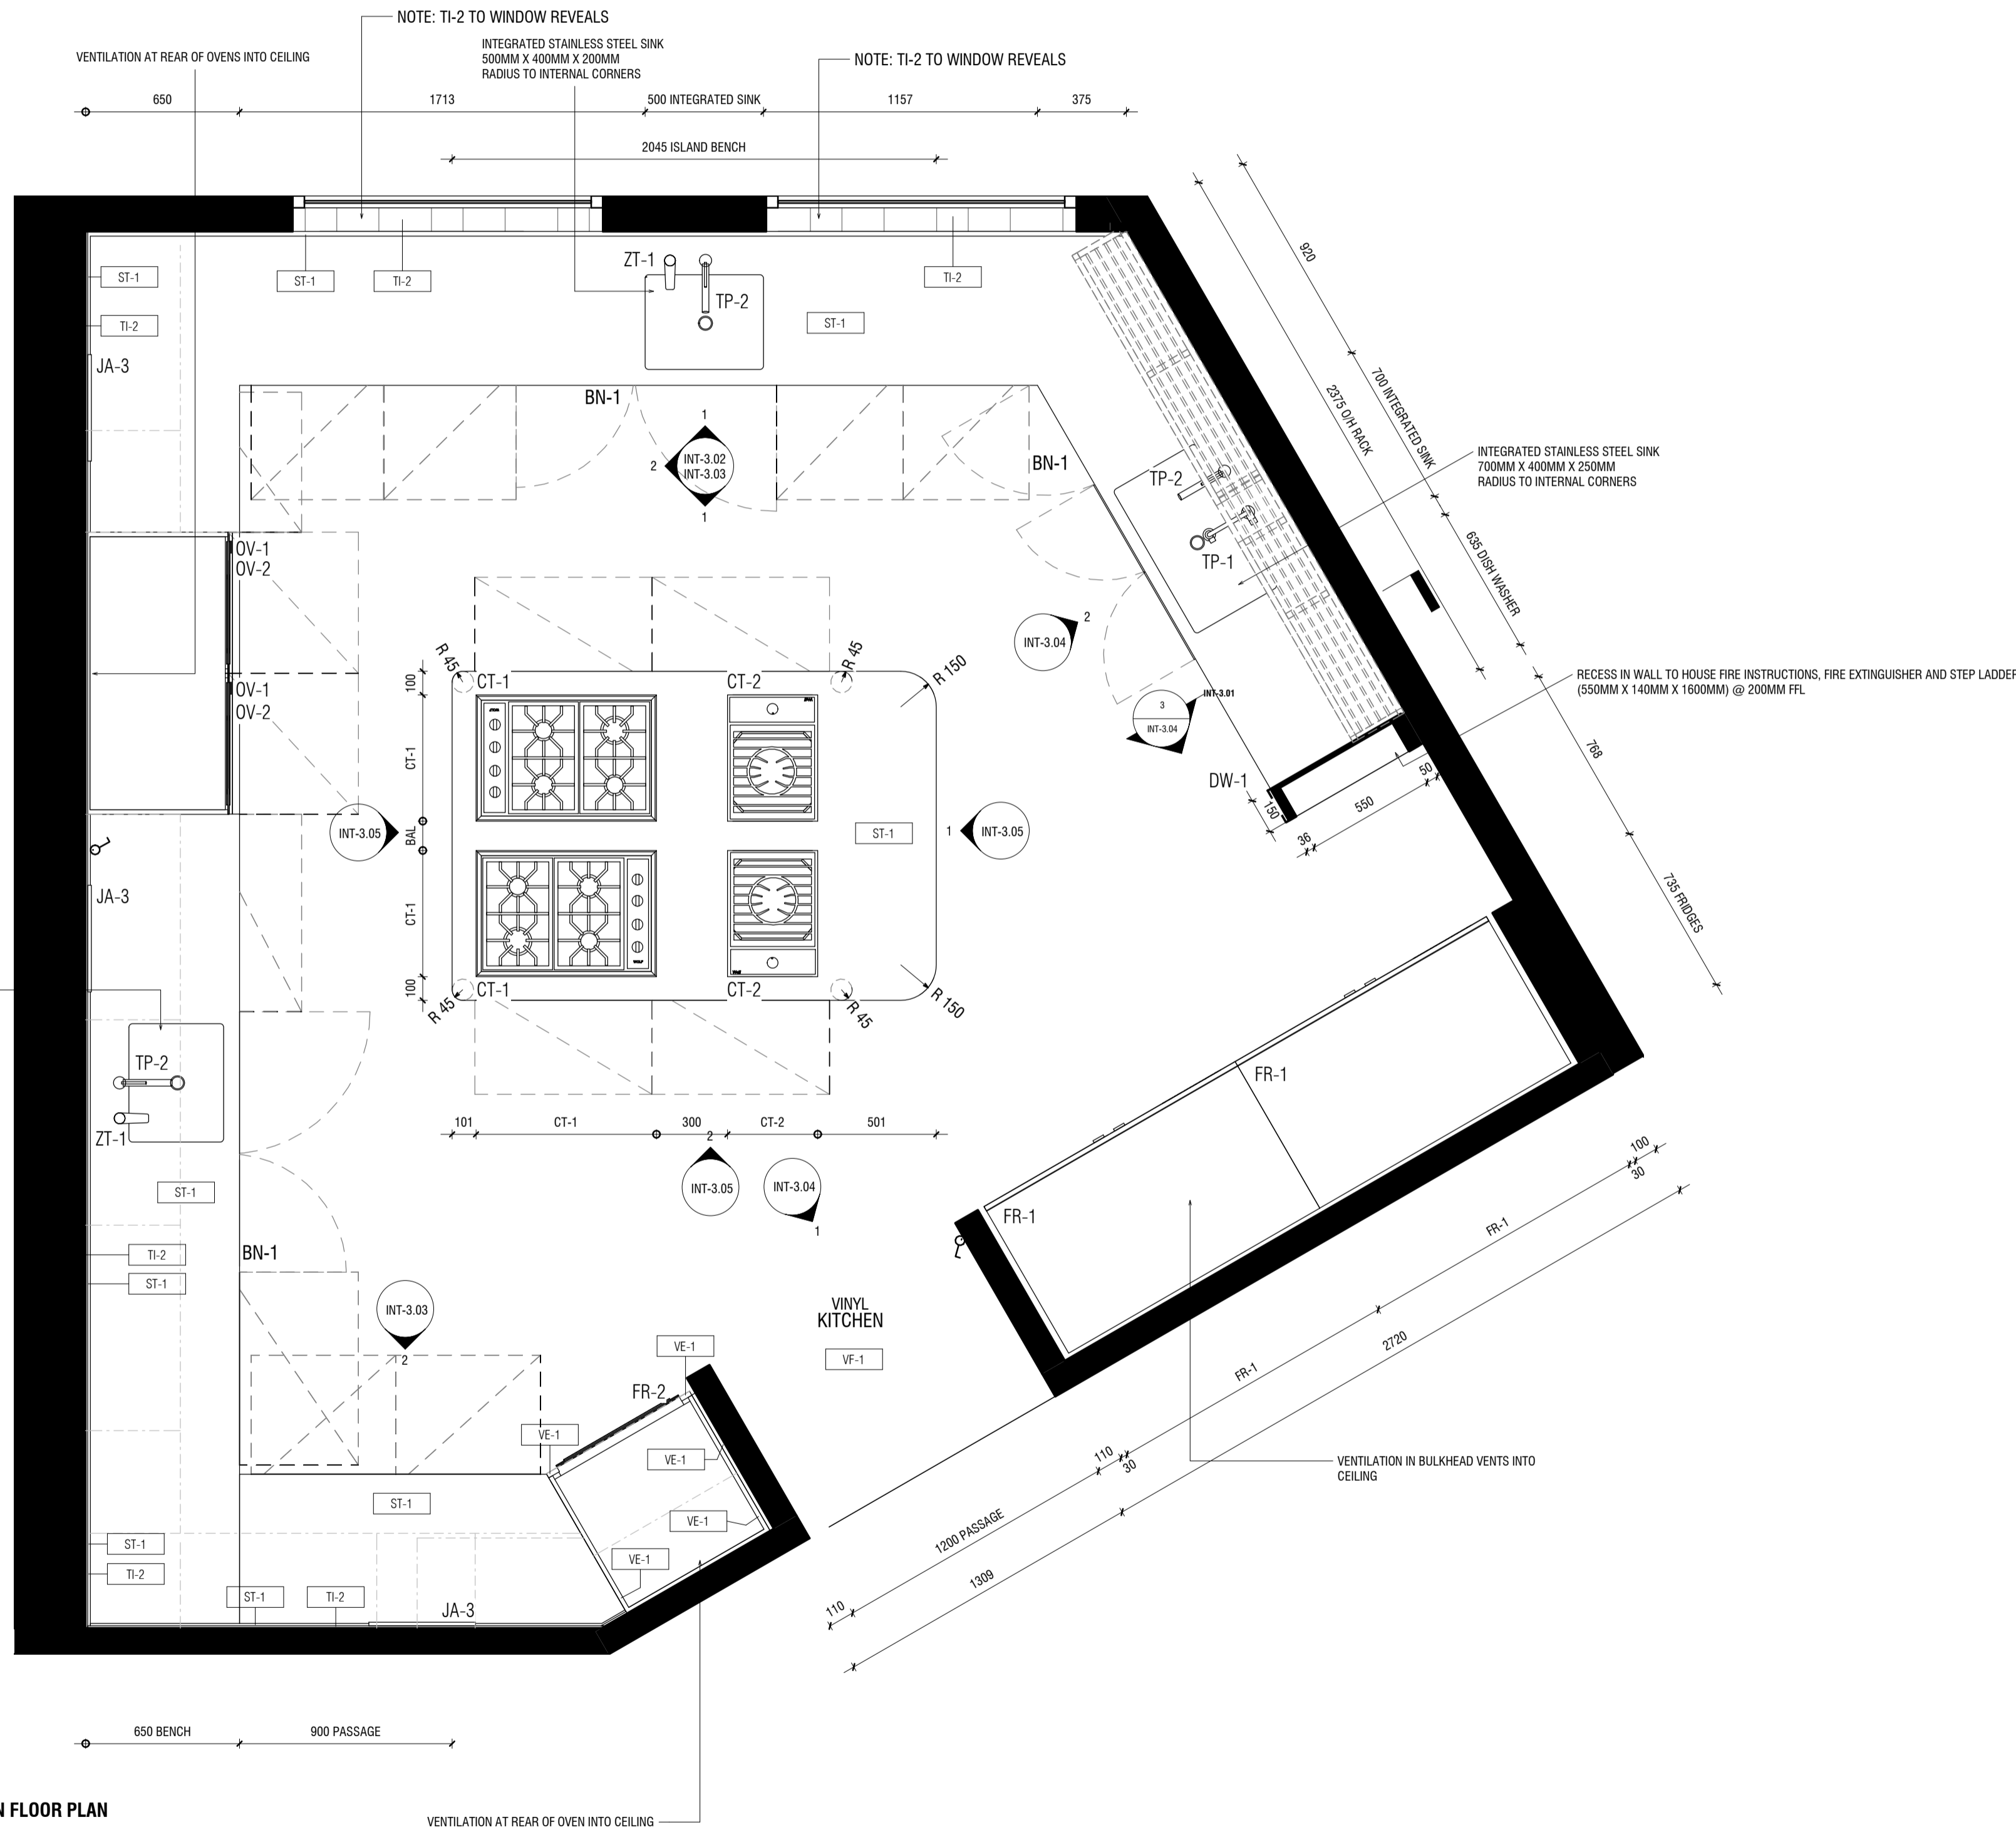


1 KITCHEN FLOOR PLAN
1 : 20

JOINERY

AS	ADJUSTABLE SHELF
AL	ALIGN
BAL	BALANCE
BS	BIFOLD SLIDING
CL	CENTRE LINE
DA	DOOR ACTIVATED
DLFH	BLUM DRAWER LEGRABOX FREE HIGH - 177 MM
DLFL	BLUM DRAWER LEGRABOX FREE LOW - 177 MM
DLPC	BLUM DRAWER LEGRABOX PURE C - 177 MM
DLPF	BLUM DRAWER LEGRABOX PURE F - 241 MM
DLPK	BLUM DRAWER LEGRABOX PURE K - 128.5 MM
DLPM	BLUM DRAWER LEGRABOX PURE M - 90.5 MM
DM	BLUM DRAWER MOVENTO (MELAMINE DRAWER BOX)
EQ	EQUAL
FS	FIXED SHELF
FP	FIXED PANNEL
HDB	HINGE DOOR - BLUM ONYX BLACK HINGES
HDN	HINGE DOOR - BLUM NICKEL PLATED HINGES
HF	HINGE FLAP
HR	HANGING RAIL
IAS	INTERNAL ADJUSTABLE SHELF
IDLFH	BLUM INTERNAL DRAWER LEGRABOX FREE HIGH - 177 MM
IDLFL	BLUM INTERNAL DRAWER LEGRABOX FREE LOW - 177 MM
IDLPC	BLUM INTERNAL DRAWER LEGRABOX PURE C - 177 MM
IDLPF	BLUM INTERNAL DRAWER LEGRABOX PURE F - 241 MM
IDLPK	BLUM INTERNAL DRAWER LEGRABOX PURE K - 128.5 MM
IDLPM	BLUM INTERNAL DRAWER LEGRABOX PURE M - 90.5 MM
IDM	BLUM INTERNAL DRAWER MOVENTO (MELAMINE DRAWER BOX)
IFS	INTERNAL FIXED SHELF
IHDB	INTERNAL HINGE DOOR - BLUM ONYX BLACK HINGES
IHDN	INTERNAL HINGE DOOR - BLUM NICKEL PLATED HINGES
IPAS	INTERNAL PULLOUT ANGLED SHOE SHELF
IPS	INTERNAL PULLOUT SHELF
MJ	MITRE JOIN
PS	PULLOUT SHELF
RD	RETRACTABLE DOOR
SL	SEAM LINE
SP	SLIDING PANEL
STSM	SUBJECT TO SITE MEASURE
STAS	SUBJECT TO APPLIANCE SPECS
ⓑ	BI-FOLD OPERATION
Ⓕ	FINGER GRIP OPERATION WITH BLUMOTION
Ⓜ	MANUAL OPERATION WITH BLUMOTION
Ⓟ	PUSH TOUCH OPERATION WITH BLUM TIP ON FOR DOORS
Ⓣ	TIP ON OPERATION WITH BLUMOTION FOR DRAWERS
Ⓢ	SERVO-DRIVE OPERATION - BLUM
Ⓜ	AMBIALINE - BLUM INNER DIVIDER SYSTEM - LEGRABOX
Ⓞ	ORGALINE - BLUM INNER DIVIDER SYSTEM - MOVENTO


SCALE BAR

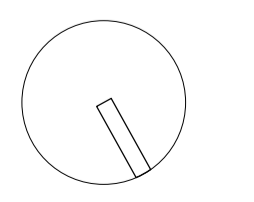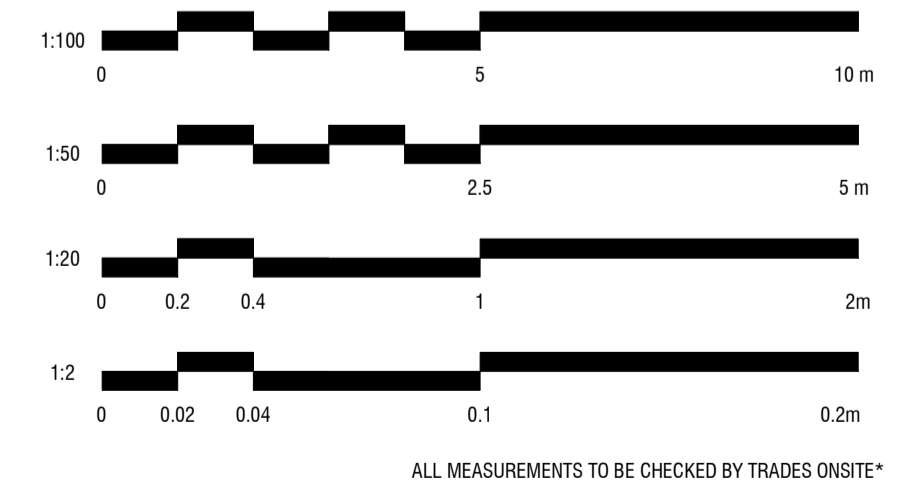


CONSTRUCTION ISSUE

REVISION STATUS

REV.	DESCRIPTION	DATE
A	REVISION #3 CONSTRUCTION DOCS ISSUED	05.06.20

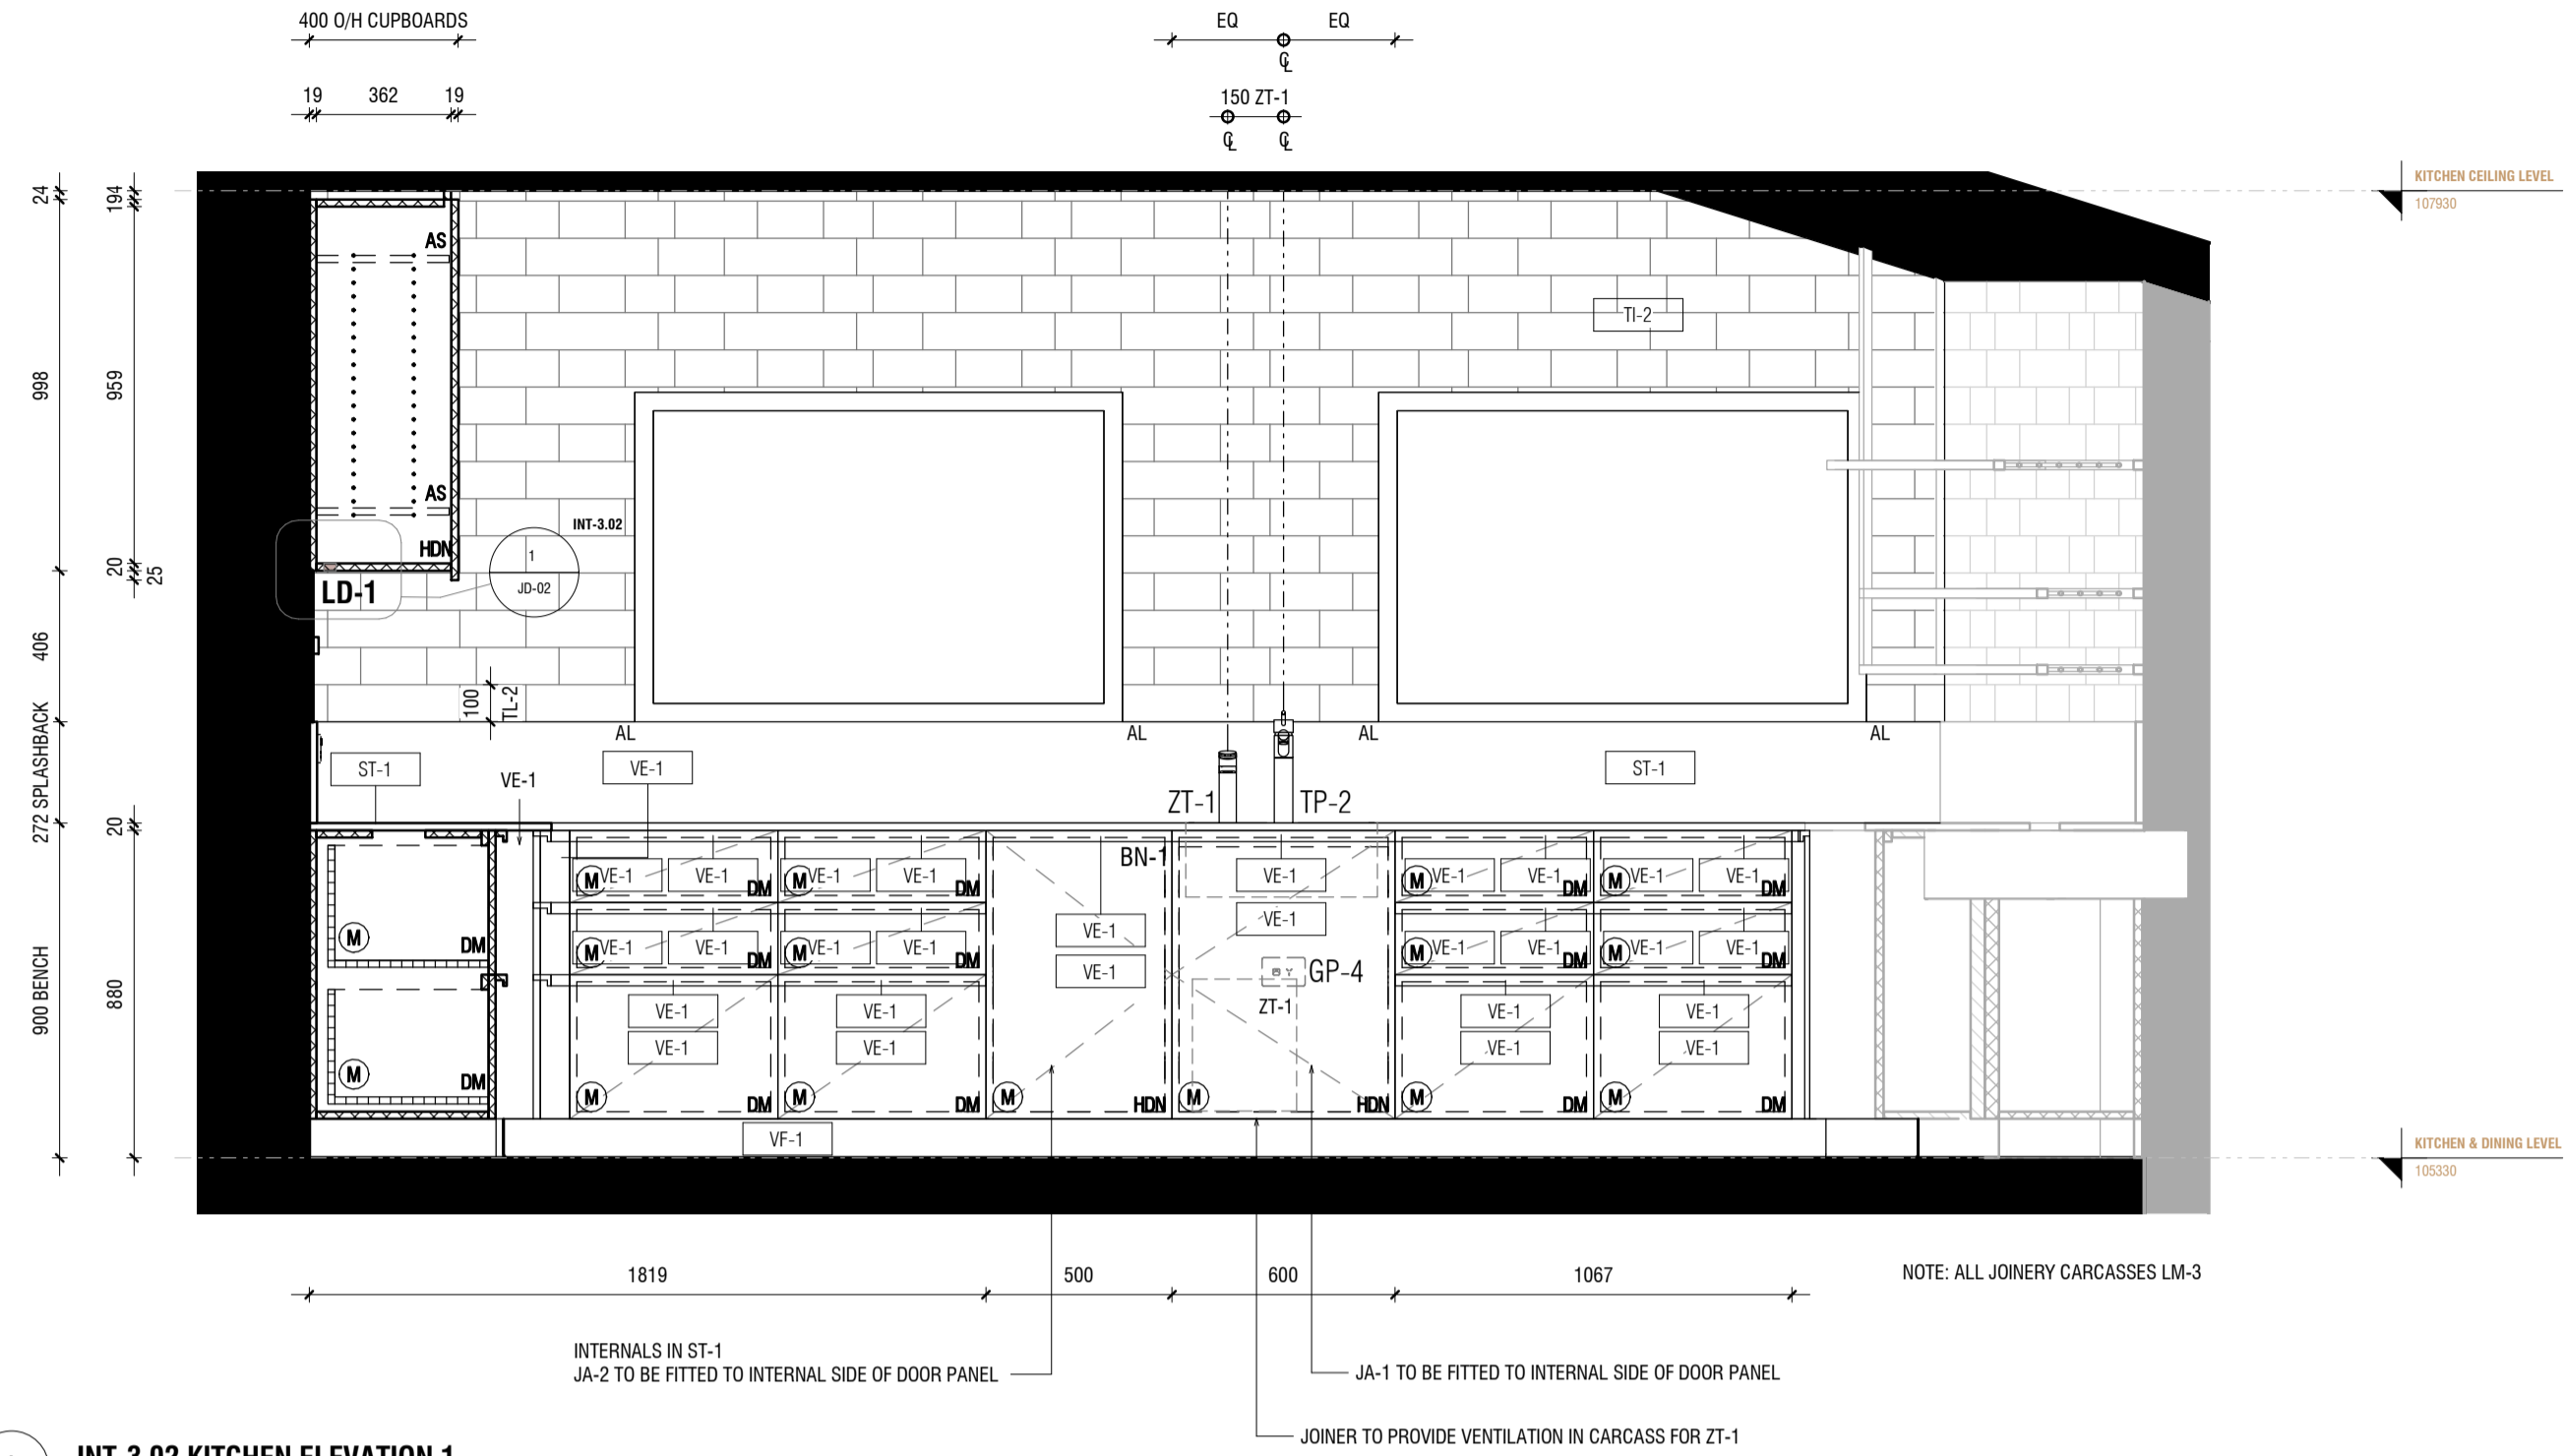

1 INT-3.02 KITCHEN ELEVATION 1
1 : 20

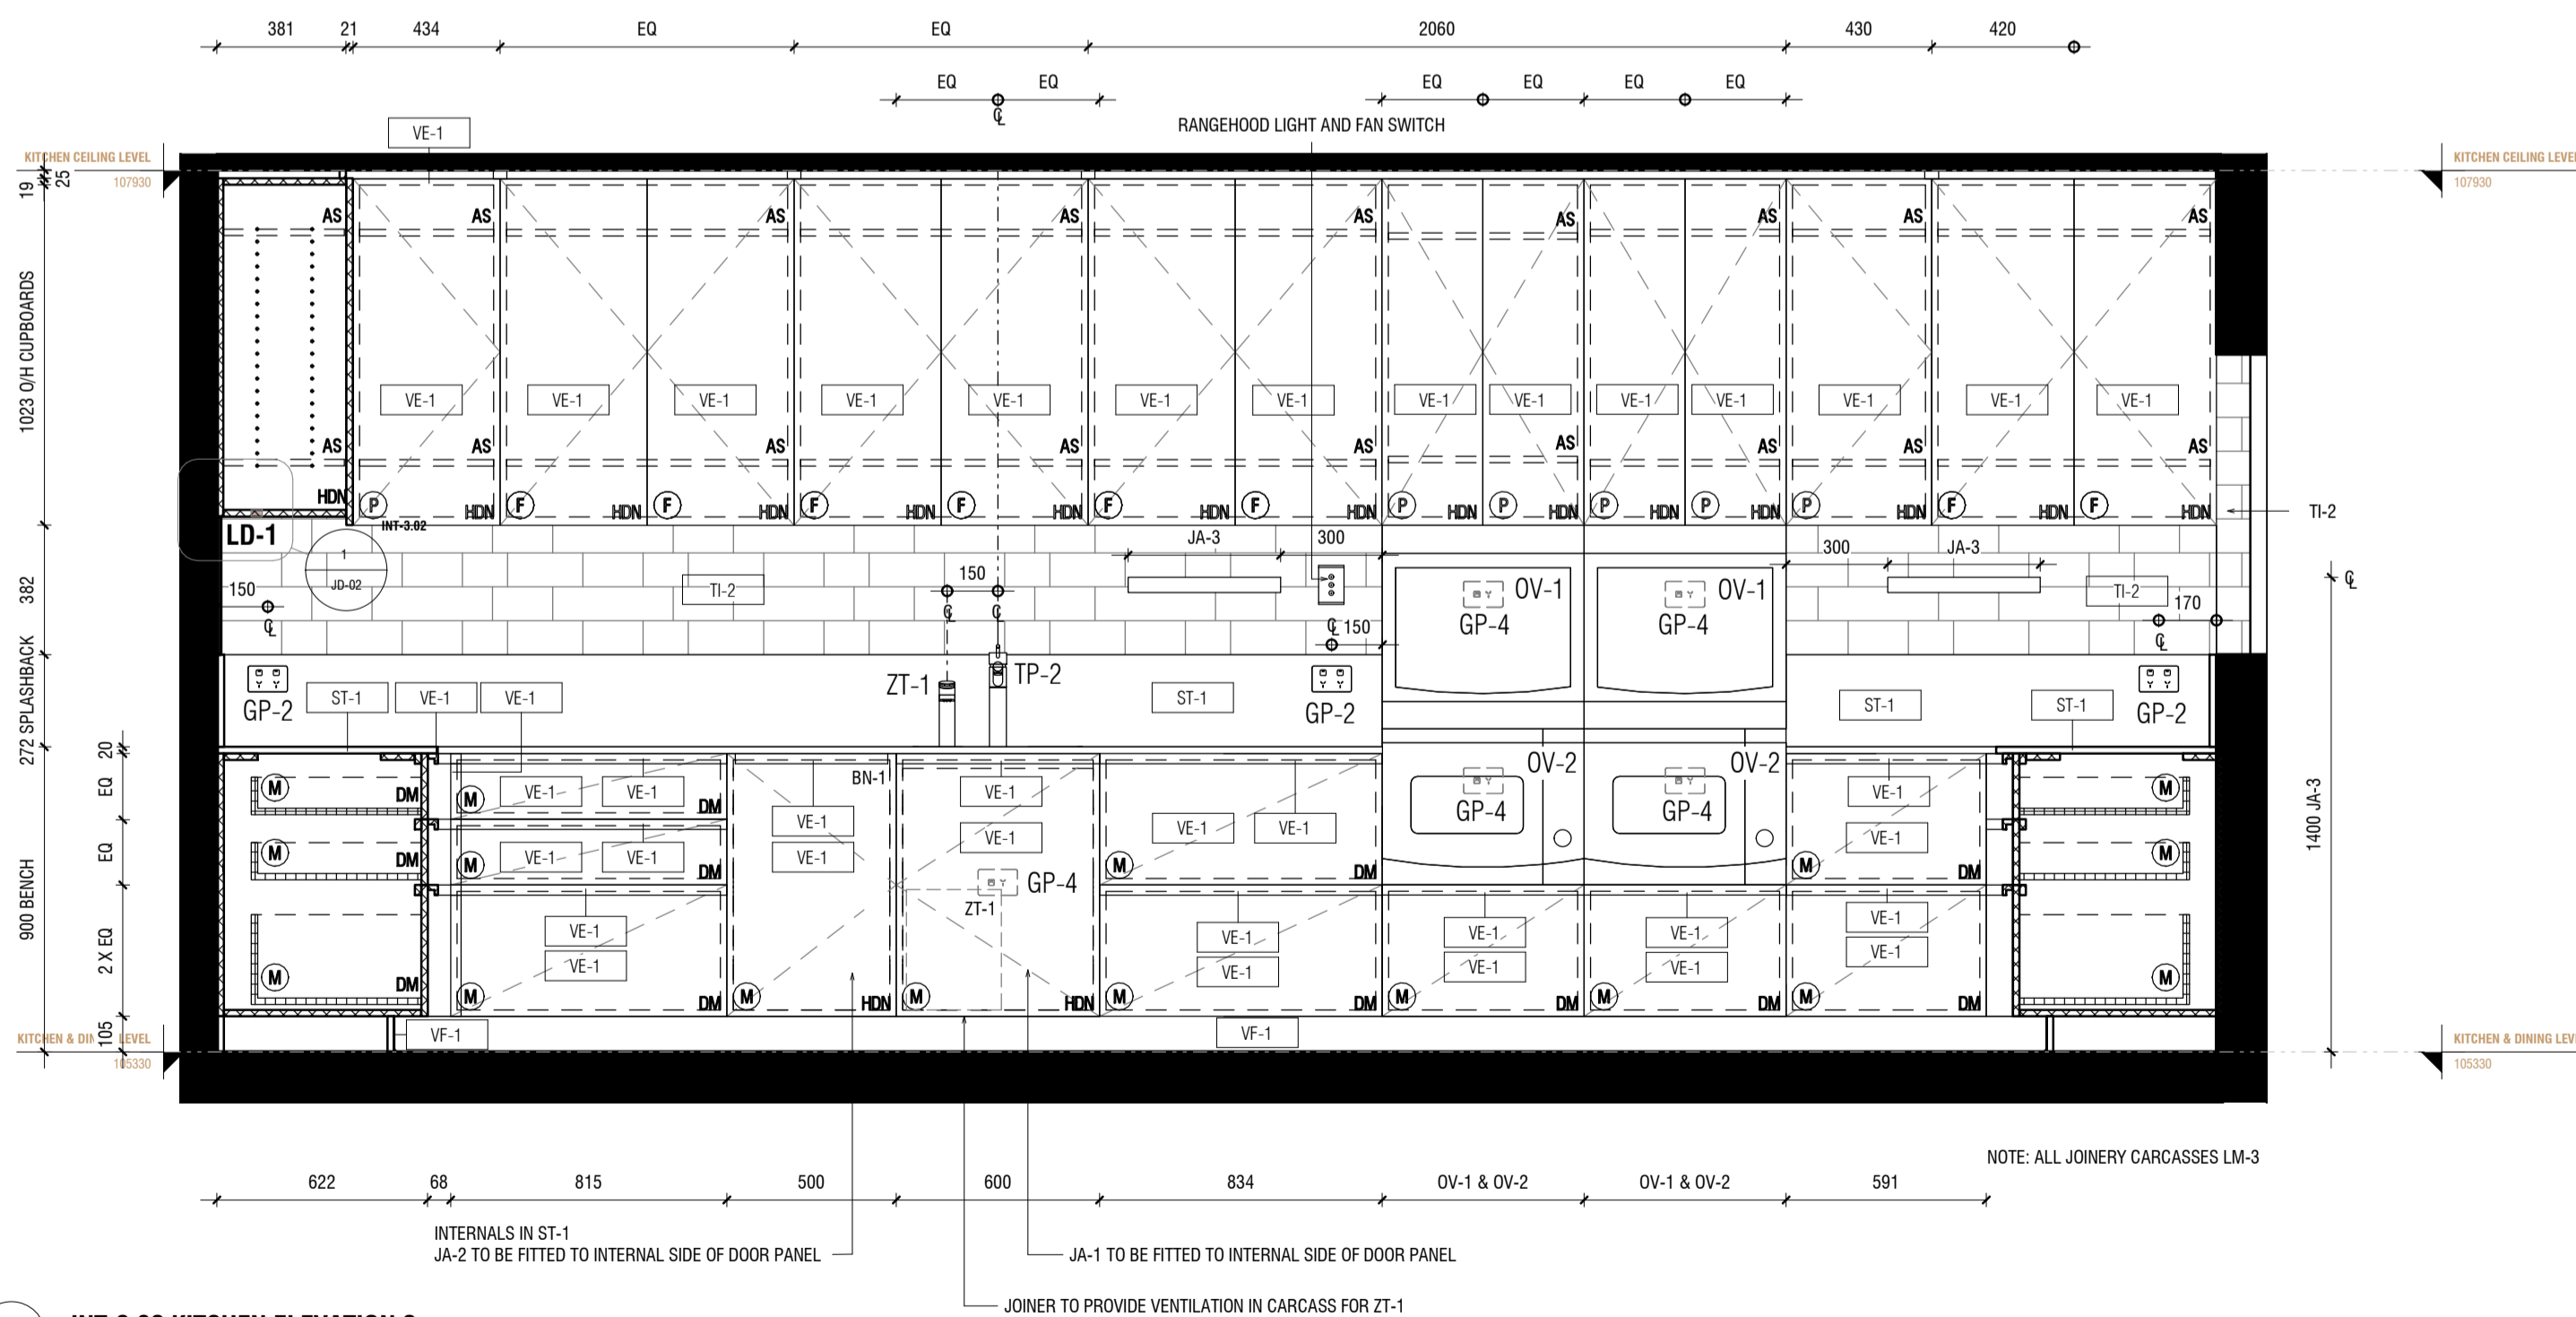


2 INT-3.02 KITCHEN ELEVATION 2
1 : 20

JOINERY

AS	ADJUSTABLE SHELF
AL	ALIGN
BAL	BALANCE
BS	BIFOLD SLIDING
CL	CENTRE LINE
DA	DOOR ACTIVATED
DLFH	BLUM DRAWER LEGRABOX FREE HIGH - 177 MM
DLFL	BLUM DRAWER LEGRABOX FREE LOW - 177 MM
DLPC	BLUM DRAWER LEGRABOX PURE C - 177 MM
DLPF	BLUM DRAWER LEGRABOX PURE F - 241 MM
DLPK	BLUM DRAWER LEGRABOX PURE K - 128.5 MM
DLPM	BLUM DRAWER LEGRABOX PURE M - 90.5 MM
DM	BLUM DRAWER MOVENTO (MELAMINE DRAWER BOX)
EQ	EQUAL
FS	FIXED SHELF
FP	FIXED PANNEL
HDB	HINGE DOOR - BLUM ONYX BLACK HINGES
HDN	HINGE DOOR - BLUM NICKEL PLATED HINGES
HF	HINGE FLAP
HR	HANGING RAIL
IAS	INTERNAL ADJUSTABLE SHELF
IDLFH	BLUM INTERNAL DRAWER LEGRABOX FREE HIGH - 177 MM
IDLFL	BLUM INTERNAL DRAWER LEGRABOX FREE LOW - 177 MM
IDLPC	BLUM INTERNAL DRAWER LEGRABOX PURE C - 177 MM
IDLPF	BLUM INTERNAL DRAWER LEGRABOX PURE F - 241 MM
IDLPK	BLUM INTERNAL DRAWER LEGRABOX PURE K - 128.5 MM
IDLPM	BLUM INTERNAL DRAWER LEGRABOX PURE M - 90.5 MM
IDM	BLUM INTERNAL DRAWER MOVENTO (MELAMINE DRAWER BOX)
IFS	INTERNAL FIXED SHELF
IHDB	INTERNAL HINGE DOOR - BLUM ONYX BLACK HINGES
IHDN	INTERNAL HINGE DOOR - BLUM NICKEL PLATED HINGES
IPAS	INTERNAL PULLOUT ANGLED SHOE SHELF
IPS	INTERNAL PULLOUT SHELF
MJ	MITRE JOIN
PS	PULLOUT SHELF
RD	RETRACTABLE DOOR
SL	SEAM LINE
SP	SLIDING PANNEL
STSM	SUBJECT TO SITE MEASURE
STAS	SUBJECT TO APPLIANCE SPECS

(B)	BI-FOLD OPERATION
(F)	FINGER GRIP OPERATION WITH BLUMOTION
(M)	MANUAL OPERATION WITH BLUMOTION
(P)	PUSH TOUCH OPERATION WITH BLUM TIP ON FOR DOORS
(T)	TIP ON OPERATION WITH BLUMOTION FOR DRAWERS
(S)	SERVO-DRIVE OPERATION - BLUM
(A)	AMBIALINE - BLUM INNER DIVIDER SYSTEM - LEGRABOX
(O)	ORGALINE - BLUM INNER DIVIDER SYSTEM - MOVENTO

SCALE BAR

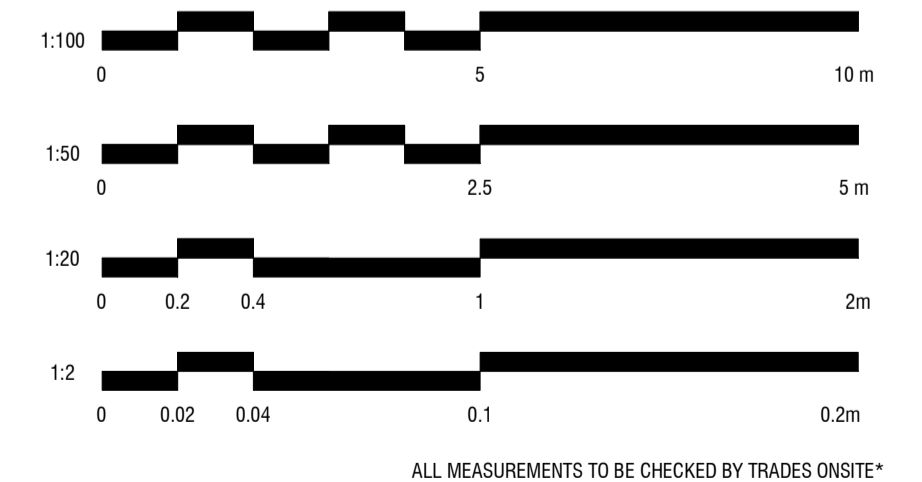

**CHRISTOPHER
ELLIOTT**


CHRISTOPHER ELLIOTT DESIGN PTY LTD
ABN 33131218650 ACN 131218650
T +61 (03)9077 8133 M +61 (0)403 653 649
INFO@CHRISTOPHERELLIOTTDESIGN.COM.AU
PO BOX 124 PRAHRAN 3181 VICTORIA AUSTRALIA

CLIENT AUSTRALIAN ALPINE CLUB
PROJECT ALPINE ROAD, HOTHAM HEIGHTS VIC 3741

All rights reserved. This document remains the property of Christopher Elliott Design Pty Ltd and is only to be used for its commissioned purpose. No part of this document may be reproduced, modified or transmitted in any form or by any means without the explicit written authority of Christopher Elliott Design Pty Ltd. Unauthorised use of this document in any form whatsoever is prohibited.


TITLE KITCHEN
SCALE @ A1 AS INDICATED
CHECKED BY CE
SHEET INT-3.02

PLOT DATE 05.06.20
DRAWN BY CA
REVISION A

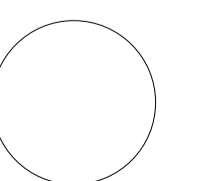


REVISION STATUS

REV.	DESCRIPTION	DATE
A	REVISION #3 CONSTRUCTION DOCS ISSUED	05.06.20

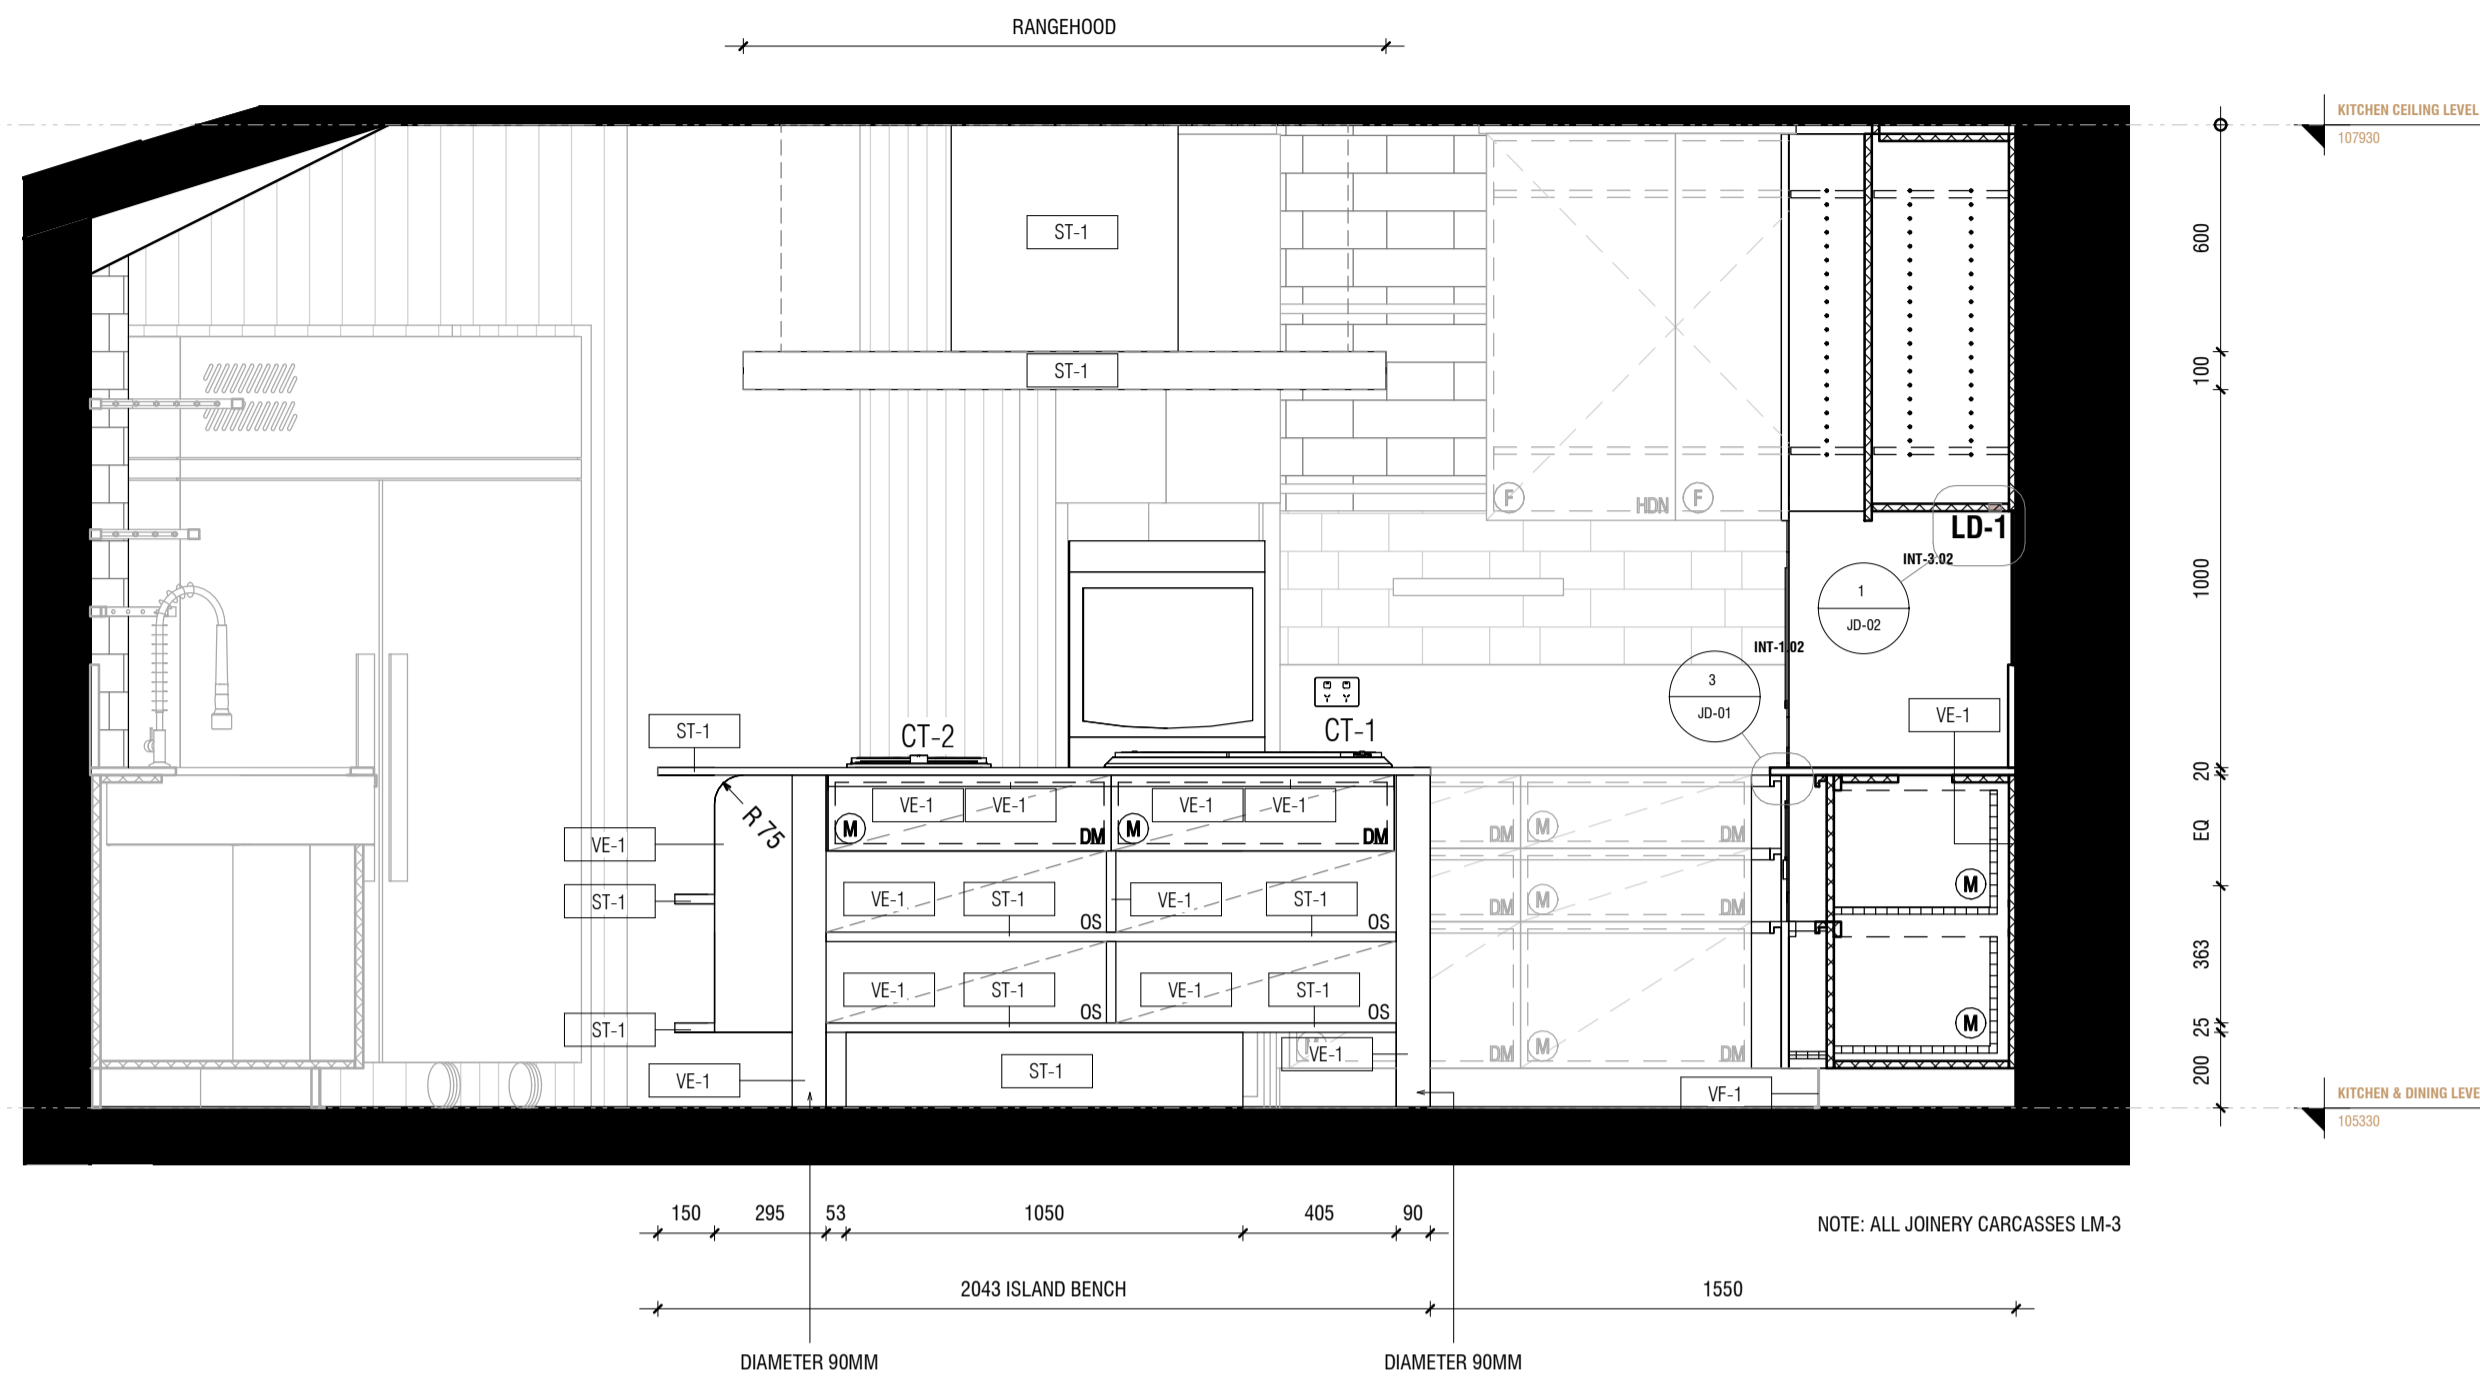

1 INT-3.03 KITCHEN ELEVATION 1
1:20

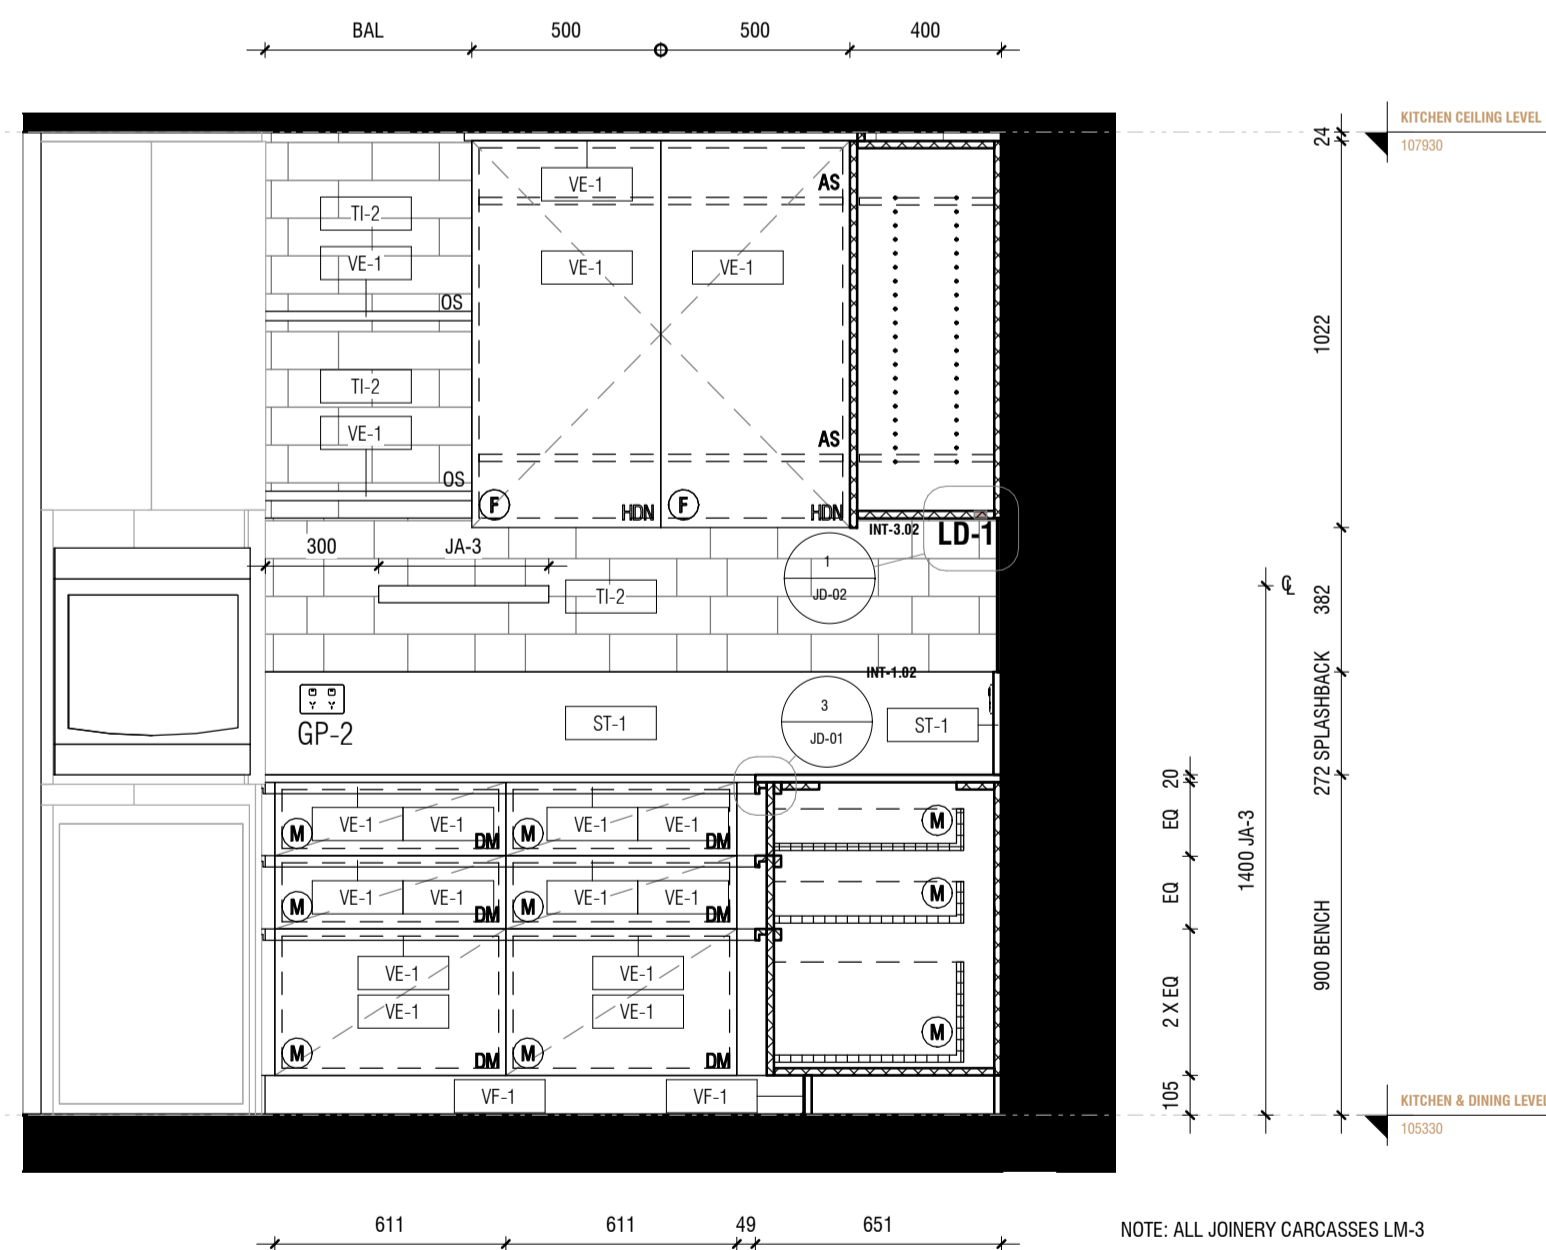


2 INT-3.03 KITCHEN ELEVATION 2
1:20

JOINERY

AS	ADJUSTABLE SHELF
AL	ALIGN
BAL	BALANCE
BS	BIFOLD SLIDING
CL	CENTRE LINE
DA	DOOR ACTIVATED
DLFH	BLUM DRAWER LEGRABOX FREE HIGH - 177 MM
DLFL	BLUM DRAWER LEGRABOX FREE LOW - 177 MM
DLPC	BLUM DRAWER LEGRABOX PURE C - 177 MM
DLPF	BLUM DRAWER LEGRABOX PURE F - 241 MM
DLPK	BLUM DRAWER LEGRABOX PURE K - 128.5 MM
DLPM	BLUM DRAWER LEGRABOX PURE M - 90.5 MM
DM	BLUM DRAWER MOVENTO (MELAMINE DRAWER BOX)
EQ	EQUAL
FS	FIXED SHELF
FP	FIXED PANNEL
HDB	HINGE DOOR - BLUM ONYX BLACK HINGES
HDN	HINGE DOOR - BLUM NICKEL PLATED HINGES
HF	HINGE FLAP
HR	HANGING RAIL
IAS	INTERNAL ADJUSTABLE SHELF
IDLFH	BLUM INTERNAL DRAWER LEGRABOX FREE HIGH - 177 MM
IDLFL	BLUM INTERNAL DRAWER LEGRABOX FREE LOW - 177 MM
IDLPC	BLUM INTERNAL DRAWER LEGRABOX PURE C - 177 MM
IDLPF	BLUM INTERNAL DRAWER LEGRABOX PURE F - 241 MM
IDLPK	BLUM INTERNAL DRAWER LEGRABOX PURE K - 128.5 MM
IDLPM	BLUM INTERNAL DRAWER LEGRABOX PURE M - 90.5 MM
IDM	BLUM INTERNAL DRAWER MOVENTO (MELAMINE DRAWER BOX)
IFS	INTERNAL FIXED SHELF
IHDB	INTERNAL HINGE DOOR - BLUM ONYX BLACK HINGES
IHDN	INTERNAL HINGE DOOR - BLUM NICKEL PLATED HINGES
IPAS	INTERNAL PULLOUT ANGLED SHOE SHELF
IPS	INTERNAL PULLOUT SHELF
IJ	MITRE JOIN
PS	PULLOUT SHELF
RD	RETRACTABLE DOOR
SL	SEAM LINE
SP	SLIDING PANEL
STSM	SUBJECT TO SITE MEASURE
STAS	SUBJECT TO APPLIANCE SPECS
Ⓟ	BI-FOLD OPERATION
Ⓡ	FINGER GRIP OPERATION WITH BLUMOTION
Ⓜ	MANUAL OPERATION WITH BLUMOTION
Ⓟ	PUSH TOUCH OPERATION WITH BLUM TIP ON FOR DOORS
Ⓡ	TIP ON OPERATION WITH BLUMOTION FOR DRAWERS
Ⓢ	SERVO-DRIVE OPERATION - BLUM
Ⓜ	AMBIALINE - BLUM INNER DIVIDER SYSTEM - LEGRABOX
Ⓜ	ORGALINE - BLUM INNER DIVIDER SYSTEM - MOVENTO

SCALE BAR

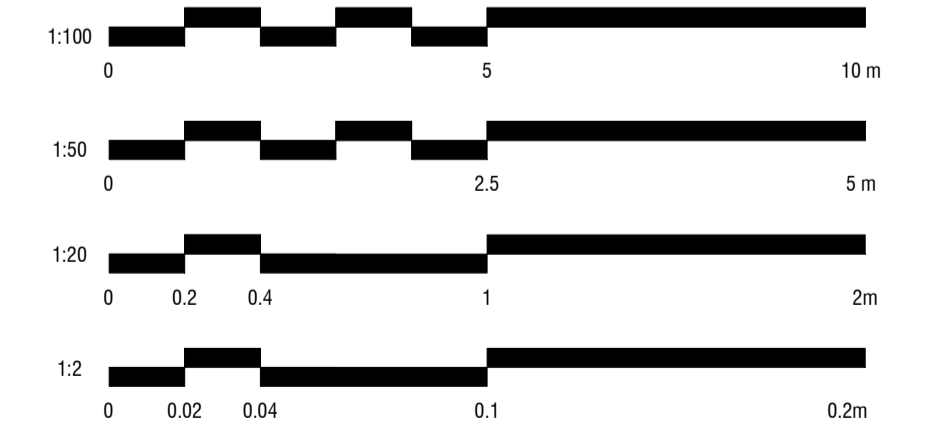

ALL MEASUREMENTS TO BE CHECKED BY TRADES ONSITE*

CHRISTOPHER
ELLIOTT


CHRISTOPHER ELLIOTT DESIGN PTY LTD
ABN 33131218650 ACN 131218650
T+61 (03)9077 8133 M +61 (0)403 653 649
INFO@CHRISTOPHERELLIOTTDESIGN.COM.AU
PO BOX 124 PRAHRAN 3181 VICTORIA AUSTRALIA

CLIENT AUSTRALIAN ALPINE CLUB
PROJECT ALPINE ROAD, HOTHAM HEIGHTS VIC 3741

All rights reserved. This document remains the property of Christopher Elliott Design Pty Ltd and is only to be used for its commissioned purpose. No part of this document may be reproduced, modified or transmitted in any form or by any means without the explicit written authority of Christopher Elliott Design Pty Ltd. Unauthorised use of this document in any form whatsoever is prohibited.


TITLE KITCHEN
SCALE @ A1 AS INDICATED
CHECKED BY CE
SHEET INT-3.03

PLOT DATE 05.06.20
DRAWN BY CA
REVISION A

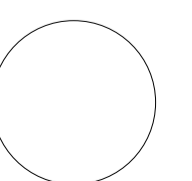

REVISION STATUS


REV.	DESCRIPTION	DATE
A	REVISION #3 CONSTRUCTION DOCS ISSUED	05.06.20

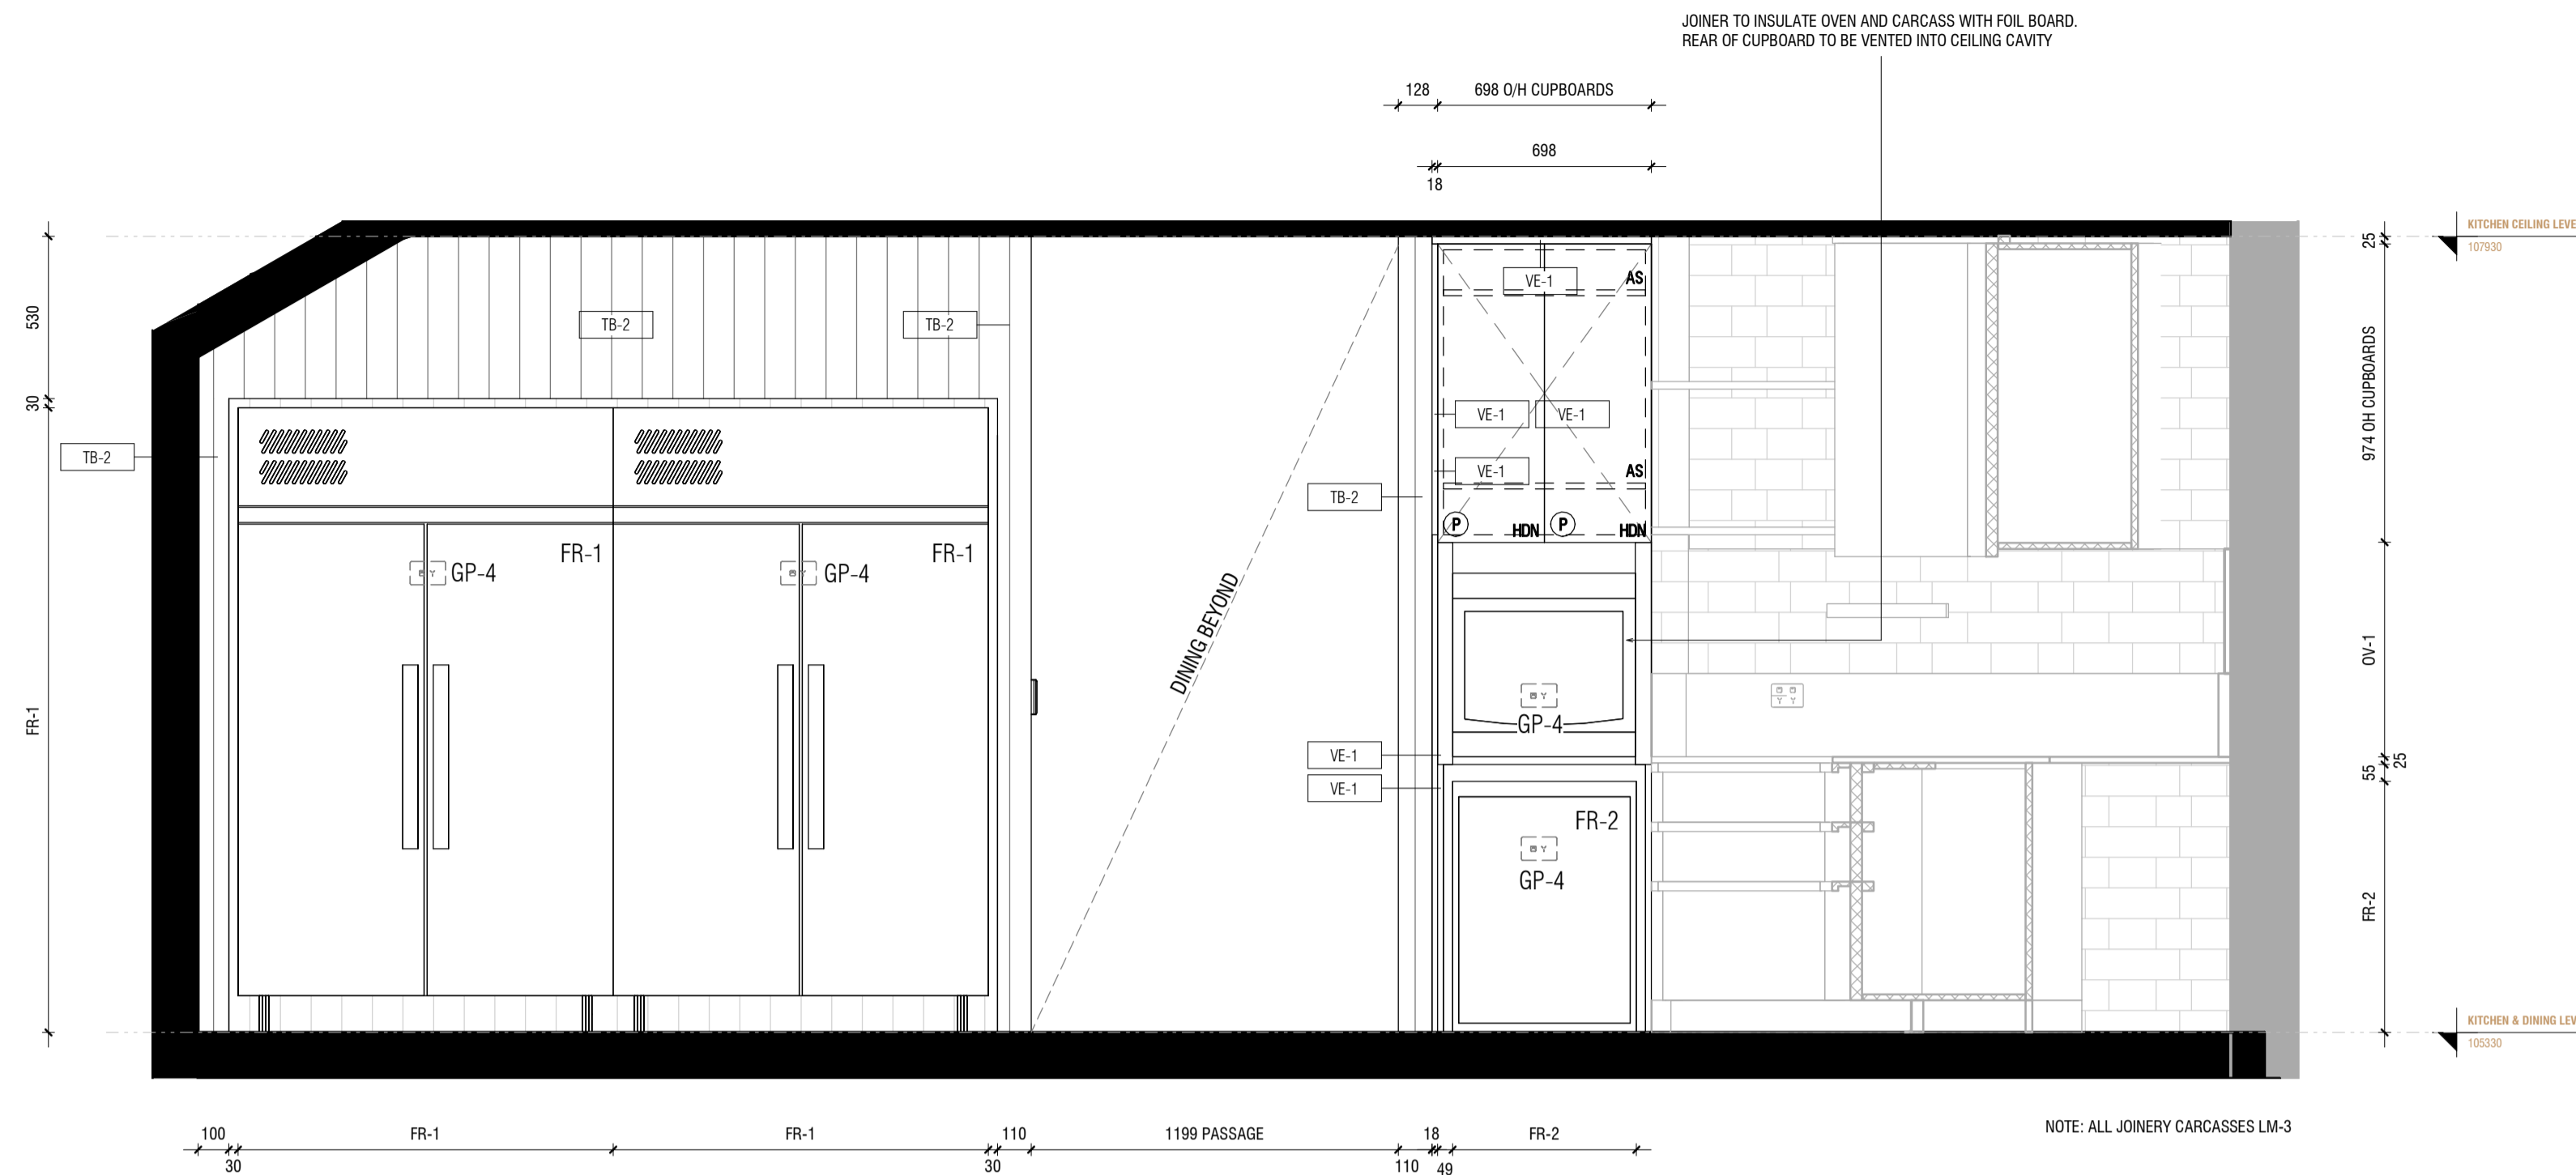

1 INT-3.04 KITCHEN ELEVATION 1
1:20

JOINERY


AS	ADJUSTABLE SHELF
AL	ALIGN
BAL	BALANCE
BS	BIFOLD SLIDING
CL	CENTRE LINE
DA	DOOR ACTIVATED
DLFH	BLUM DRAWER LEGRABOX FREE HIGH - 177 MM
DLFL	BLUM DRAWER LEGRABOX FREE LOW - 177 MM
DLPC	BLUM DRAWER LEGRABOX PURE C - 177 MM
DLPF	BLUM DRAWER LEGRABOX PURE F - 241 MM
DLPK	BLUM DRAWER LEGRABOX PURE K - 128.5 MM
DLPM	BLUM DRAWER LEGRABOX PURE M - 90.5 MM
DM	BLUM DRAWER MOVENTO (MELAMINE DRAWER BOX)
EQ	EQUAL
FS	FIXED SHELF
FP	FIXED PANNEL
HDB	HINGE DOOR - BLUM ONYX BLACK HINGES
HDN	HINGE DOOR - BLUM NICKEL PLATED HINGES
HF	HINGE FLAP
HR	HANGING RAIL
IAS	INTERNAL ADJUSTABLE SHELF
IDLFH	BLUM INTERNAL DRAWER LEGRABOX FREE HIGH - 177 MM
IDLFL	BLUM INTERNAL DRAWER LEGRABOX FREE LOW - 177 MM
IDLPC	BLUM INTERNAL DRAWER LEGRABOX PURE C - 177 MM
IDLPF	BLUM INTERNAL DRAWER LEGRABOX PURE F - 241 MM
IDLPK	BLUM INTERNAL DRAWER LEGRABOX PURE K - 128.5 MM
IDLPM	BLUM INTERNAL DRAWER LEGRABOX PURE M - 90.5 MM
IDM	BLUM INTERNAL DRAWER MOVENTO (MELAMINE DRAWER BOX)
IFS	INTERNAL FIXED SHELF
IHDB	INTERNAL HINGE DOOR - BLUM ONYX BLACK HINGES
IHDN	INTERNAL HINGE DOOR - BLUM NICKEL PLATED HINGES
IPAS	INTERNAL PULLOUT ANGLED SHOE SHELF
IPS	INTERNAL PULLOUT SHELF
IJ	MITRE JOIN
PS	PULLOUT SHELF
RD	RETRACTABLE DOOR
SL	SEAM LINE
SP	SLIDING PANEL
STSM	SUBJECT TO SITE MEASURE
STAS	SUBJECT TO APPLIANCE SPECS

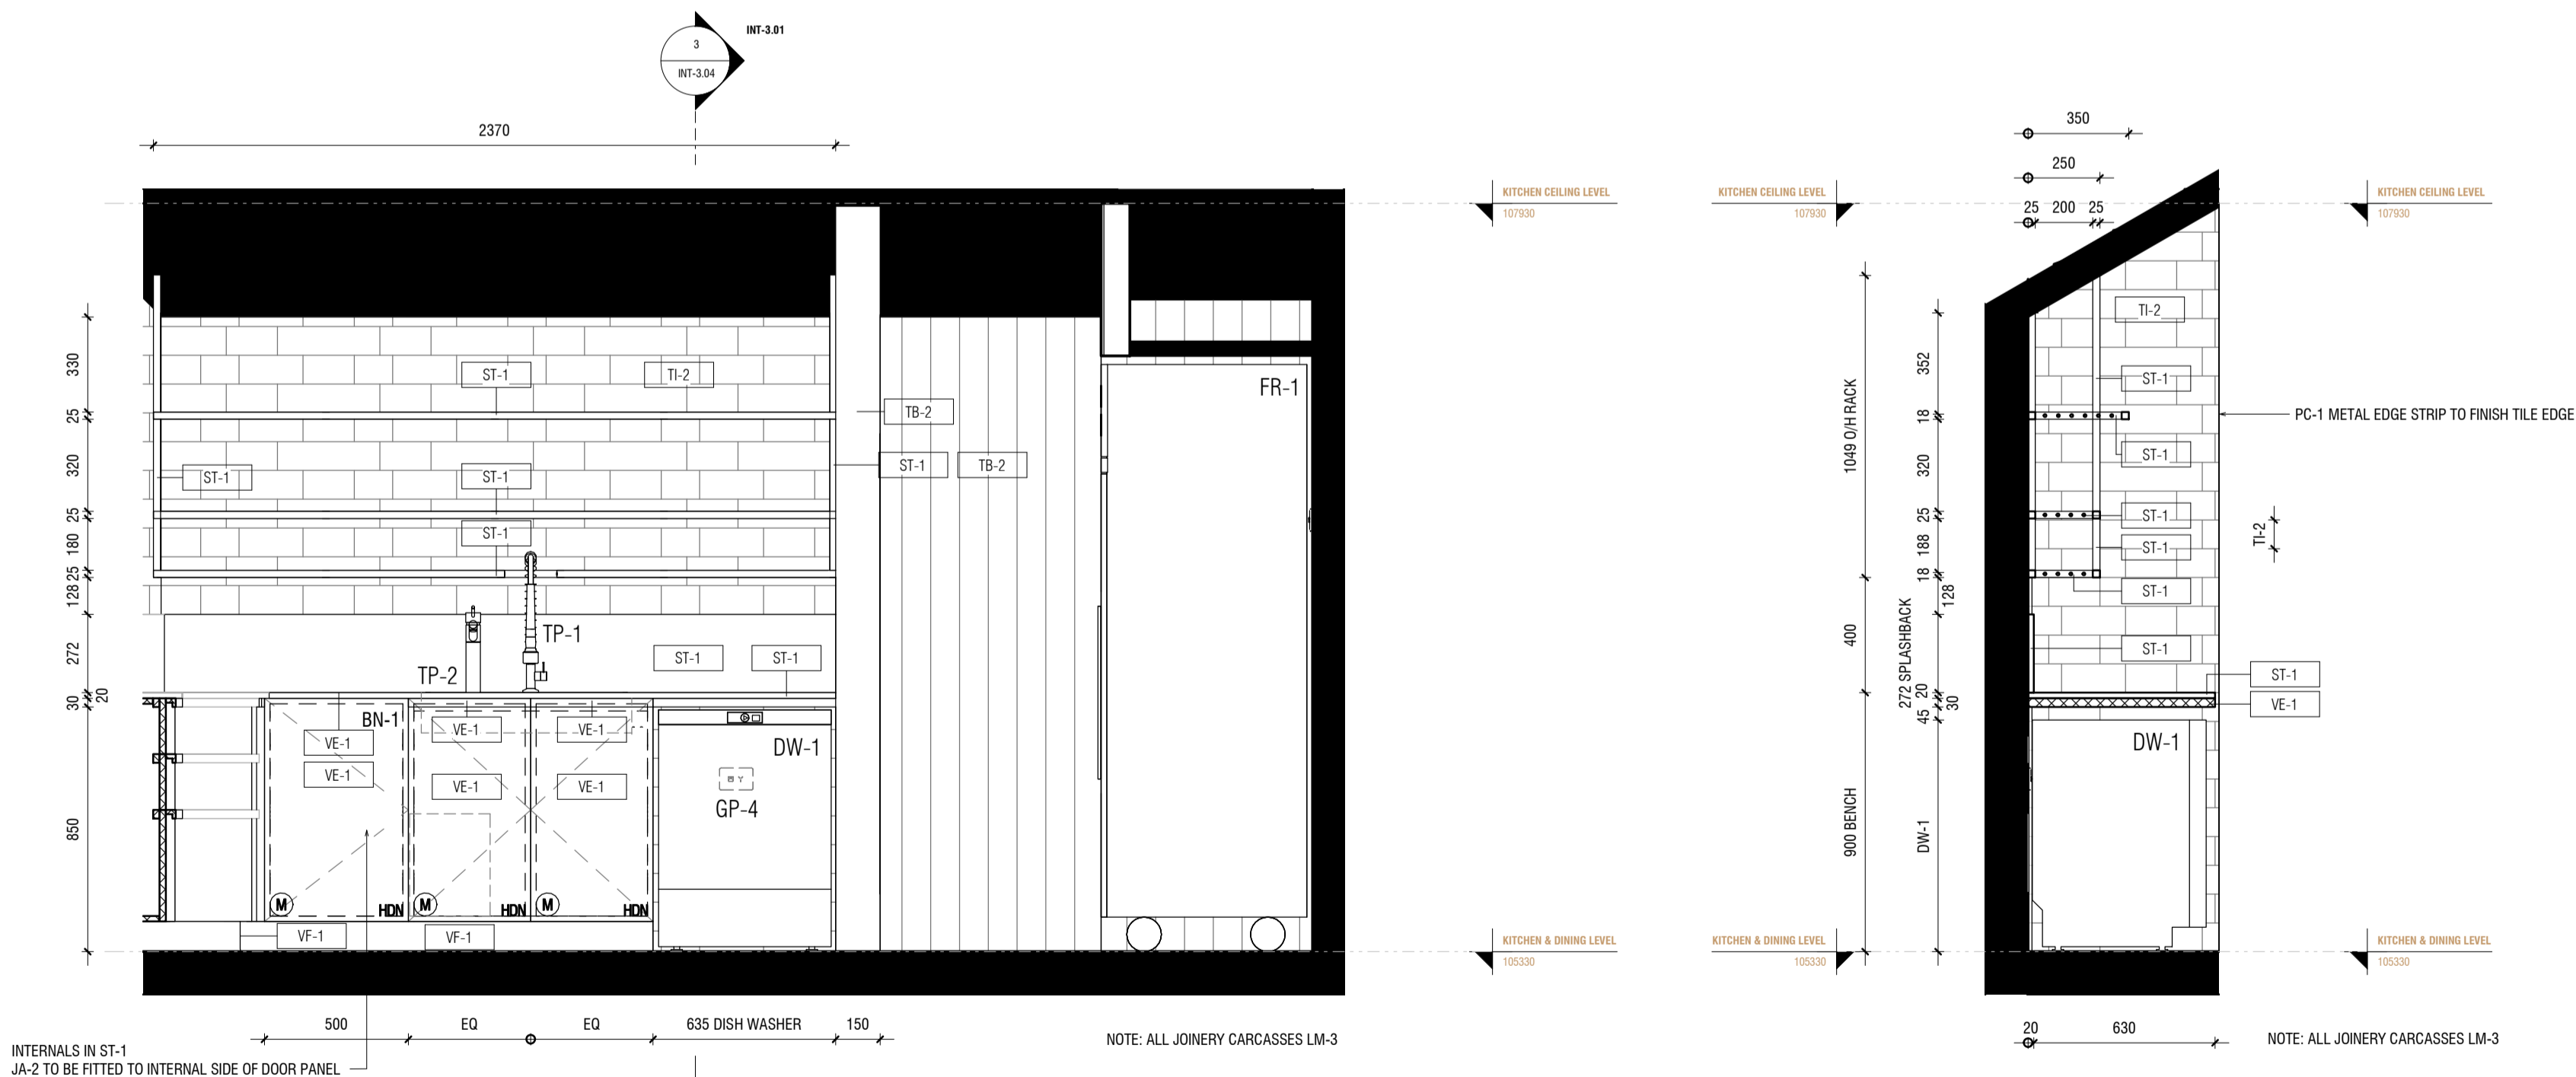

2 INT-3.04 KITCHEN ELEVATION 2
1:20

3 INT-3.04 SECTION 1
1:20

SCALE BAR

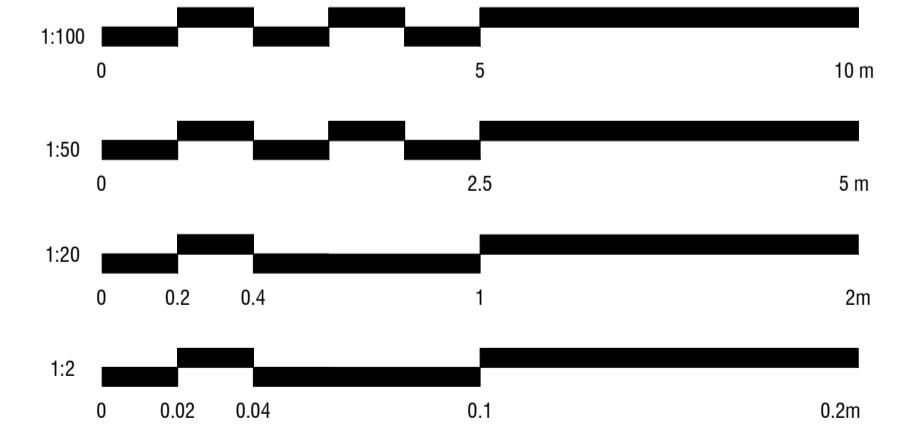

ALL MEASUREMENTS TO BE CHECKED BY TRADES ONSITE*

CHRISTOPHER
ELLIOTT


CHRISTOPHER ELLIOTT DESIGN PTY LTD
ABN 33131218650 ACN 131218650
T+61 (03)9077 8133 M +61 (0)403 653 649
INFO@CHRISTOPHERELLIOTTDESIGN.COM.AU
PO BOX 124 PRAHRAN 3181 VICTORIA AUSTRALIA

CLIENT AUSTRALIAN ALPINE CLUB
PROJECT ALPINE ROAD, HOTHAM HEIGHTS VIC 3741

All rights reserved. This document remains the property of Christopher Elliott Design Pty Ltd and is only to be used for its commissioned purpose. No part of this document may be reproduced, modified or transmitted in any form or by any means without the explicit written authority of Christopher Elliott Design Pty Ltd. Unauthorised use of this document in any form whatsoever is prohibited.

TITLE KITCHEN
SCALE @ A1 AS INDICATED
CHECKED BY CE
SHEET INT-3.04


PLOT DATE 05.06.20
DRAWN BY CA
REVISION A

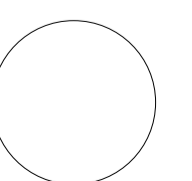


CONSTRUCTION ISSUE

REVISION STATUS


REV.	DESCRIPTION	DATE
A	REVISION #3 CONSTRUCTION DOCS ISSUED	05.06.20

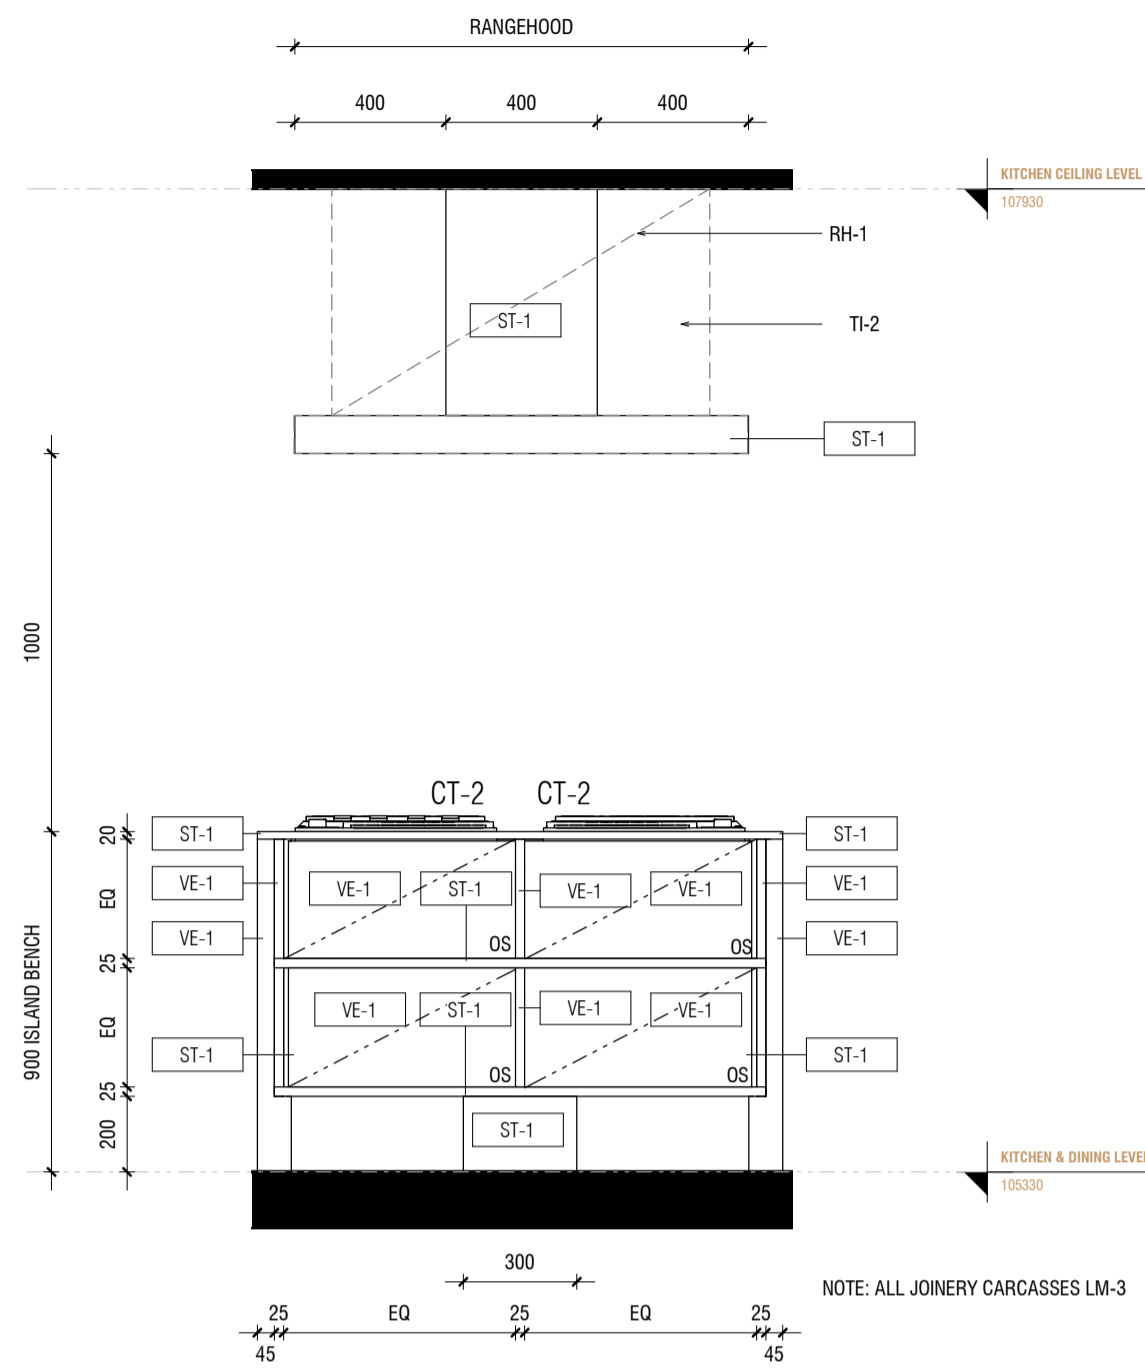

1 INT-3.05 ELEVATION 1
1 : 20

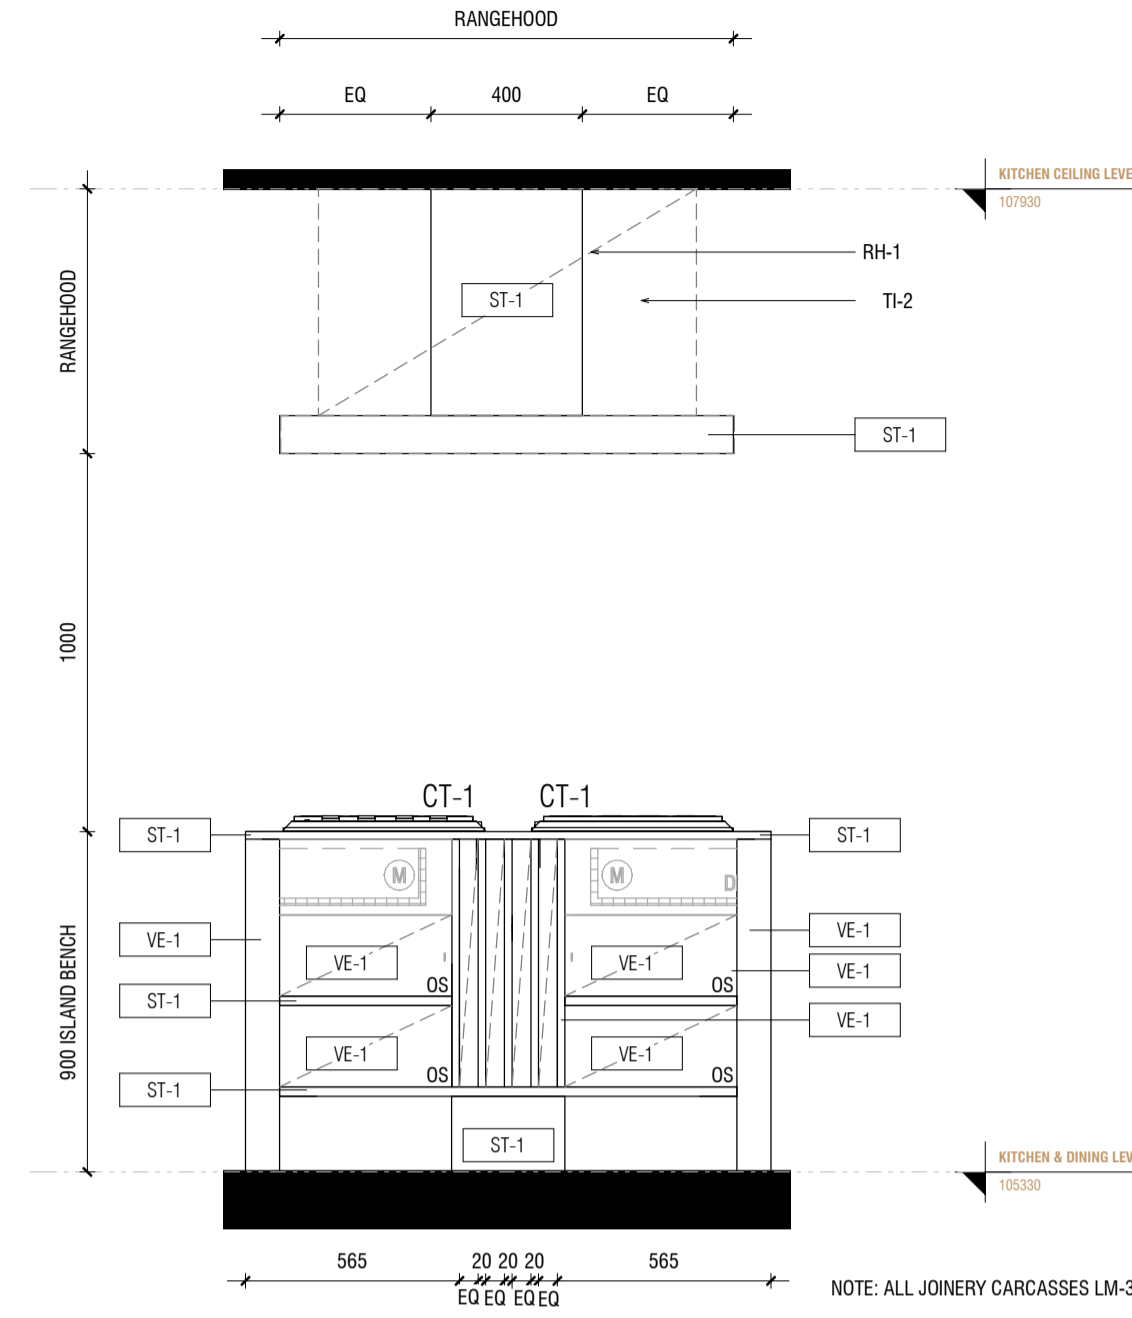

3 INT-3.05 ELEVATION 3
1 : 20

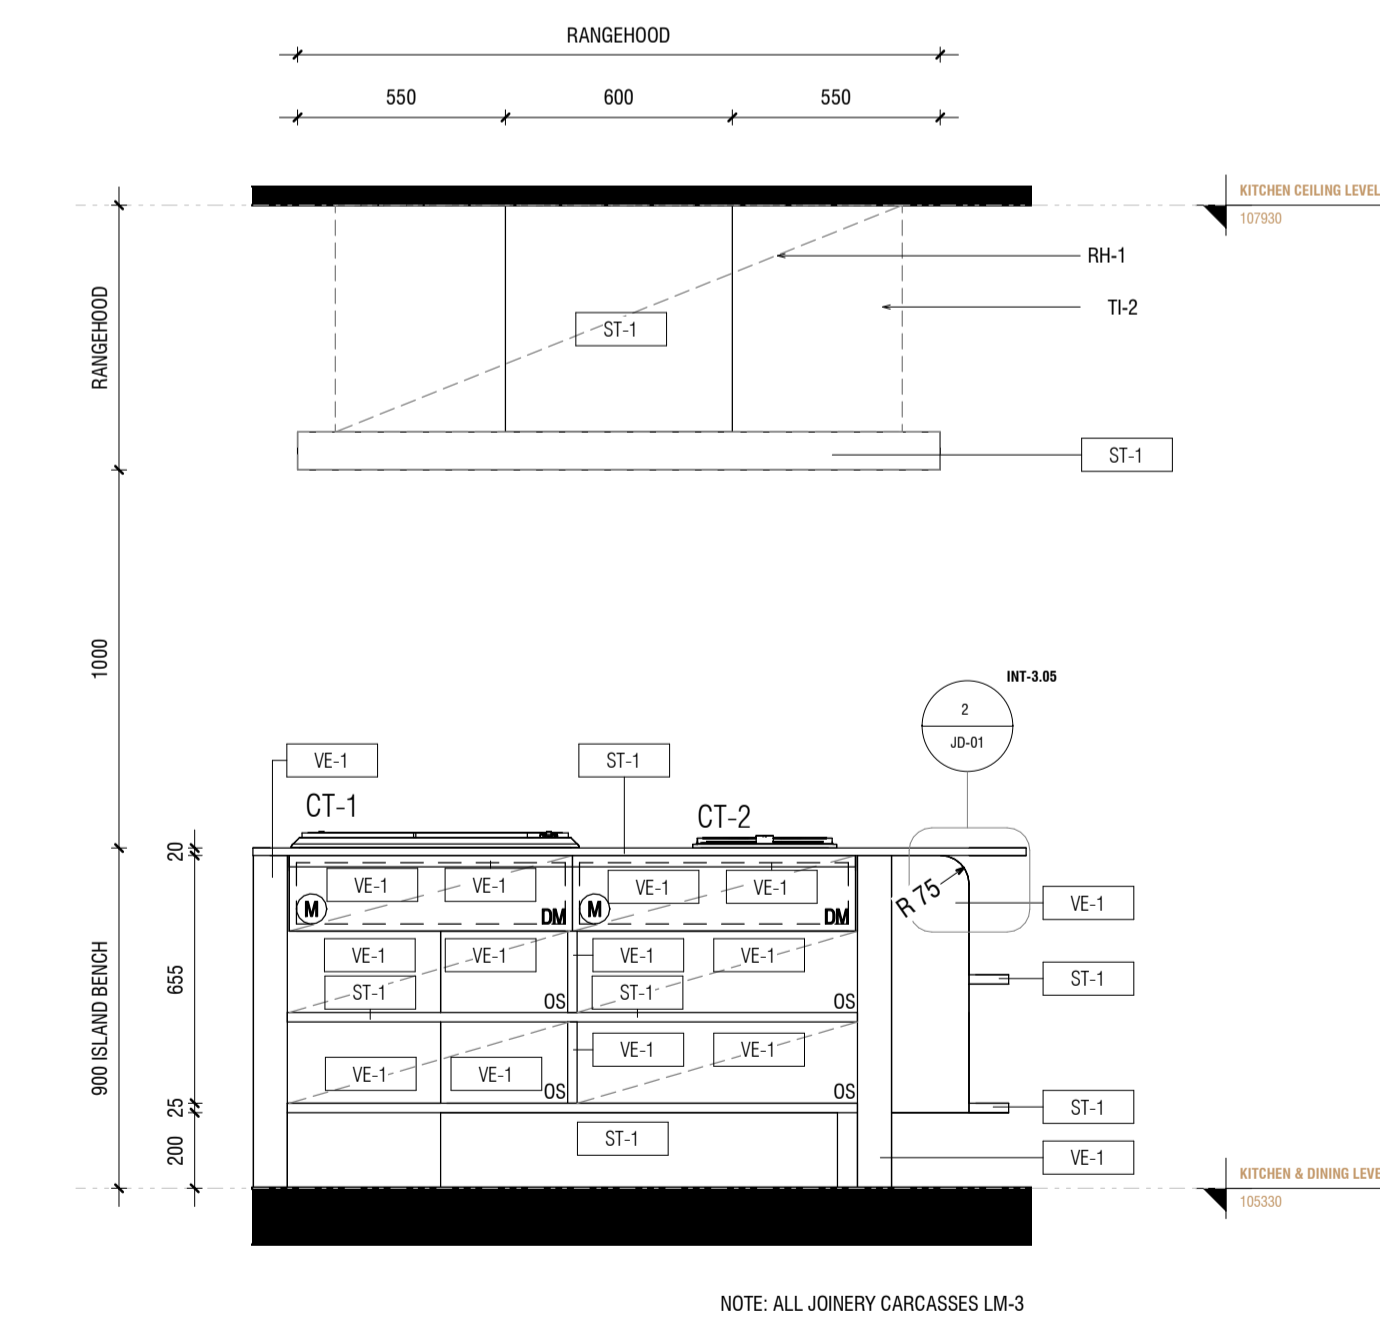


2 INT-3.05 ELEVATION 2
1 : 20

JOINERY

AS	ADJUSTABLE SHELF
AL	ALIGN
BAL	BALANCE
BS	BIFOLD SLIDING
CL	CENTRE LINE
DA	DOOR ACTIVATED
DLFH	BLUM DRAWER LEGRABOX FREE HIGH - 177 MM
DLFL	BLUM DRAWER LEGRABOX FREE LOW - 177 MM
DLPC	BLUM DRAWER LEGRABOX PURE C - 177 MM
DLPF	BLUM DRAWER LEGRABOX PURE F - 241 MM
DLPK	BLUM DRAWER LEGRABOX PURE K - 128.5 MM
DLPM	BLUM DRAWER LEGRABOX PURE M - 90.5 MM
DM	BLUM DRAWER MOVENTO (MELAMINE DRAWER BOX)
EQ	EQUAL
FS	FIXED SHELF
FP	FIXED PANNEL
HDB	HINGE DOOR - BLUM ONYX BLACK HINGES
HDN	HINGE DOOR - BLUM NICKEL PLATED HINGES
HF	HINGE FLAP
HR	HANGING RAIL
IAS	INTERNAL ADJUSTABLE SHELF
IDLFH	BLUM INTERNAL DRAWER LEGRABOX FREE HIGH - 177 MM
IDLFL	BLUM INTERNAL DRAWER LEGRABOX FREE LOW - 177 MM
IDLPC	BLUM INTERNAL DRAWER LEGRABOX PURE C - 177 MM
IDLPF	BLUM INTERNAL DRAWER LEGRABOX PURE F - 241 MM
IDLPK	BLUM INTERNAL DRAWER LEGRABOX PURE K - 128.5 MM
IDLPM	BLUM INTERNAL DRAWER LEGRABOX PURE M - 90.5 MM
IDM	BLUM INTERNAL DRAWER MOVENTO (MELAMINE DRAWER BOX)
IFS	INTERNAL FIXED SHELF
IHDB	INTERNAL HINGE DOOR - BLUM ONYX BLACK HINGES
IHDN	INTERNAL HINGE DOOR - BLUM NICKEL PLATED HINGES
IPAS	INTERNAL PULLOUT ANGLED SHOE SHELF
IPS	INTERNAL PULLOUT SHELF
IJ	MITRE JOIN
PS	PULLOUT SHELF
RD	RETRACTABLE DOOR
SL	SEAM LINE
SP	SLIDING PANEL
STSM	SUBJECT TO SITE MEASURE
STAS	SUBJECT TO APPLIANCE SPECS
Ⓟ	BI-FOLD OPERATION
Ⓡ	FINGER GRIP OPERATION WITH BLUMOTION
Ⓜ	MANUAL OPERATION WITH BLUMOTION
Ⓟ	PUSH TOUCH OPERATION WITH BLUM TIP ON FOR DOORS
Ⓡ	TIP ON OPERATION WITH BLUMOTION FOR DRAWERS
Ⓢ	SERVO-DRIVE OPERATION - BLUM
Ⓜ	AMBIALINE - BLUM INNER DIVIDER SYSTEM - LEGRABOX
Ⓜ	ORGALINE - BLUM INNER DIVIDER SYSTEM - MOVENTO

SCALE BAR

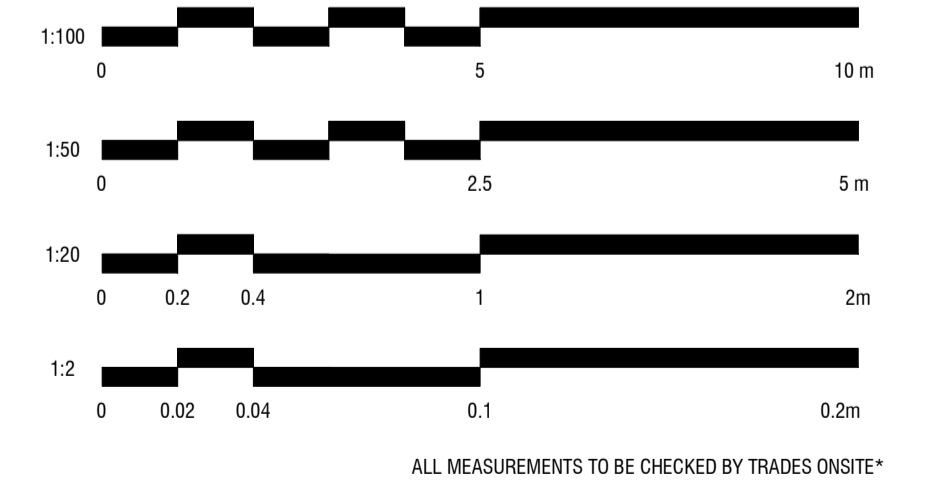

CHRISTOPHER
ELLIOTT


CHRISTOPHER ELLIOTT DESIGN PTY LTD
ABN 33131218650 ACN 131218650
T+61 (03)9077 8133 M +61 (0)403 653 649
INFO@CHRISTOPHERELLIOTTDESIGN.COM.AU
PO BOX 124 PRAHRAN 3181 VICTORIA AUSTRALIA

CLIENT AUSTRALIAN ALPINE CLUB
PROJECT ALPINE ROAD, HOTHAM HEIGHTS VIC 3741

All rights reserved. This document remains the property of Christopher Elliott Design Pty Ltd and is only to be used for its commissioned purpose. No part of this document may be reproduced, modified or transmitted in any form or by any means without the explicit written authority of Christopher Elliott Design Pty Ltd. Unauthorised use of this document in any form whatsoever is prohibited.


TITLE KITCHEN
SCALE @ A1 AS INDICATED
CHECKED BY CE
SHEET INT-3.05

PLOT DATE 05.06.20
DRAWN BY CA
REVISION A

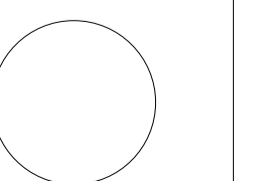

REVISION STATUS


REV.	DESCRIPTION	DATE
A	REVISION #3 CONSTRUCTION DOCS ISSUED	05.06.20

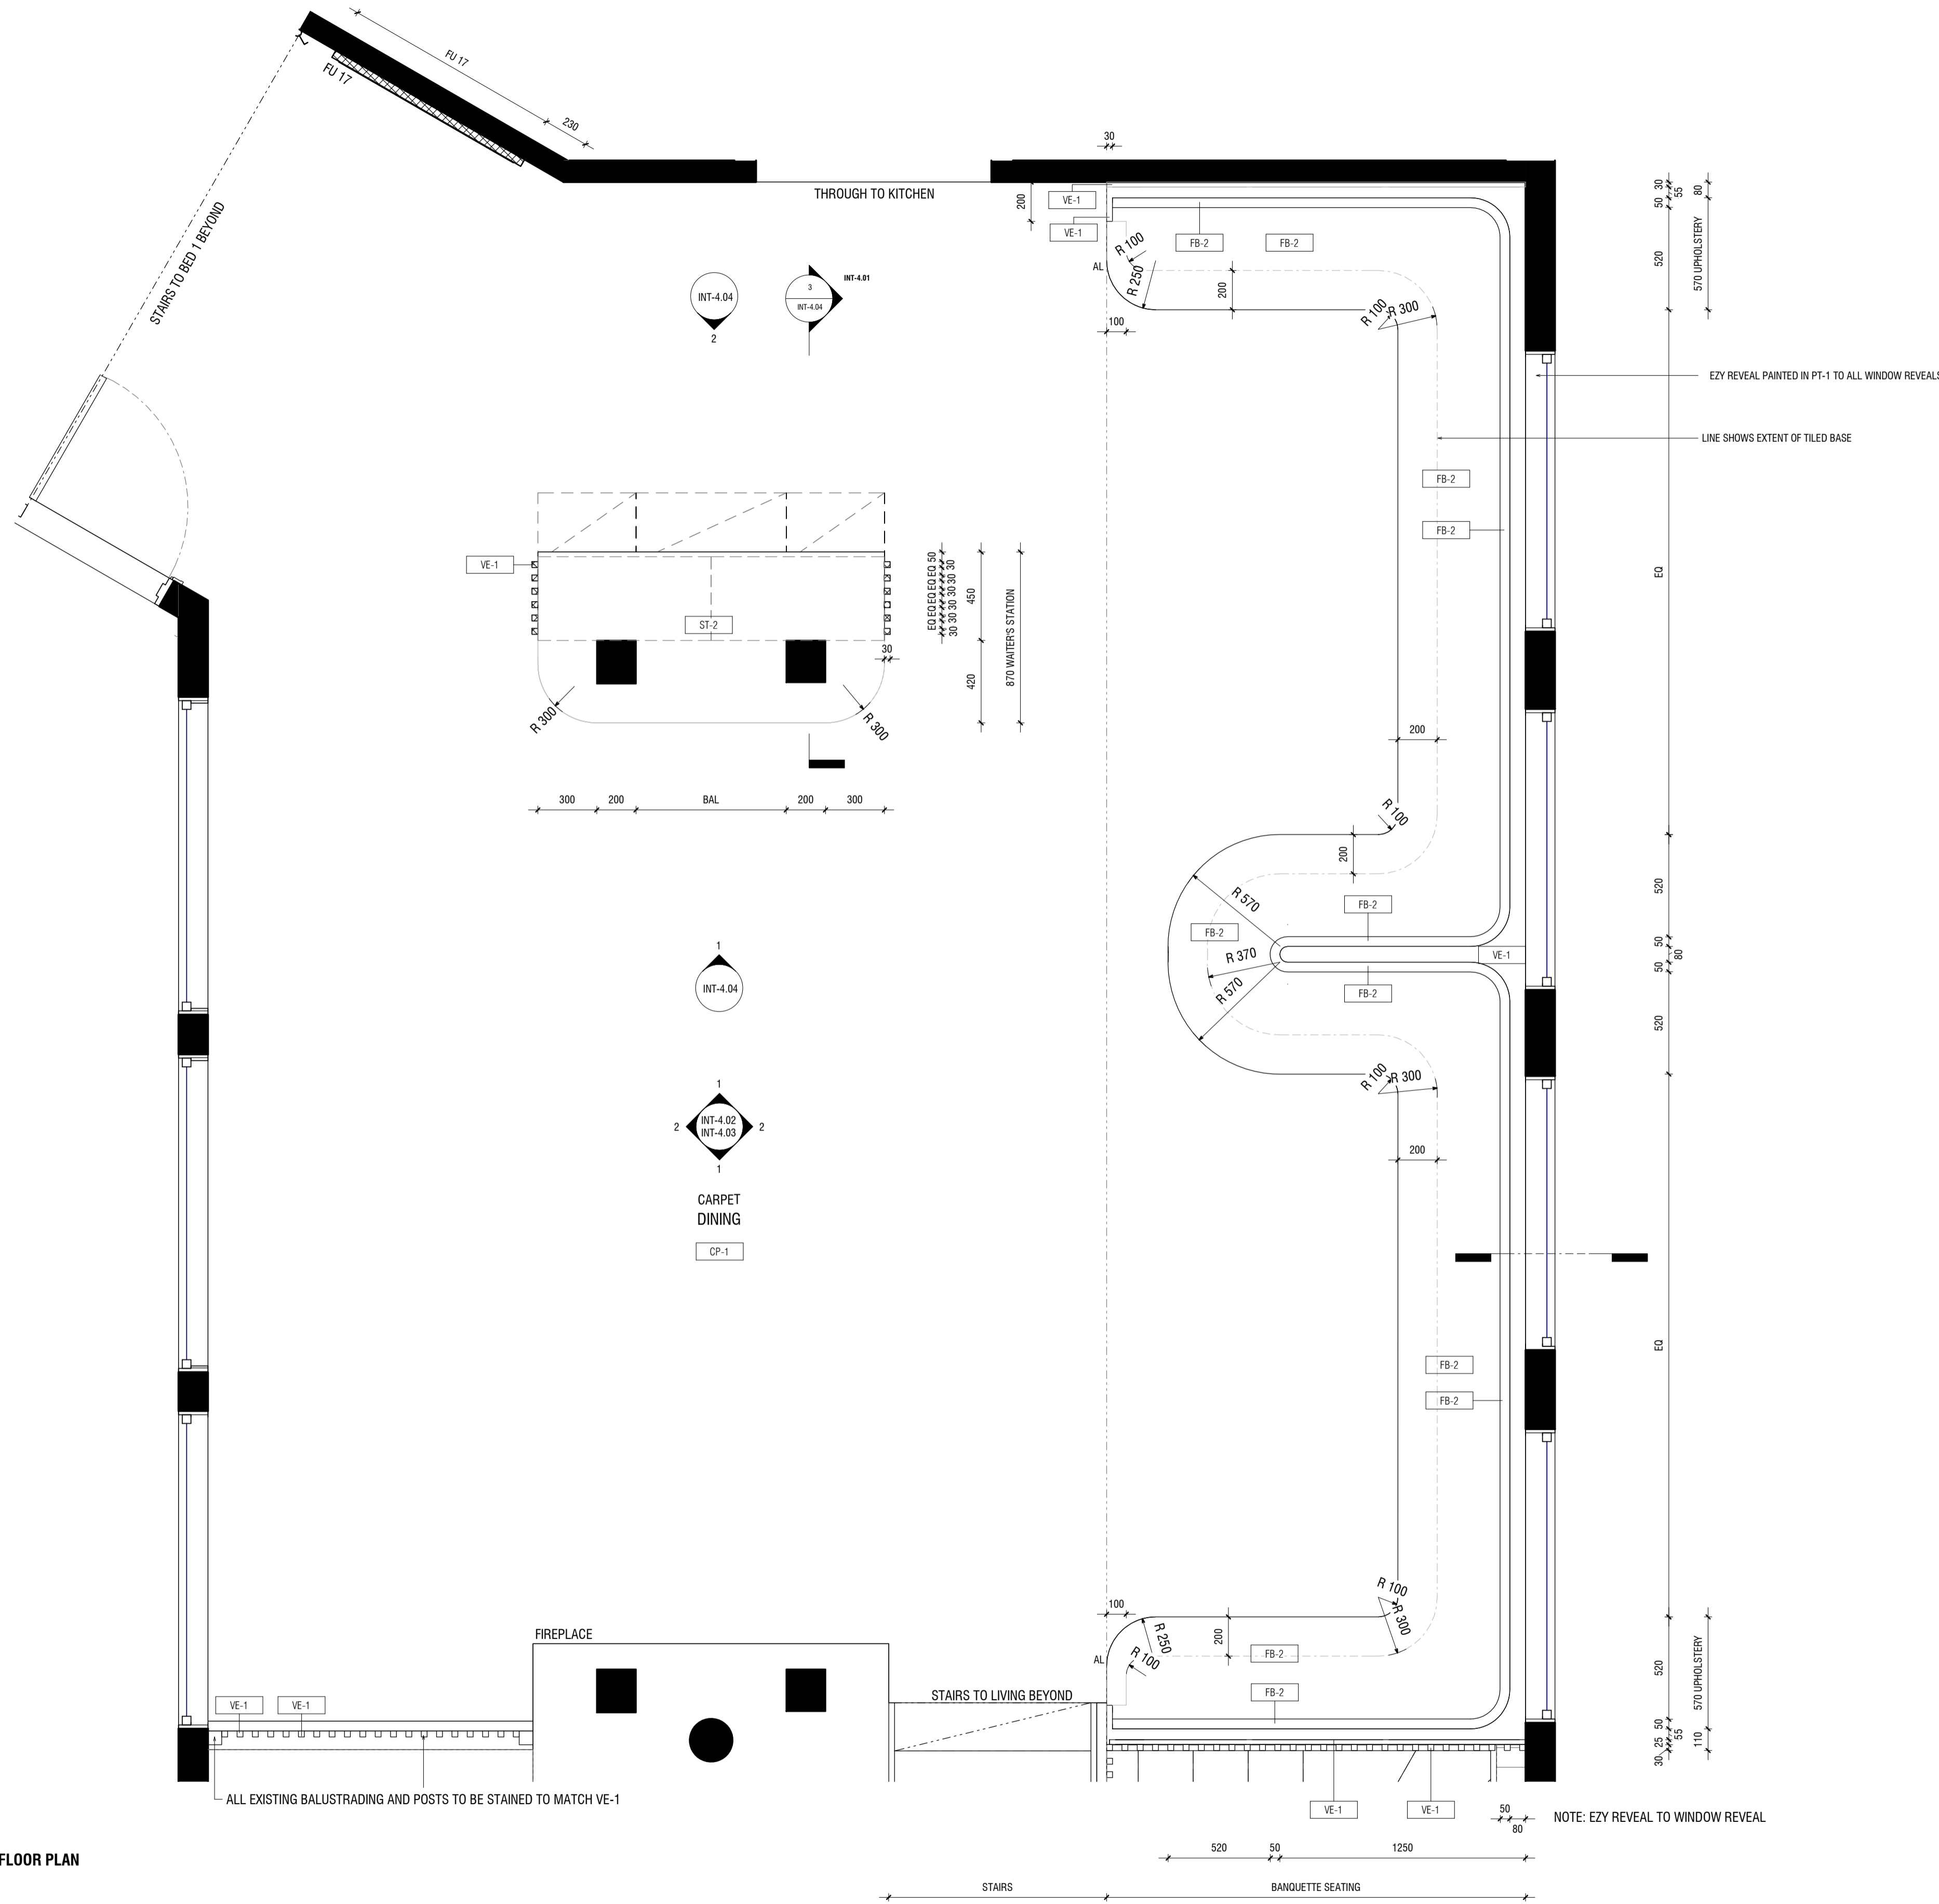

JOINERY

AS	ADJUSTABLE SHELF
AL	ALIGN
BAL	BALANCE
BS	BIFOLD SLIDING
CL	CENTRE LINE
DA	DOOR ACTIVATED
DLFH	BLUM DRAWER LEGRABOX FREE HIGH - 177 MM
DLFL	BLUM DRAWER LEGRABOX FREE LOW - 177 MM
DLPC	BLUM DRAWER LEGRABOX PURE C - 177 MM
DLPF	BLUM DRAWER LEGRABOX PURE F - 241 MM
DLPK	BLUM DRAWER LEGRABOX PURE K - 128.5 MM
DLPM	BLUM DRAWER LEGRABOX PURE M - 90.5 MM
DM	BLUM DRAWER MOVENTO (MELAMINE DRAWER BOX)
EQ	EQUAL
FS	FIXED SHELF
FP	FIXED PANNEL
HDB	HINGE DOOR - BLUM ONYX BLACK HINGES
HDN	HINGE DOOR - BLUM NICKEL PLATED HINGES
HF	HINGE FLAP
HR	HANGING RAIL
IAS	INTERNAL ADJUSTABLE SHELF
IDLFH	BLUM INTERNAL DRAWER LEGRABOX FREE HIGH - 177 MM
IDFL	BLUM INTERNAL DRAWER LEGRABOX FREE LOW - 177 MM
IDLPC	BLUM INTERNAL DRAWER LEGRABOX PURE C - 177 MM
IDLPF	BLUM INTERNAL DRAWER LEGRABOX PURE F - 241 MM
IDLPK	BLUM INTERNAL DRAWER LEGRABOX PURE K - 128.5 MM
IDLPM	BLUM INTERNAL DRAWER LEGRABOX PURE M - 90.5 MM
IDM	BLUM INTERNAL DRAWER MOVENTO (MELAMINE DRAWER BOX)
IFS	INTERNAL FIXED SHELF
IHDB	INTERNAL HINGE DOOR - BLUM ONYX BLACK HINGES
IHDN	INTERNAL HINGE DOOR - BLUM NICKEL PLATED HINGES
IPAS	INTERNAL PULLOUT ANGLED SHOE SHELF
IPS	INTERNAL PULLOUT SHELF
IJ	MITRE JOIN
PS	PULLOUT SHELF
RD	RETRACTABLE DOOR
SL	SEAM LINE
SP	SLIDING PANEL
STSM	SUBJECT TO SITE MEASURE
STAS	SUBJECT TO APPLIANCE SPECS
ⓑ	BI-FOLD OPERATION
Ⓕ	FINGER GRIP OPERATION WITH BLUMOTION
Ⓜ	MANUAL OPERATION WITH BLUMOTION
Ⓟ	PUSH TOUCH OPERATION WITH BLUM TIP ON FOR DOORS
Ⓡ	TIP ON OPERATION WITH BLUMOTION FOR DRAWERS
Ⓢ	SERVO-DRIVE OPERATION - BLUM
Ⓣ	AMBIALINE - BLUM INNER DIVIDER SYSTEM - LEGRABOX
Ⓤ	ORGALINE - BLUM INNER DIVIDER SYSTEM - MOVENTO

SCALE BAR

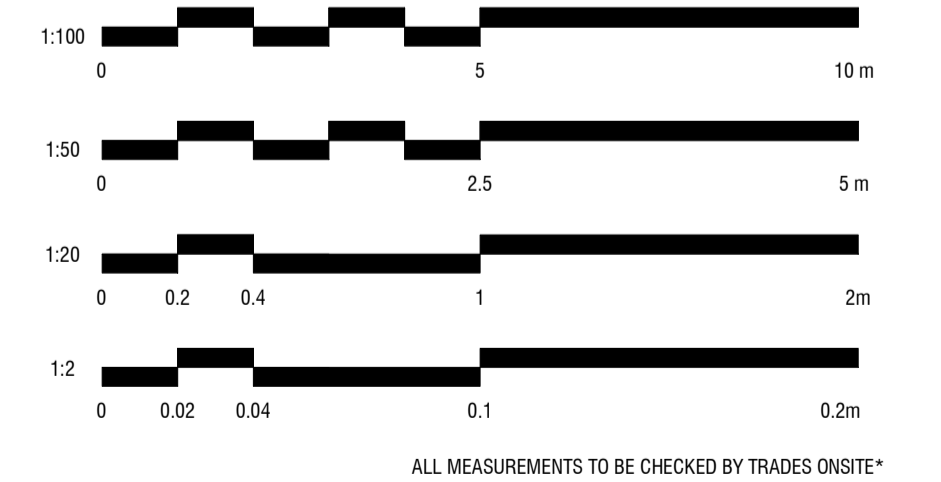

1 DINING FLOOR PLAN
1 : 20

CHRISTOPHER ELLIOTT


CHRISTOPHER ELLIOTT DESIGN PTY LTD
ABN 33131218650 ACN 131218650
T+61 (03)9077 8133 M +61 (0)403 653 649
INFO@CHRISTOPHERELLIOTTDESIGN.COM.AU
PO BOX 124 PRAHRAN 3181 VICTORIA AUSTRALIA

CLIENT AUSTRALIAN ALPINE CLUB
PROJECT ALPINE ROAD, HOTHAM HEIGHTS VIC 3741

All rights reserved. This document remains the property of Christopher Elliott Design Pty Ltd and is only to be used for its commissioned purpose. No part of this document may be reproduced, modified or transmitted in any form or by any means without the explicit written authority of Christopher Elliott Design Pty Ltd. Unauthorised use of this document in any form whatsoever is prohibited.

TITLE DINING
SCALE @ A1 AS INDICATED
CHECKED BY CE
SHEET INT-4.01


PLOT DATE 05.06.20
DRAWN BY CA
REVISION A

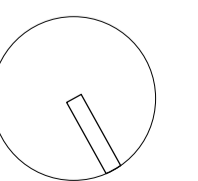


CONSTRUCTION ISSUE

REVISION STATUS

REV.	DESCRIPTION	DATE
A	REVISION #3 CONSTRUCTION DOCS ISSUED	05.06.20

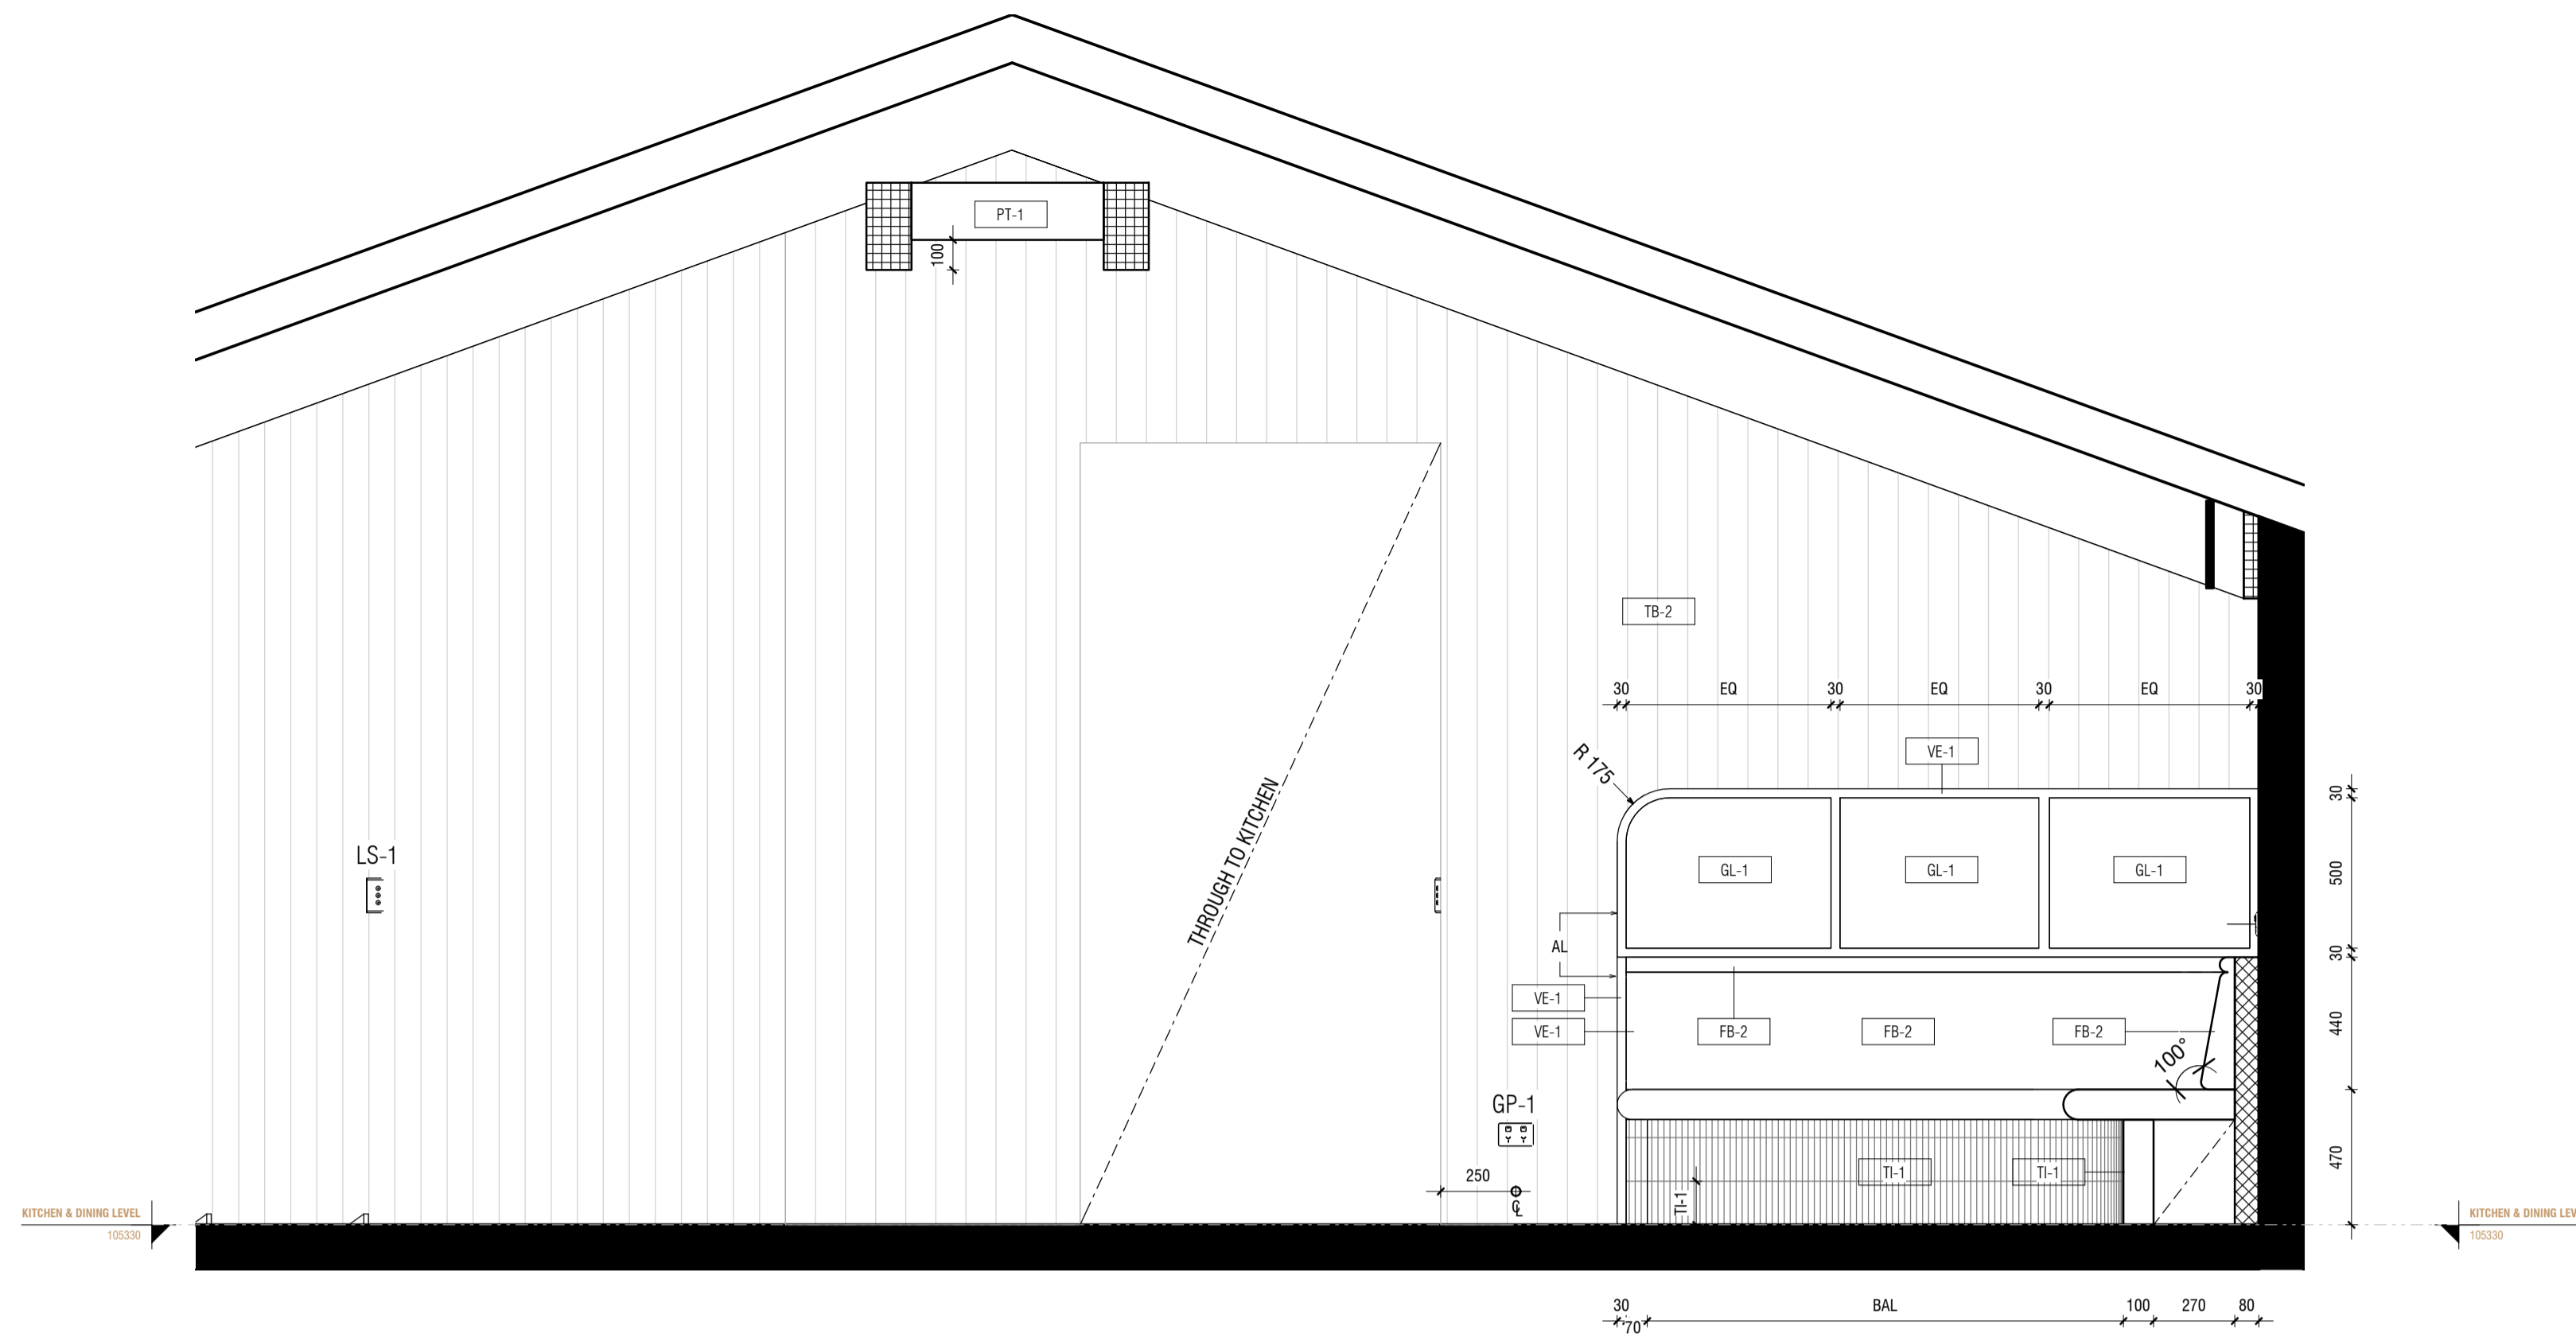

1 INT-4.02 ELEVATION 1
1:20

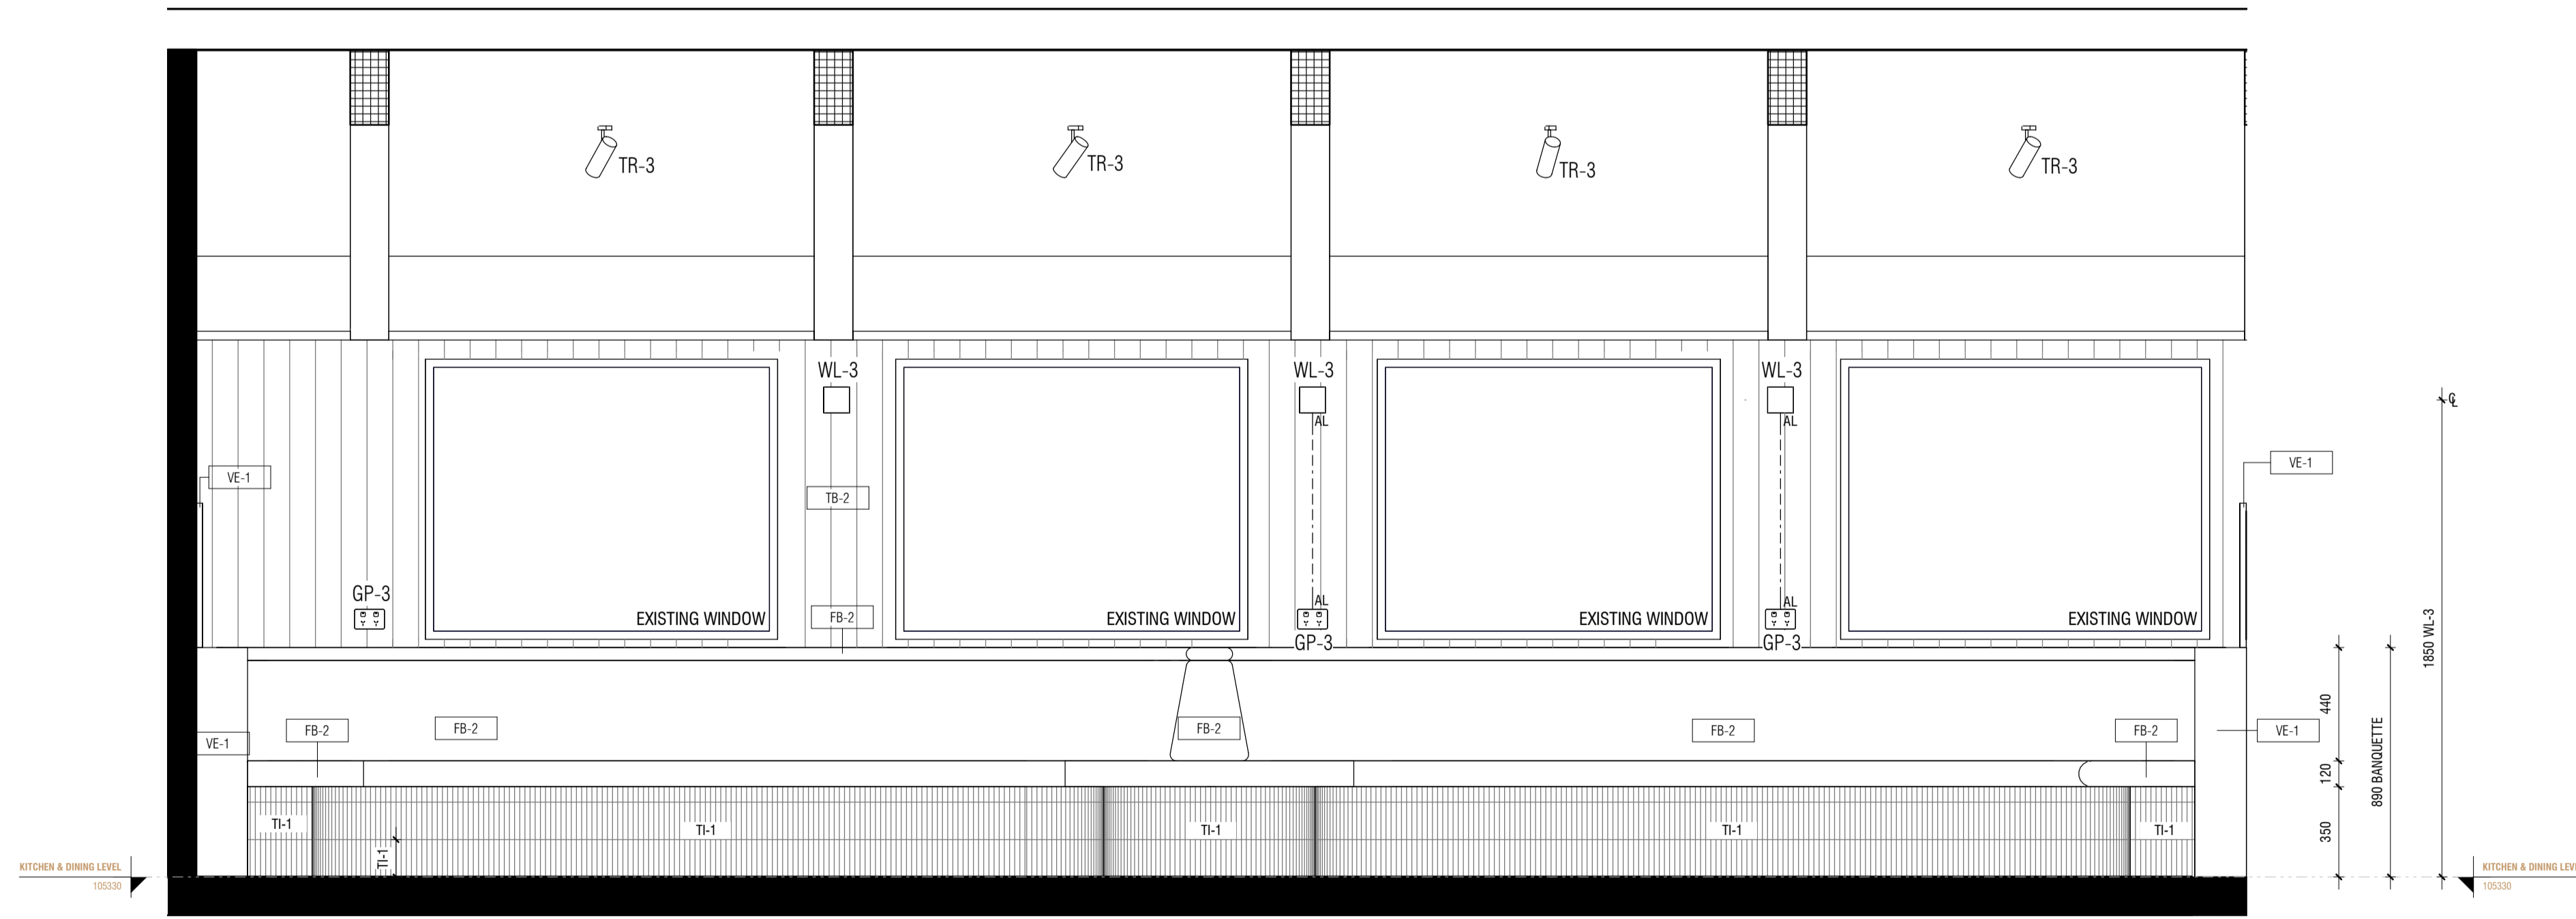


2 INT-4.02 ELEVATION 2
1:20

JOINERY

AS	ADJUSTABLE SHELF
AL	ALIGN
BAL	BALANCE
BS	BIFOLD SLIDING
CL	CENTRE LINE
DA	DOOR ACTIVATED
DLFH	BLUM DRAWER LEGRABOX FREE HIGH - 177 MM
DLFL	BLUM DRAWER LEGRABOX FREE LOW - 177 MM
DLPC	BLUM DRAWER LEGRABOX PURE C - 177 MM
DLPF	BLUM DRAWER LEGRABOX PURE F - 241 MM
DLPK	BLUM DRAWER LEGRABOX PURE K - 128.5 MM
DLPM	BLUM DRAWER LEGRABOX PURE M - 90.5 MM
DM	BLUM DRAWER MOVENTO (MELAMINE DRAWER BOX)
EQ	EQUAL
FS	FIXED SHELF
FP	FIXED PANNEL
HDB	HINGE DOOR - BLUM ONYX BLACK HINGES
HDN	HINGE DOOR - BLUM NICKEL PLATED HINGES
HF	HINGE FLAP
HR	HANGING RAIL
IAS	INTERNAL ADJUSTABLE SHELF
IDLFH	BLUM INTERNAL DRAWER LEGRABOX FREE HIGH - 177 MM
IDLFL	BLUM INTERNAL DRAWER LEGRABOX FREE LOW - 177 MM
IDLPC	BLUM INTERNAL DRAWER LEGRABOX PURE C - 177 MM
IDLPF	BLUM INTERNAL DRAWER LEGRABOX PURE F - 241 MM
IDLPK	BLUM INTERNAL DRAWER LEGRABOX PURE K - 128.5 MM
IDLPM	BLUM INTERNAL DRAWER LEGRABOX PURE M - 90.5 MM
IDM	BLUM INTERNAL DRAWER MOVENTO (MELAMINE DRAWER BOX)
IFS	INTERNAL FIXED SHELF
IHDB	INTERNAL HINGE DOOR - BLUM ONYX BLACK HINGES
IHDN	INTERNAL HINGE DOOR - BLUM NICKEL PLATED HINGES
IPAS	INTERNAL PULLOUT ANGLED SHOE SHELF
IPS	INTERNAL PULLOUT SHELF
IJ	MITRE JOIN
PS	PULLOUT SHELF
RD	RETRACTABLE DOOR
SL	SEAM LINE
SP	SLIDING PANNEL
STSM	SUBJECT TO SITE MEASURE
STAS	SUBJECT TO APPLIANCE SPECS
Ⓟ	BI-FOLD OPERATION
Ⓡ	FINGER GRIP OPERATION WITH BLUMOTION
Ⓜ	MANUAL OPERATION WITH BLUMOTION
Ⓟ	PUSH TOUCH OPERATION WITH BLUM TIP ON FOR DOORS
Ⓡ	TIP ON OPERATION WITH BLUMOTION FOR DRAWERS
Ⓢ	SERVO-DRIVE OPERATION - BLUM
Ⓜ	AMBIALINE - BLUM INNER DIVIDER SYSTEM - LEGRABOX
Ⓜ	ORGALINE - BLUM INNER DIVIDER SYSTEM - MOVENTO

SCALE BAR

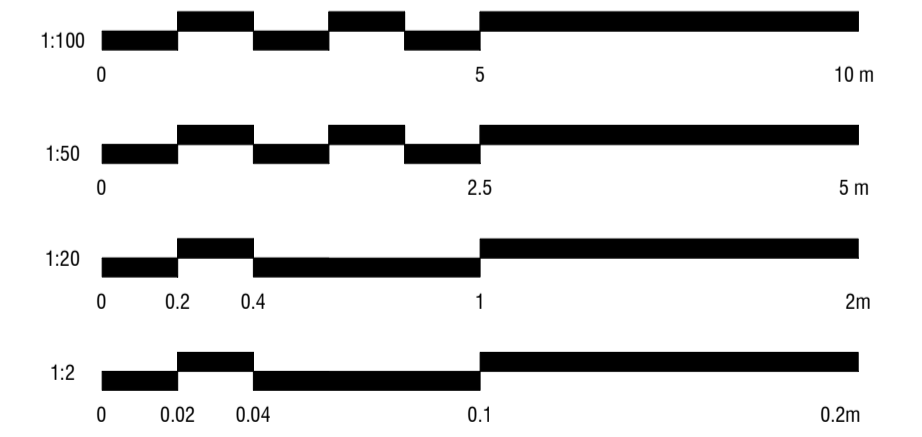


ALL MEASUREMENTS TO BE CHECKED BY TRADES ONSITE

	CHRISTOPHER ELLIOTT DESIGN PTY LTD ABN 33131218650 ACN 131218650 T+61 (03)9077 8133 M +61 (0)403 653 649 INFO@CHRISTOPHERELLIOTTDESIGN.COM.AU PO BOX 124 PRAHRAN 3181 VICTORIA AUSTRALIA	CLIENT AUSTRALIAN ALPINE CLUB PROJECT ALPINE ROAD, HOTHAM HEIGHTS VIC 3741 All rights reserved. This document remains the property of Christopher Elliott Design Pty Ltd and is only to be used for its commissioned purpose. No part of this document may be reproduced, modified or transmitted in any form or by any means without the explicit written authority of Christopher Elliott Design Pty Ltd. Unauthorised use of this document in any form whatsoever is prohibited.	TITLE DINING SCALE @ A1 AS INDICATED CHECKED BY CE SHEET INT-4.02	PLOT DATE 05.06.20 DRAWN BY CA REVISION A
--	--	---	--	---


CONSTRUCTION ISSUE

REVISION STATUS

REV.	DESCRIPTION	DATE
A	REVISION #3 CONSTRUCTION DOCS ISSUED	05.06.20

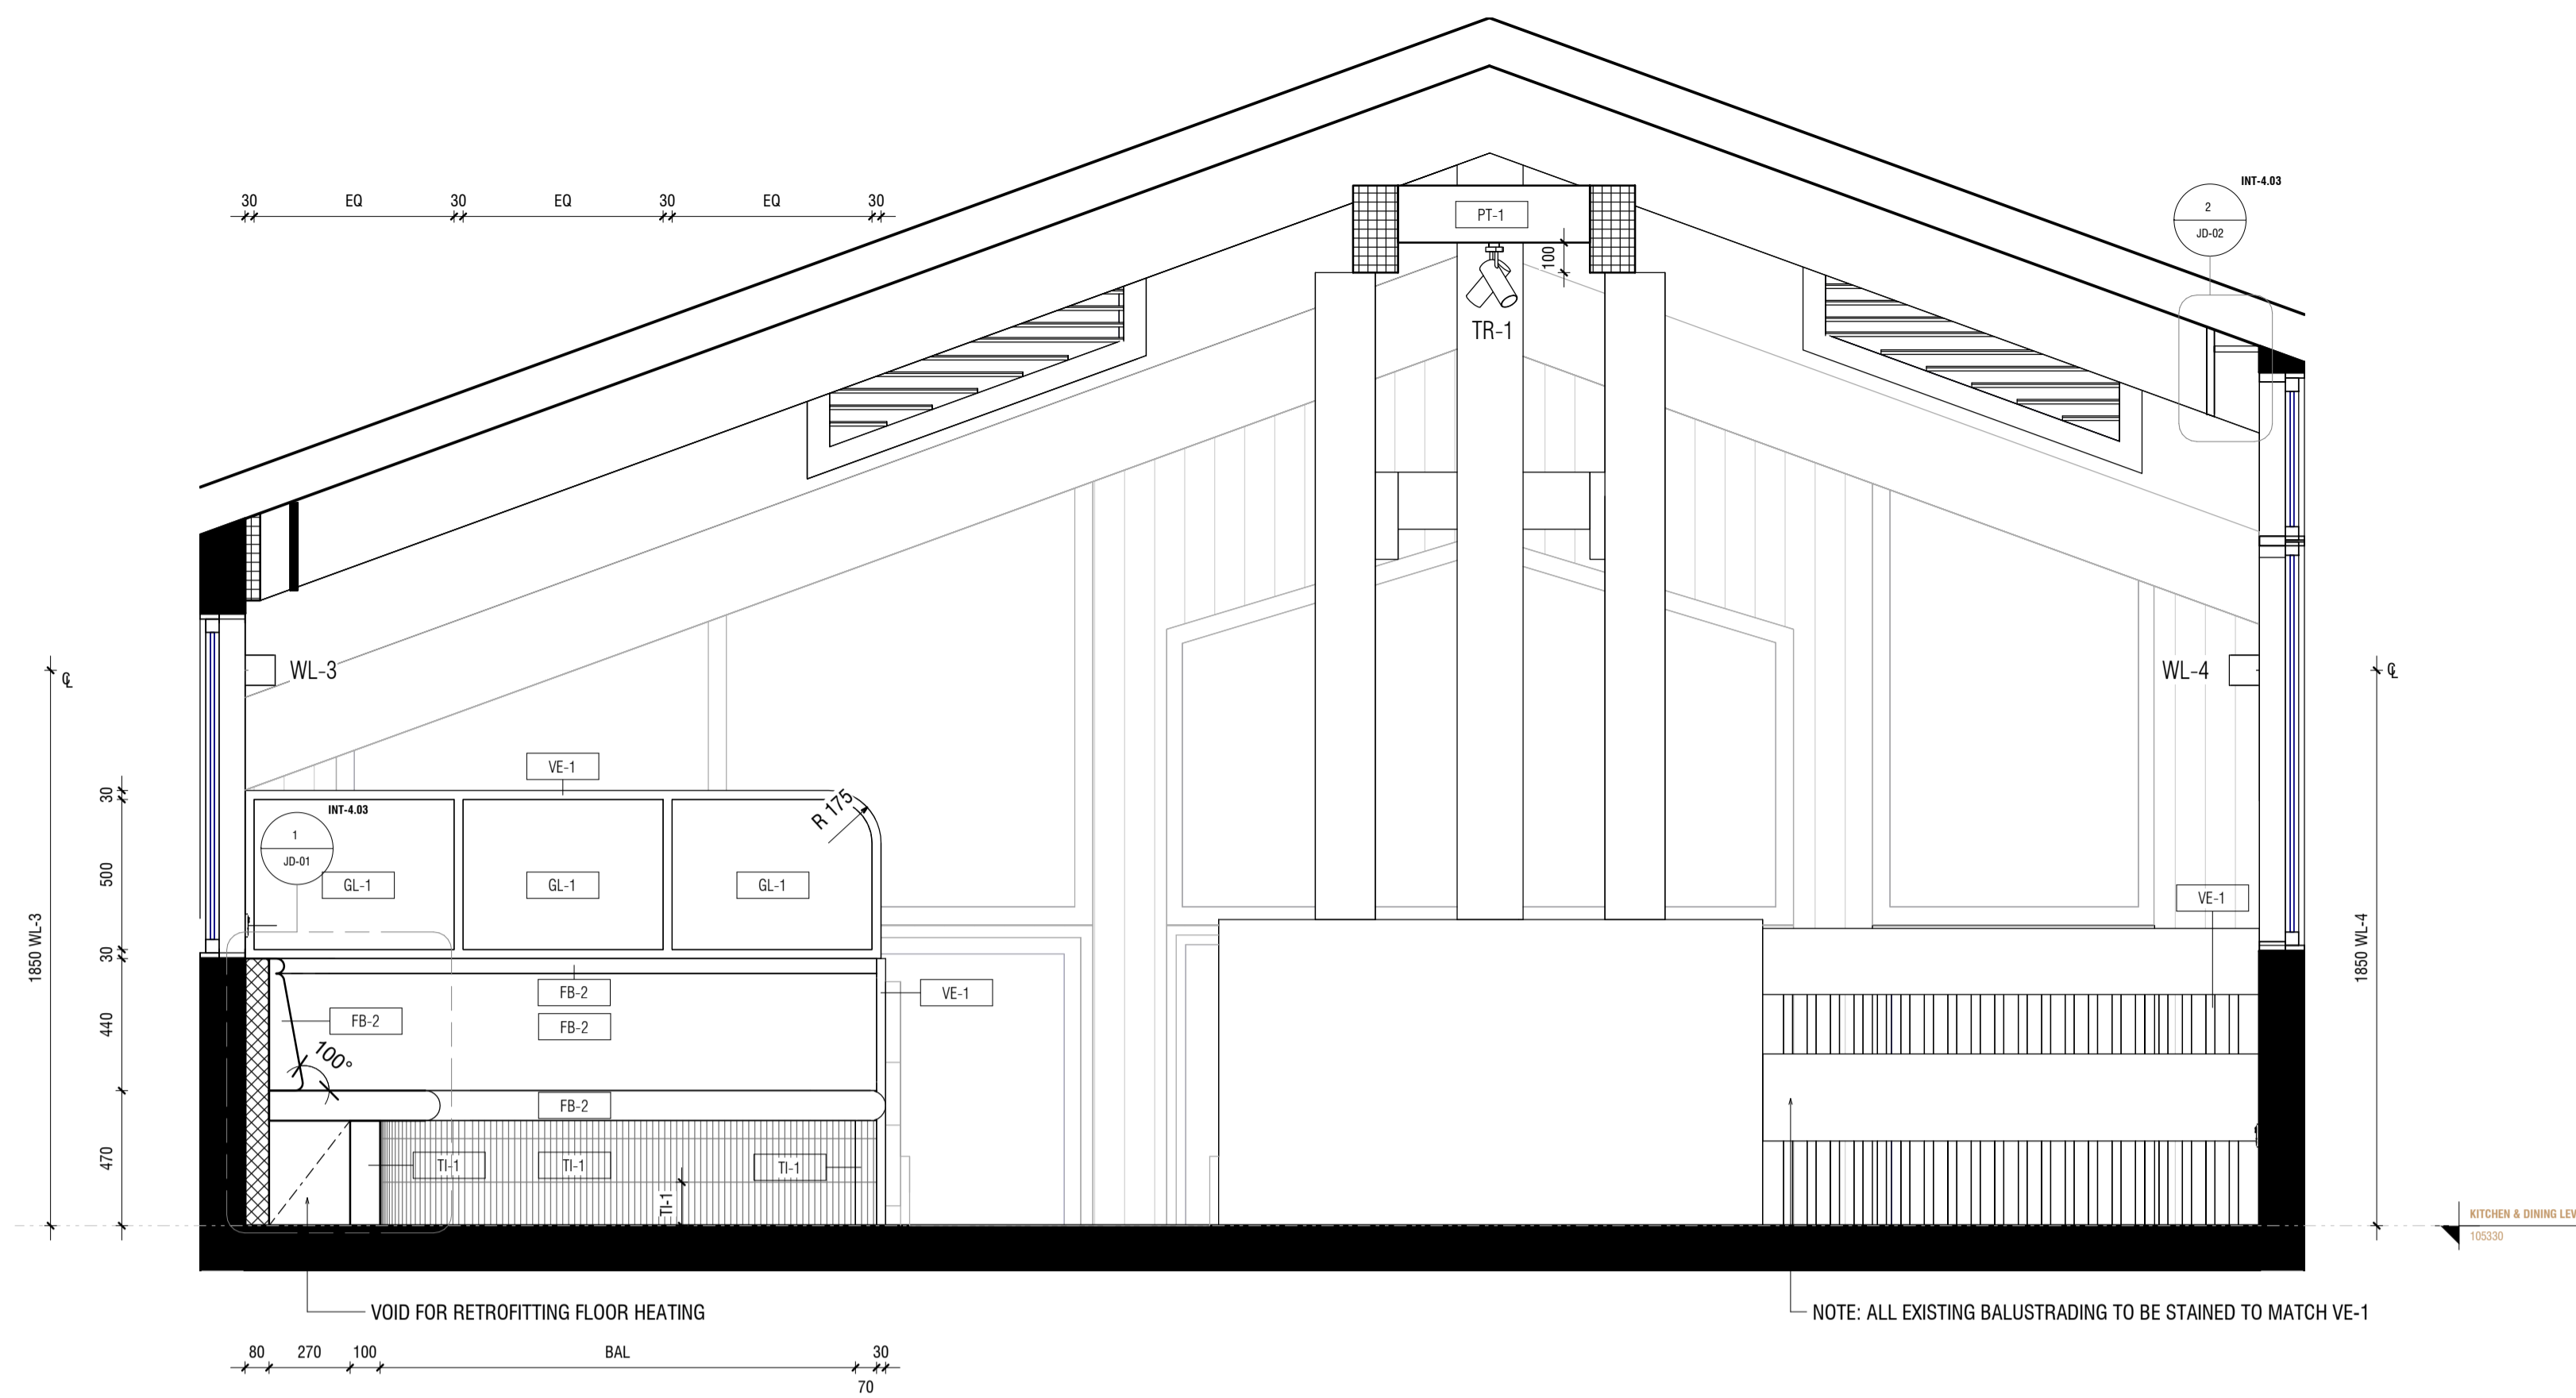

1 INT-4.03 ELEVATION 1
1:20

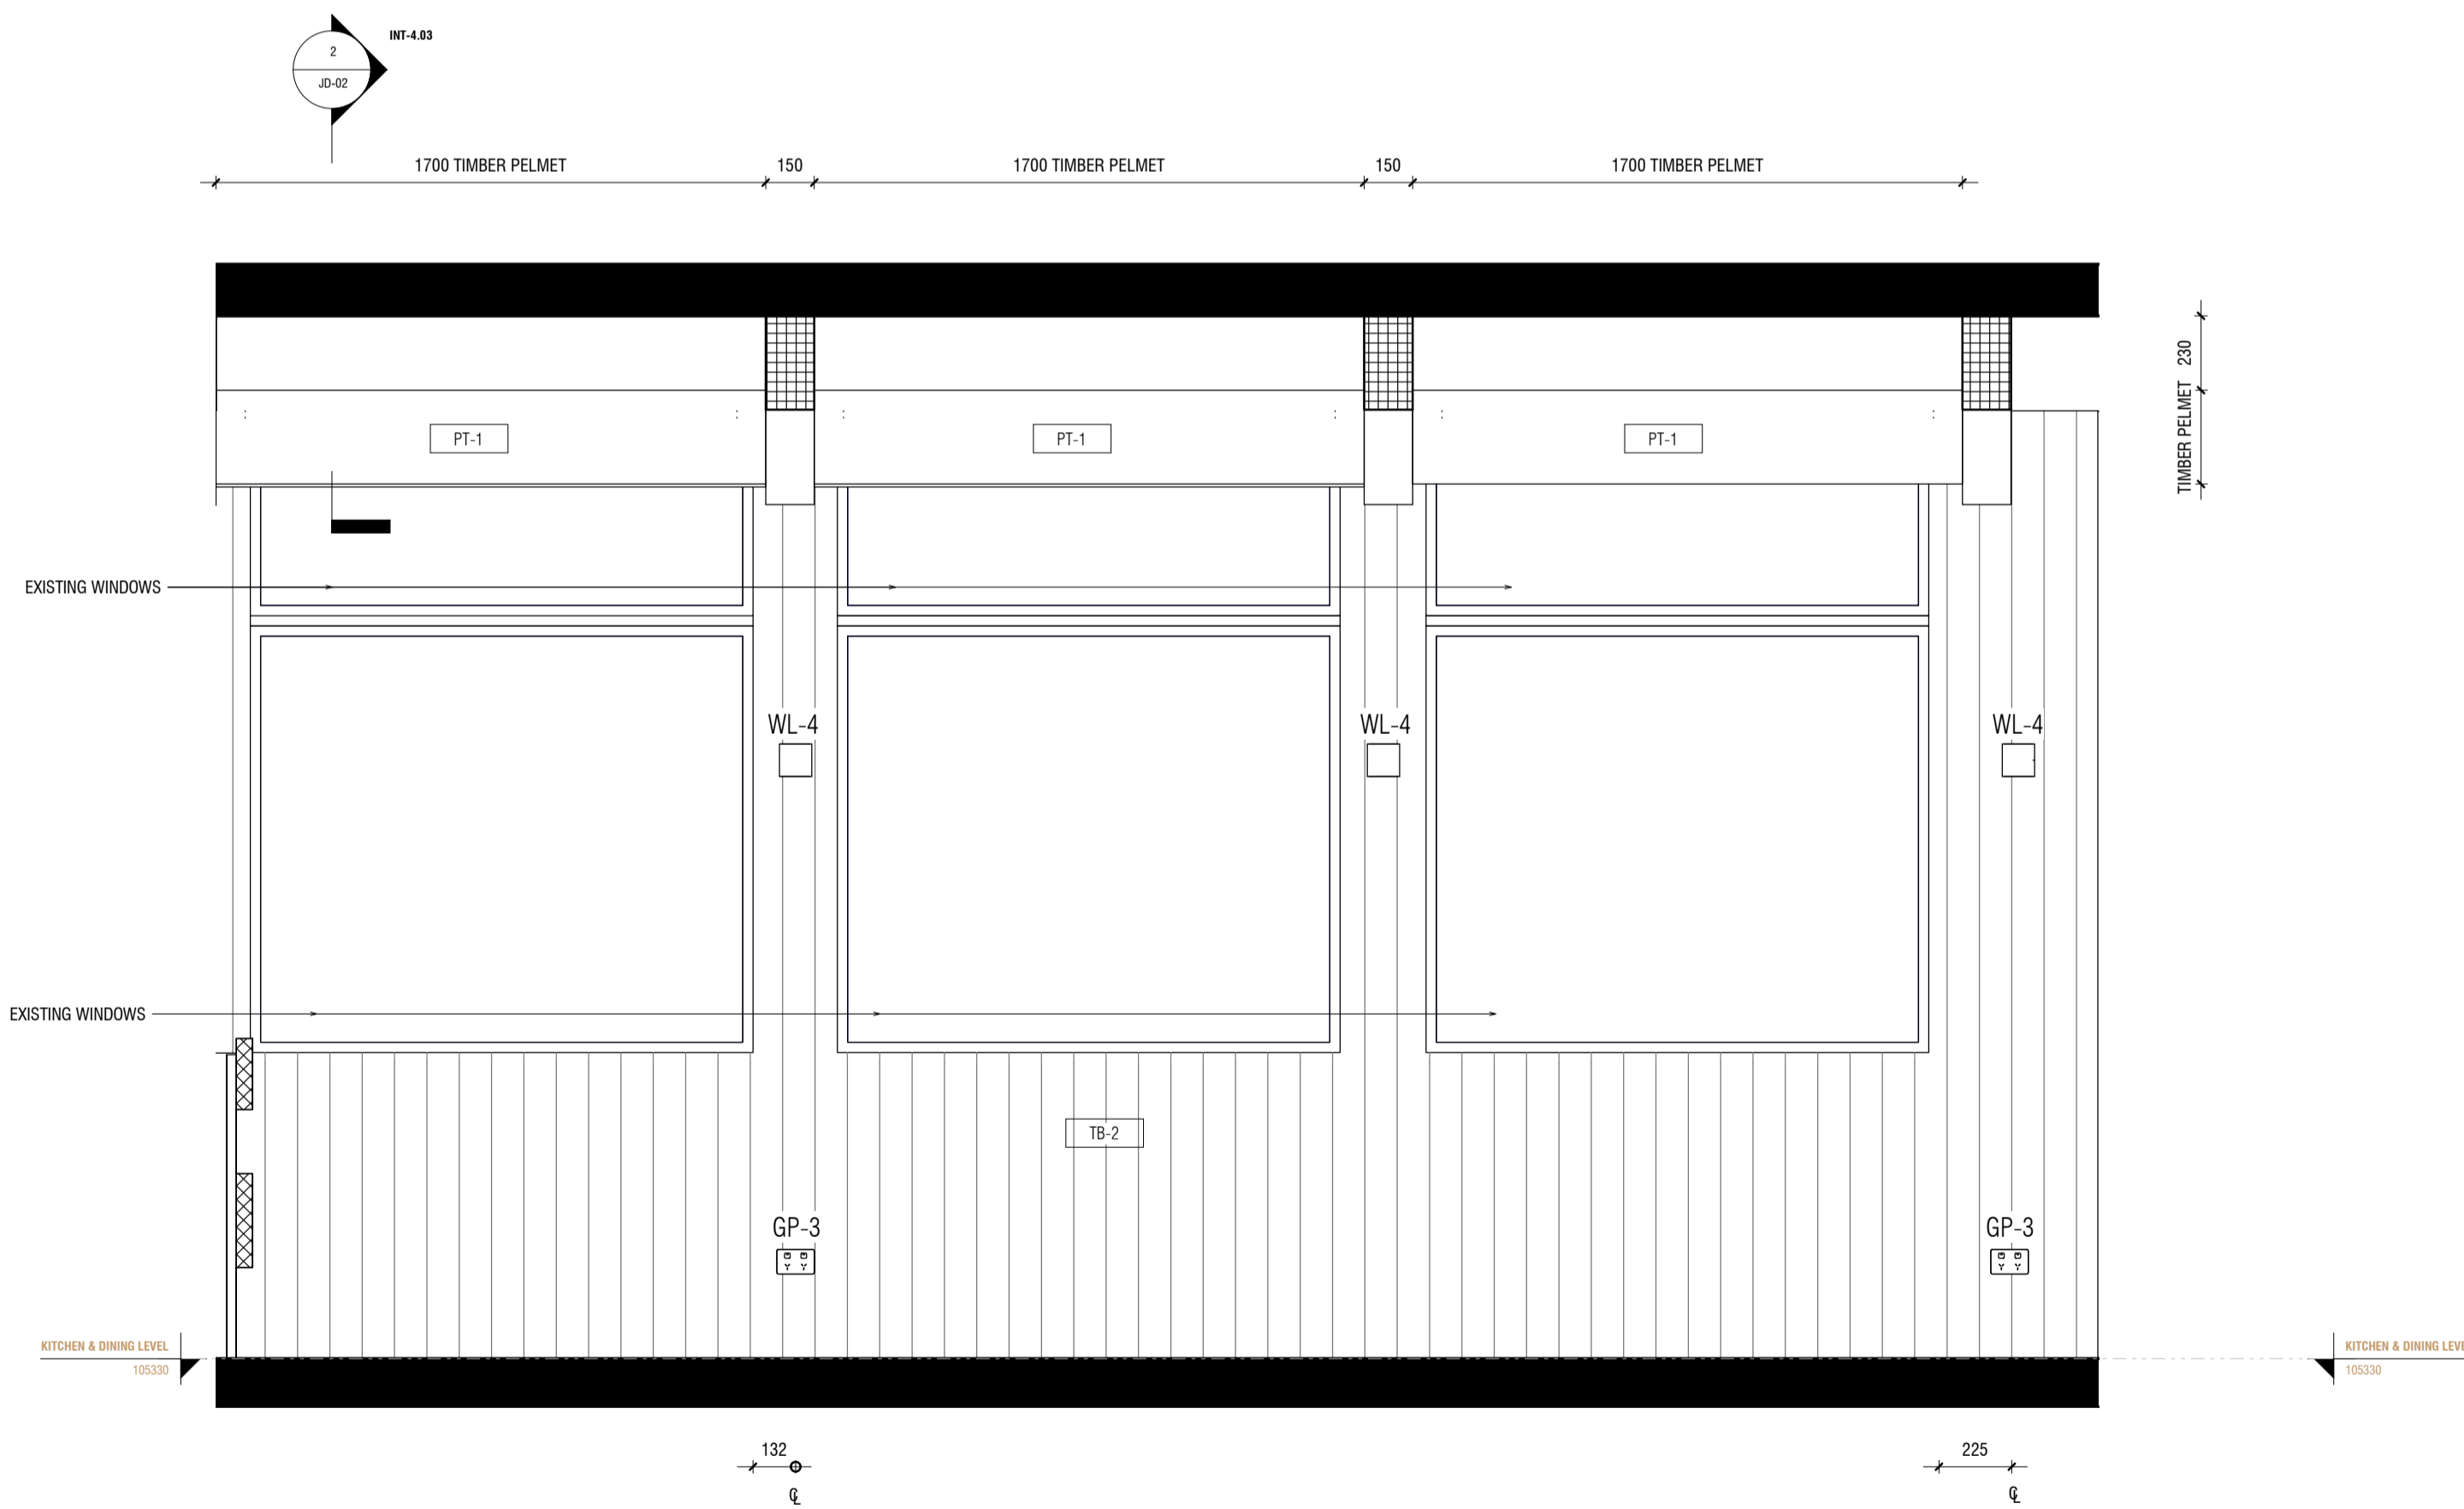


2 INT-4.03 ELEVATION 2
1:20

JOINERY

AS	ADJUSTABLE SHELF
AL	ALIGN
BAL	BALANCE
BS	BIFOLD SLIDING
CL	CENTRE LINE
DA	DOOR ACTIVATED
DLFH	BLUM DRAWER LEGRABOX FREE HIGH - 177 MM
DLFL	BLUM DRAWER LEGRABOX FREE LOW - 177 MM
DLPC	BLUM DRAWER LEGRABOX PURE C - 177 MM
DLPF	BLUM DRAWER LEGRABOX PURE F - 241 MM
DLPK	BLUM DRAWER LEGRABOX PURE K - 128.5 MM
DLPM	BLUM DRAWER LEGRABOX PURE M - 90.5 MM
DM	BLUM DRAWER MOVENTO (MELAMINE DRAWER BOX)
EQ	EQUAL
FS	FIXED SHELF
FP	FIXED PANNEL
HDB	HINGE DOOR - BLUM ONYX BLACK HINGES
HDN	HINGE DOOR - BLUM NICKEL PLATED HINGES
HF	HINGE FLAP
HR	HANGING RAIL
IAS	INTERNAL ADJUSTABLE SHELF
IDLFH	BLUM INTERNAL DRAWER LEGRABOX FREE HIGH - 177 MM
IDLFL	BLUM INTERNAL DRAWER LEGRABOX FREE LOW - 177 MM
IDLPC	BLUM INTERNAL DRAWER LEGRABOX PURE C - 177 MM
IDLPF	BLUM INTERNAL DRAWER LEGRABOX PURE F - 241 MM
IDLPK	BLUM INTERNAL DRAWER LEGRABOX PURE K - 128.5 MM
IDLPM	BLUM INTERNAL DRAWER LEGRABOX PURE M - 90.5 MM
IDM	BLUM INTERNAL DRAWER MOVENTO (MELAMINE DRAWER BOX)
IFS	INTERNAL FIXED SHELF
IHDB	INTERNAL HINGE DOOR - BLUM ONYX BLACK HINGES
IHDN	INTERNAL HINGE DOOR - BLUM NICKEL PLATED HINGES
IPAS	INTERNAL PULLOUT ANGLED SHOE SHELF
IPS	INTERNAL PULLOUT SHELF
MJ	MITRE JOIN
PS	PULLOUT SHELF
RD	RETRACTABLE DOOR
SL	SEAM LINE
SP	SLIDING PANEL
STSM	SUBJECT TO SITE MEASURE
STAS	SUBJECT TO APPLIANCE SPECS
Ⓟ	BI-FOLD OPERATION
Ⓡ	FINGER GRIP OPERATION WITH BLUMOTION
Ⓜ	MANUAL OPERATION WITH BLUMOTION
Ⓟ	PUSH TOUCH OPERATION WITH BLUM TIP ON FOR DOORS
Ⓡ	TIP ON OPERATION WITH BLUMOTION FOR DRAWERS
Ⓢ	SERVO-DRIVE OPERATION - BLUM
Ⓜ	AMBIALINE - BLUM INNER DIVIDER SYSTEM - LEGRABOX
Ⓜ	ORGALINE - BLUM INNER DIVIDER SYSTEM - MOVENTO

SCALE BAR

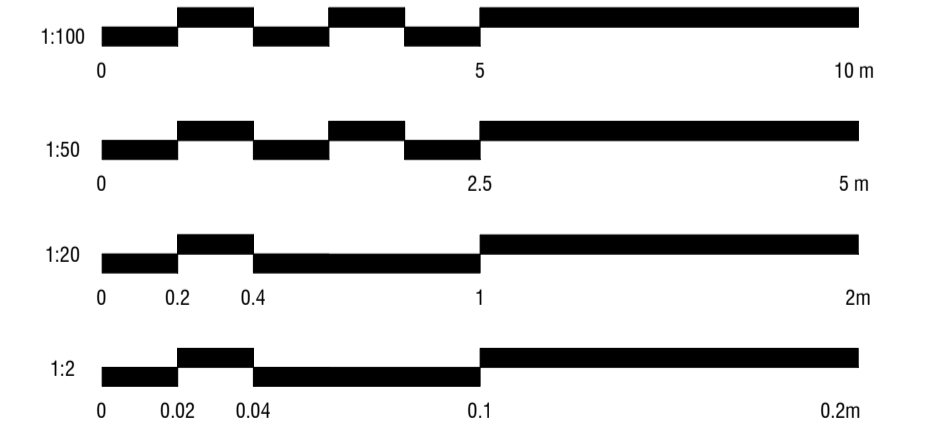

ALL MEASUREMENTS TO BE CHECKED BY TRADES ONSITE*

CHRISTOPHER
ELLIOTT


CHRISTOPHER ELLIOTT DESIGN PTY LTD
ABN 33131218650 ACN 131218650
T+61 (03)9077 8133 M +61 (0)403 653 649
INFO@CHRISTOPHERELLIOTTDESIGN.COM.AU
PO BOX 124 PRAHRAN 3181 VICTORIA AUSTRALIA

CLIENT AUSTRALIAN ALPINE CLUB
PROJECT ALPINE ROAD, HOTHAM HEIGHTS VIC 3741

All rights reserved. This document remains the property of Christopher Elliott Design Pty Ltd and is only to be used for its commissioned purpose. No part of this document may be reproduced, modified or transmitted in any form or by any means without the explicit written authority of Christopher Elliott Design Pty Ltd. Unauthorised use of this document in any form whatsoever is prohibited.

TITLE DINING
SCALE @ A1 AS INDICATED
CHECKED BY CE
SHEET INT-4.03


PLOT DATE 05.06.20
DRAWN BY CA
REVISION A

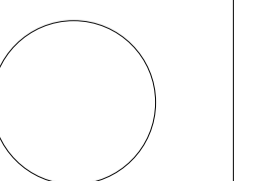


CONSTRUCTION ISSUE

REVISION STATUS


REV.	DESCRIPTION	DATE
A	REVISION #3 CONSTRUCTION DOCS ISSUED	05.06.20

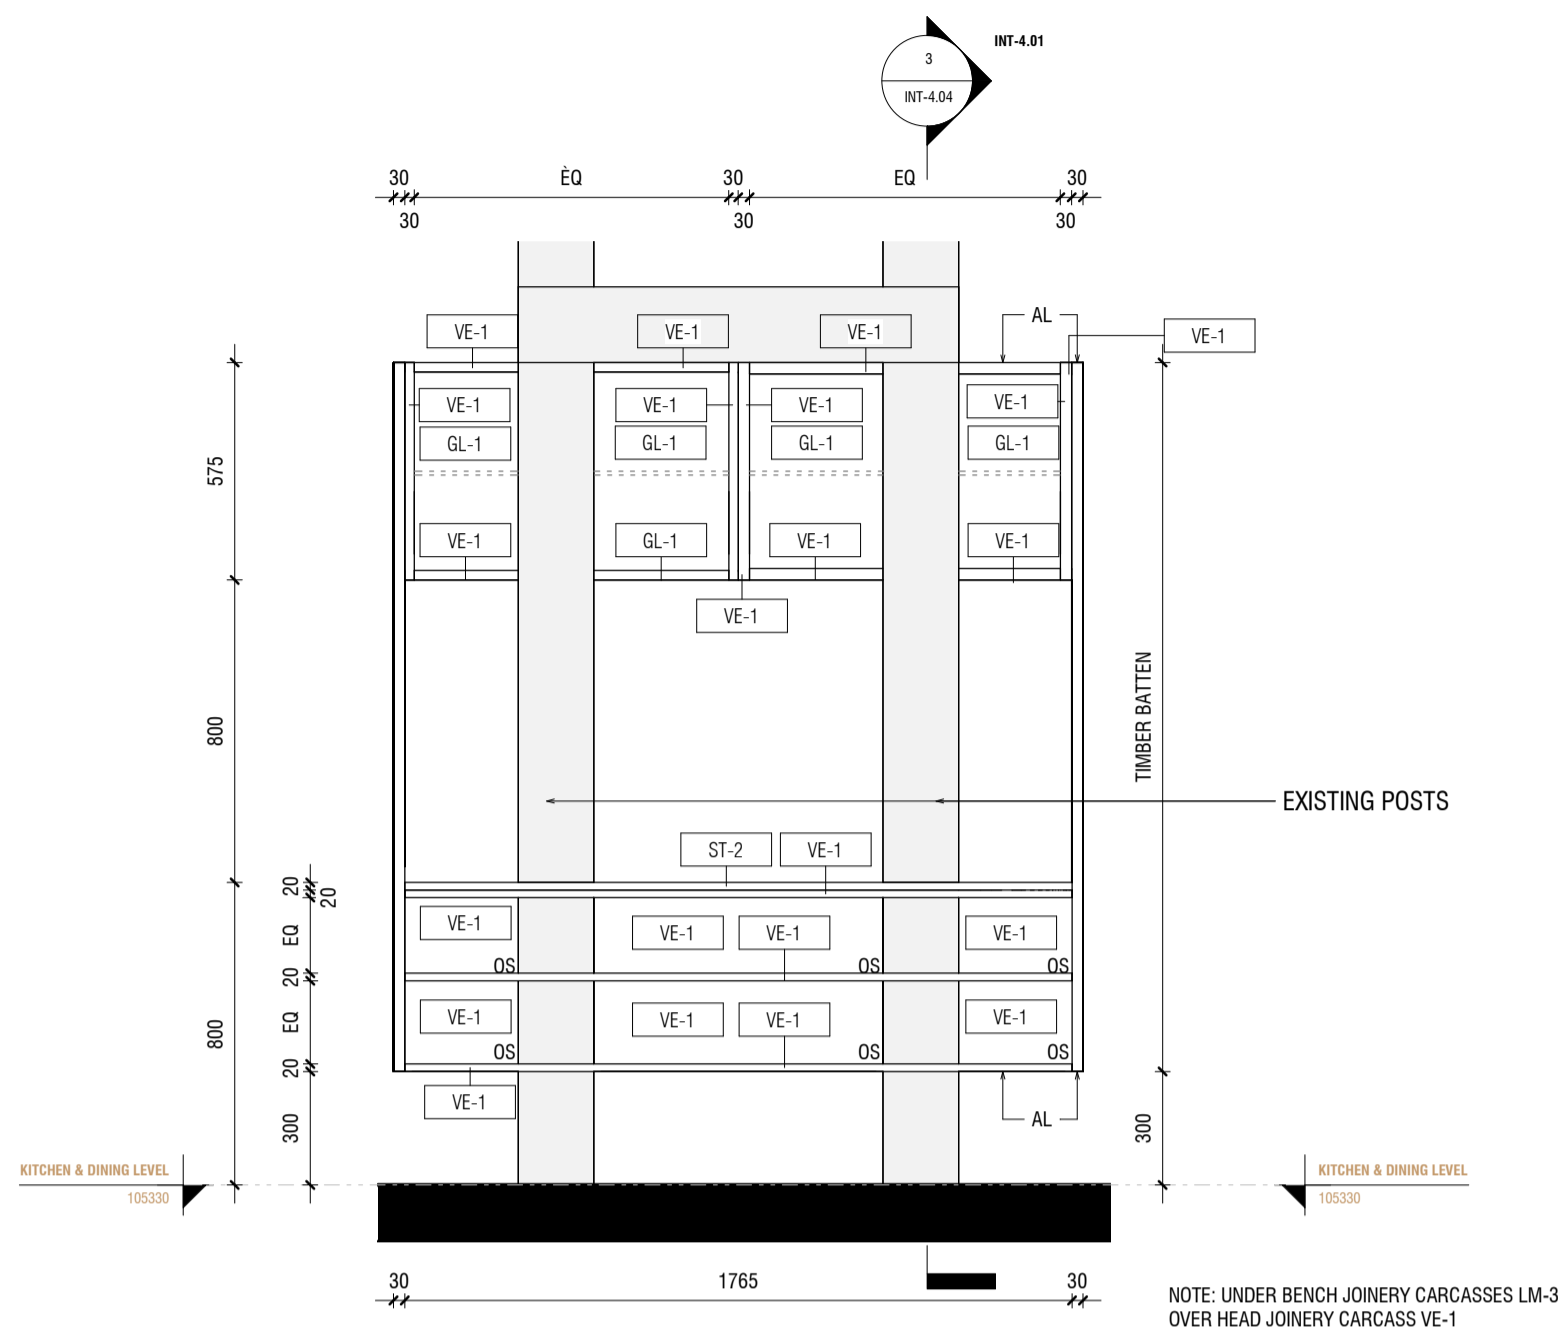

1 INT-4.04 ELEVATION 1
1 : 20

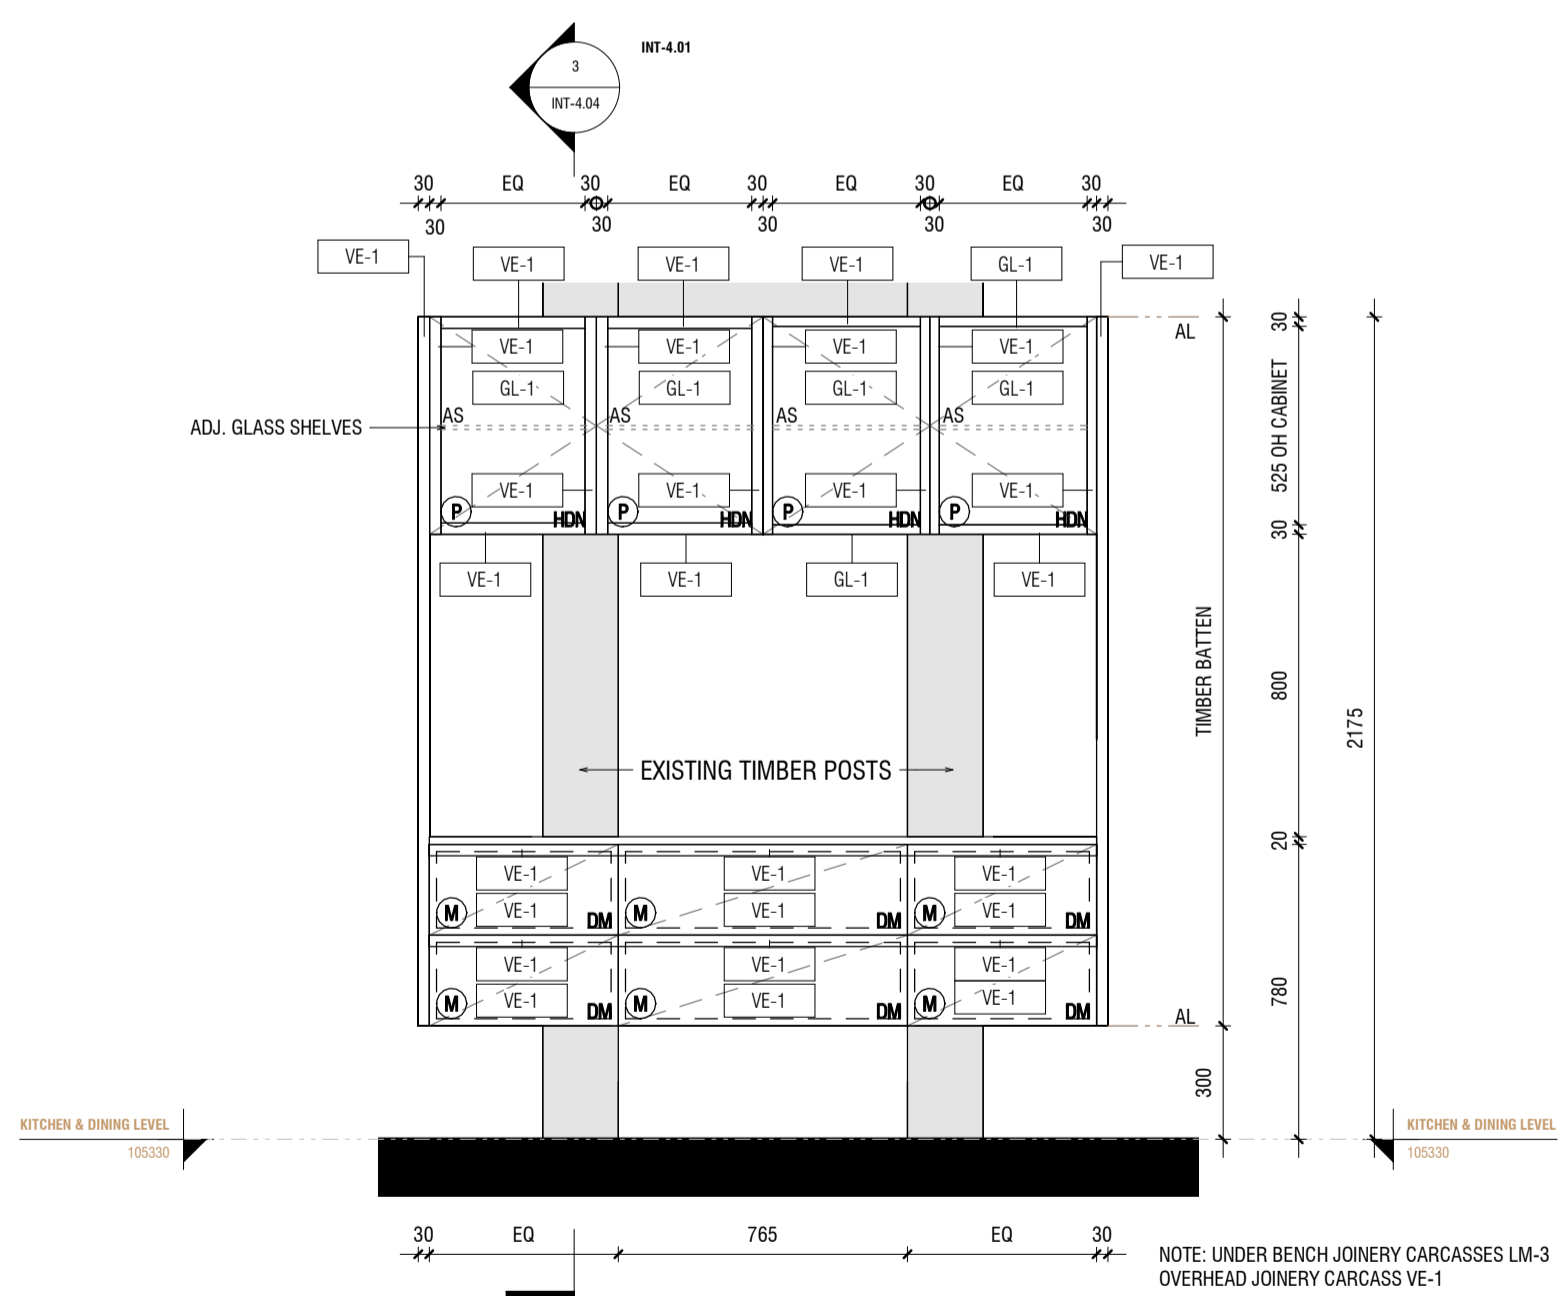

2 INT-4.04 ELEVATION 2
1 : 20

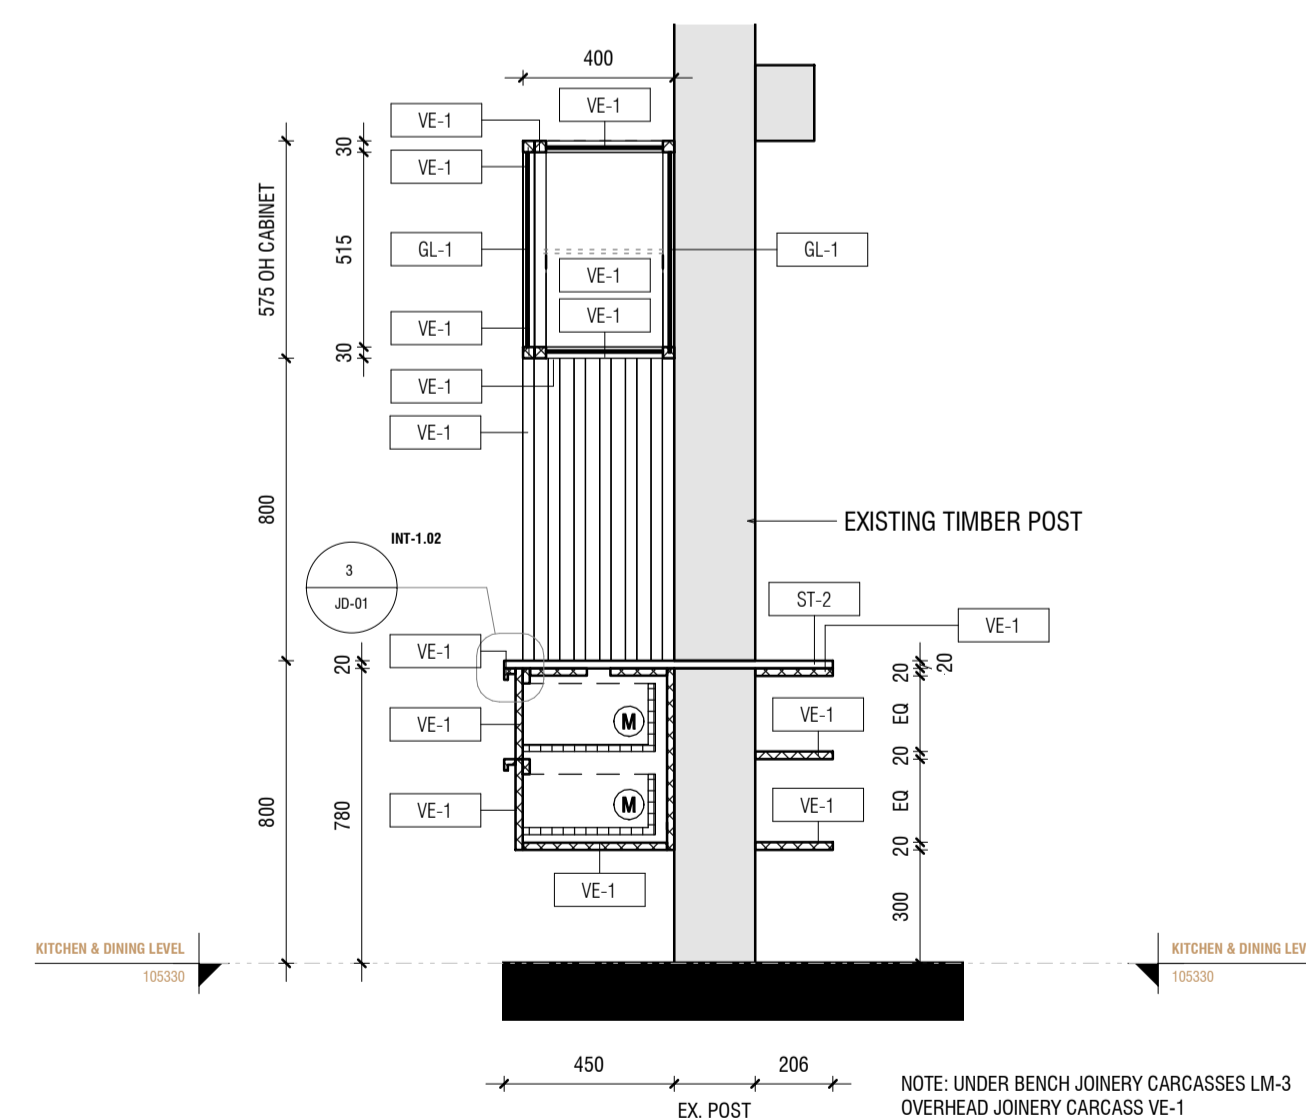


3 INT-4.04 SECTION 1
1 : 20

JOINERY

AS	ADJUSTABLE SHELF
AL	ALIGN
BAL	BALANCE
BS	BIFOLD SLIDING
CL	CENTRE LINE
DA	DOOR ACTIVATED
DLFH	BLUM DRAWER LEGRABOX FREE HIGH - 177 MM
DLFL	BLUM DRAWER LEGRABOX FREE LOW - 177 MM
DLPC	BLUM DRAWER LEGRABOX PURE C - 177 MM
DLPF	BLUM DRAWER LEGRABOX PURE F - 241 MM
DLPK	BLUM DRAWER LEGRABOX PURE K - 128.5 MM
DLPM	BLUM DRAWER LEGRABOX PURE M - 90.5 MM
DM	BLUM DRAWER MOVENTO (MELAMINE DRAWER BOX)
EQ	EQUAL
FS	FIXED SHELF
FP	FIXED PANNEL
HDB	HINGE DOOR - BLUM ONYX BLACK HINGES
HDN	HINGE DOOR - BLUM NICKEL PLATED HINGES
HF	HINGE FLAP
HR	HANGING RAIL
IAS	INTERNAL ADJUSTABLE SHELF
IDLFH	BLUM INTERNAL DRAWER LEGRABOX FREE HIGH - 177 MM
IDLFL	BLUM INTERNAL DRAWER LEGRABOX FREE LOW - 177 MM
IDLPC	BLUM INTERNAL DRAWER LEGRABOX PURE C - 177 MM
IDLPF	BLUM INTERNAL DRAWER LEGRABOX PURE F - 241 MM
IDLPK	BLUM INTERNAL DRAWER LEGRABOX PURE K - 128.5 MM
IDLPM	BLUM INTERNAL DRAWER LEGRABOX PURE M - 90.5 MM
IDM	BLUM INTERNAL DRAWER MOVENTO (MELAMINE DRAWER BOX)
IFS	INTERNAL FIXED SHELF
IHDB	INTERNAL HINGE DOOR - BLUM ONYX BLACK HINGES
IHDN	INTERNAL HINGE DOOR - BLUM NICKEL PLATED HINGES
IPAS	INTERNAL PULLOUT ANGLED SHOE SHELF
IPS	INTERNAL PULLOUT SHELF
IJ	MITRE JOIN
PS	PULLOUT SHELF
RD	RETRACTABLE DOOR
SL	SEAM LINE
SP	SLIDING PANNEL
STSM	SUBJECT TO SITE MEASURE
STAS	SUBJECT TO APPLIANCE SPECS
ⓑ	BI-FOLD OPERATION
Ⓕ	FINGER GRIP OPERATION WITH BLUMOTION
Ⓜ	MANUAL OPERATION WITH BLUMOTION
Ⓟ	PUSH TOUCH OPERATION WITH BLUM TIP ON FOR DOORS
Ⓡ	TIP ON OPERATION WITH BLUMOTION FOR DRAWERS
Ⓢ	SERVO-DRIVE OPERATION - BLUM
Ⓛ	AMBIALINE - BLUM INNER DIVIDER SYSTEM - LEGRABOX
Ⓞ	ORGALINE - BLUM INNER DIVIDER SYSTEM - MOVENTO

SCALE BAR

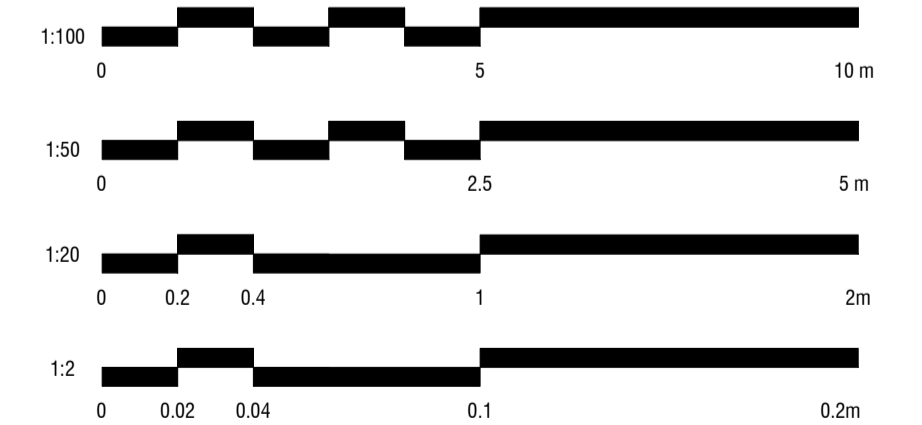

ALL MEASUREMENTS TO BE CHECKED BY TRADES ONSITE*

CHRISTOPHER
ELLIOTT


CHRISTOPHER ELLIOTT DESIGN PTY LTD
ABN 33131218650 ACN 131218650
T+61 (03)9077 8133 M +61 (0)403 653 649
INFO@CHRISTOPHERELLIOTTDESIGN.COM.AU
PO BOX 124 PRAHRAN 3181 VICTORIA AUSTRALIA

CLIENT AUSTRALIAN ALPINE CLUB
PROJECT ALPINE ROAD, HOTHAM HEIGHTS VIC 3741

All rights reserved. This document remains the property of Christopher Elliott Design Pty Ltd and is only to be used for its commissioned purpose. No part of this document may be reproduced, modified or transmitted in any form or by any means without the explicit written authority of Christopher Elliott Design Pty Ltd. Unauthorised use of this document in any form whatsoever is prohibited.

TITLE DINING
SCALE @ A1 AS INDICATED
CHECKED BY CE
SHEET INT-4.04


PLOT DATE 05.06.20
DRAWN BY CA
REVISION A

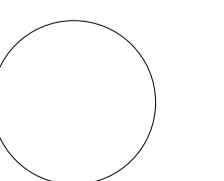

CONSTRUCTION ISSUE

REVISION STATUS


REV.	DESCRIPTION	DATE
A	REVISION #3 CONSTRUCTION DOCS ISSUED	05.06.20

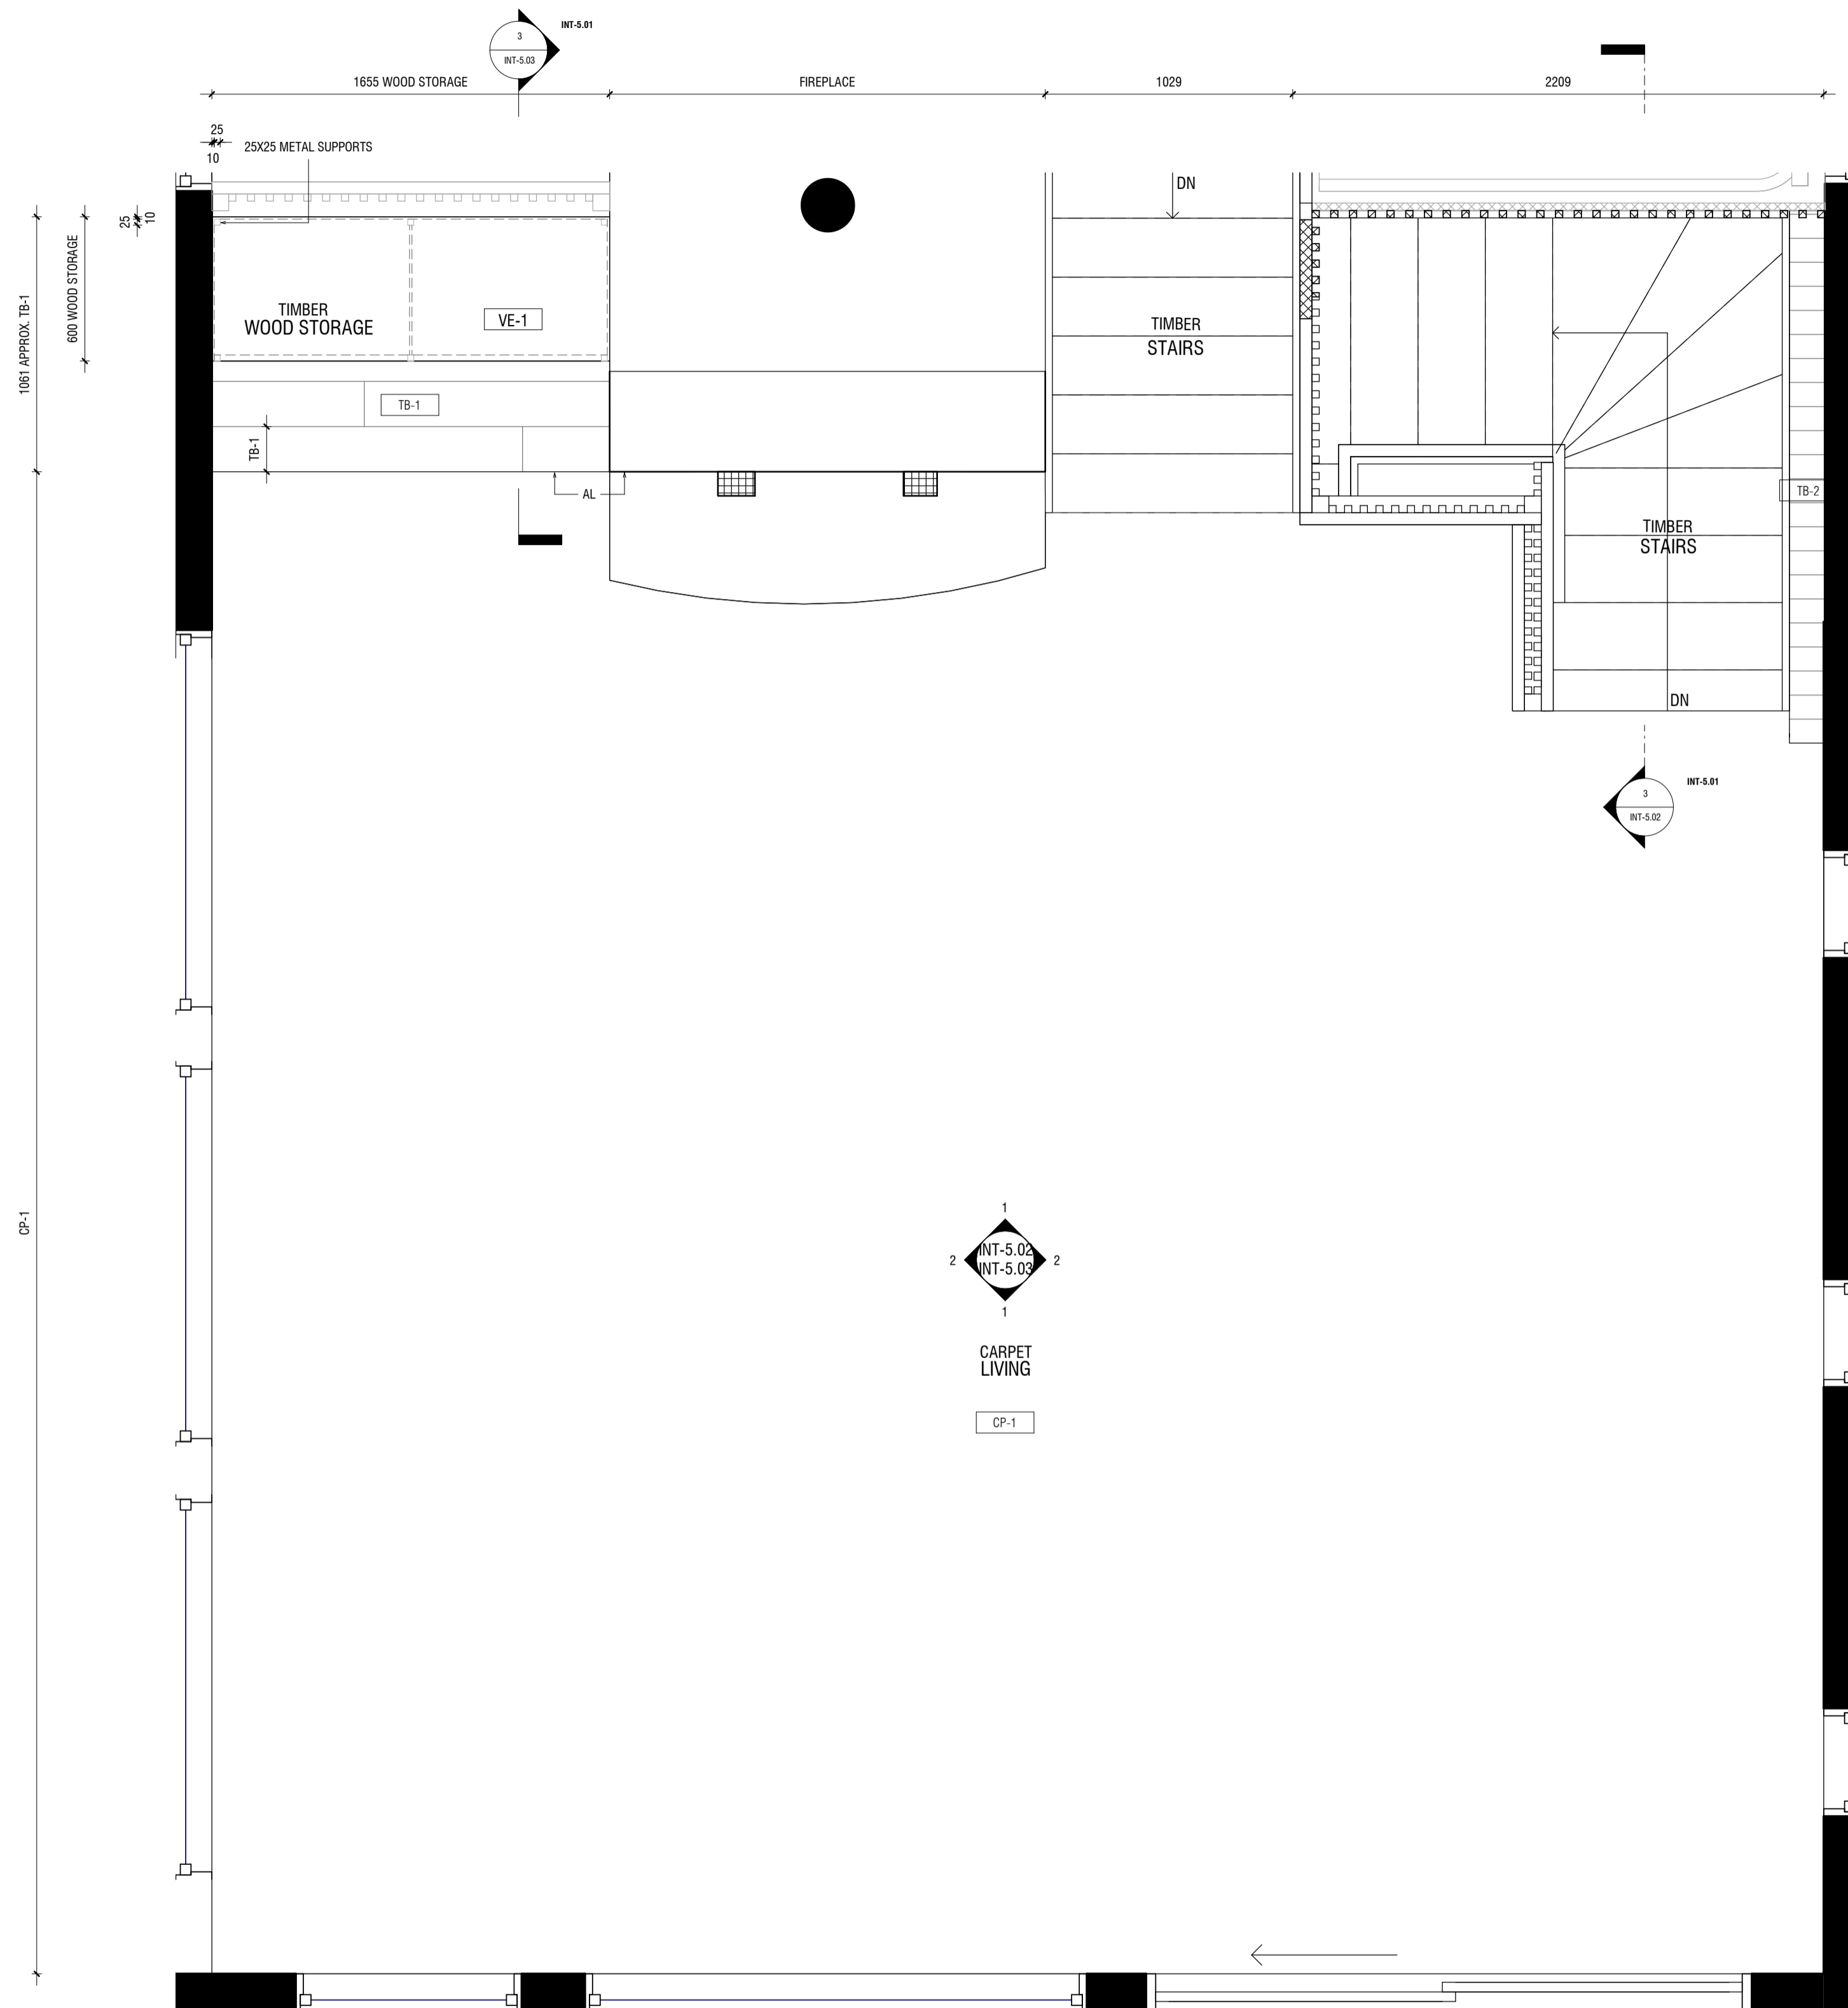

JOINERY

AS	ADJUSTABLE SHELF
AL	ALIGN
BAL	BALANCE
BS	BIFOLD SLIDING
CL	CENTRE LINE
DA	DOOR ACTIVATED
DLFH	BLUM DRAWER LEGRABOX FREE HIGH - 177 MM
DLFL	BLUM DRAWER LEGRABOX FREE LOW - 177 MM
DLPC	BLUM DRAWER LEGRABOX PURE C - 177 MM
DLPF	BLUM DRAWER LEGRABOX PURE F - 241 MM
DLPK	BLUM DRAWER LEGRABOX PURE K - 128.5 MM
DLPM	BLUM DRAWER LEGRABOX PURE M - 90.5 MM
DM	BLUM DRAWER MOVENTO (MELAMINE DRAWER BOX)
EQ	EQUAL
FS	FIXED SHELF
FP	FIXED PANNEL
HDB	HINGE DOOR - BLUM ONYX BLACK HINGES
HDN	HINGE DOOR - BLUM NICKEL PLATED HINGES
HF	HINGE FLAP
HR	HANGING RAIL
IAS	INTERNAL ADJUSTABLE SHELF
IDLFH	BLUM INTERNAL DRAWER LEGRABOX FREE HIGH - 177 MM
IDLFL	BLUM INTERNAL DRAWER LEGRABOX FREE LOW - 177 MM
IDLPC	BLUM INTERNAL DRAWER LEGRABOX PURE C - 177 MM
IDLPF	BLUM INTERNAL DRAWER LEGRABOX PURE F - 241 MM
IDLPK	BLUM INTERNAL DRAWER LEGRABOX PURE K - 128.5 MM
IDLPM	BLUM INTERNAL DRAWER LEGRABOX PURE M - 90.5 MM
IDM	BLUM INTERNAL DRAWER MOVENTO (MELAMINE DRAWER BOX)
IFS	INTERNAL FIXED SHELF
IHDB	INTERNAL HINGE DOOR - BLUM ONYX BLACK HINGES
IHDN	INTERNAL HINGE DOOR - BLUM NICKEL PLATED HINGES
IPAS	INTERNAL PULLOUT ANGLED SHOE SHELF
IPS	INTERNAL PULLOUT SHELF
MJ	MITRE JOIN
PS	PULLOUT SHELF
RD	RETRACTABLE DOOR
SL	SEAM LINE
SP	SLIDING PANEL
STSM	SUBJECT TO SITE MEASURE
STAS	SUBJECT TO APPLIANCE SPECS
ⓑ	BI-FOLD OPERATION
Ⓕ	FINGER GRIP OPERATION WITH BLUMOTION
Ⓜ	MANUAL OPERATION WITH BLUMOTION
Ⓟ	PUSH TOUCH OPERATION WITH BLUM TIP ON FOR DOORS
Ⓡ	TIP ON OPERATION WITH BLUMOTION FOR DRAWERS
Ⓢ	SERVO-DRIVE OPERATION - BLUM
Ⓜ	AMBIALINE - BLUM INNER DIVIDER SYSTEM - LEGRABOX
Ⓞ	ORGALINE - BLUM INNER DIVIDER SYSTEM - MOVENTO

SCALE BAR

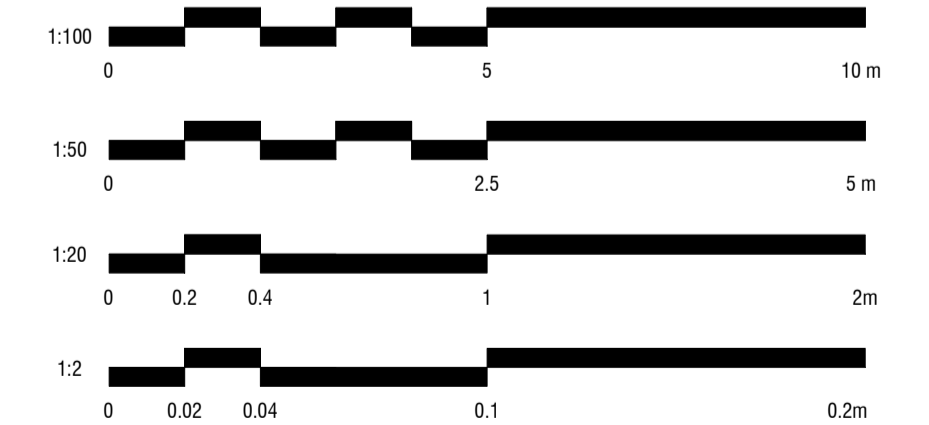

ALL MEASUREMENTS TO BE CHECKED BY TRADES ONSITE*

1 LIVING FLOOR PLAN
1:20

CHRISTOPHER
ELLIOTT


CHRISTOPHER ELLIOTT DESIGN PTY LTD
ABN 33131218650 ACN 131218650
T+61 (03)9077 8133 M +61 (0)403 653 649
INFO@CHRISTOPHERELLIOTTDESIGN.COM.AU
PO BOX 124 PRAHRAN 3181 VICTORIA AUSTRALIA

CLIENT AUSTRALIAN ALPINE CLUB
PROJECT ALPINE ROAD, HOTHAM HEIGHTS VIC 3741

All rights reserved. This document remains the property of Christopher Elliott Design Pty Ltd and is only to be used for its commissioned purpose. No part of this document may be reproduced, modified or transmitted in any form or by any means without the explicit written authority of Christopher Elliott Design Pty Ltd. Unauthorised use of this document in any form whatsoever is prohibited.

TITLE LIVING
SCALE @ A1 AS INDICATED
CHECKED BY CE
SHEET INT-5.01


PLOT DATE 05.06.20
DRAWN BY CA
REVISION A

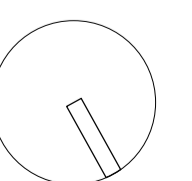


CONSTRUCTION ISSUE

REVISION STATUS


REV.	DESCRIPTION	DATE
A	REVISION #3 CONSTRUCTION DOCS ISSUED	05.06.20

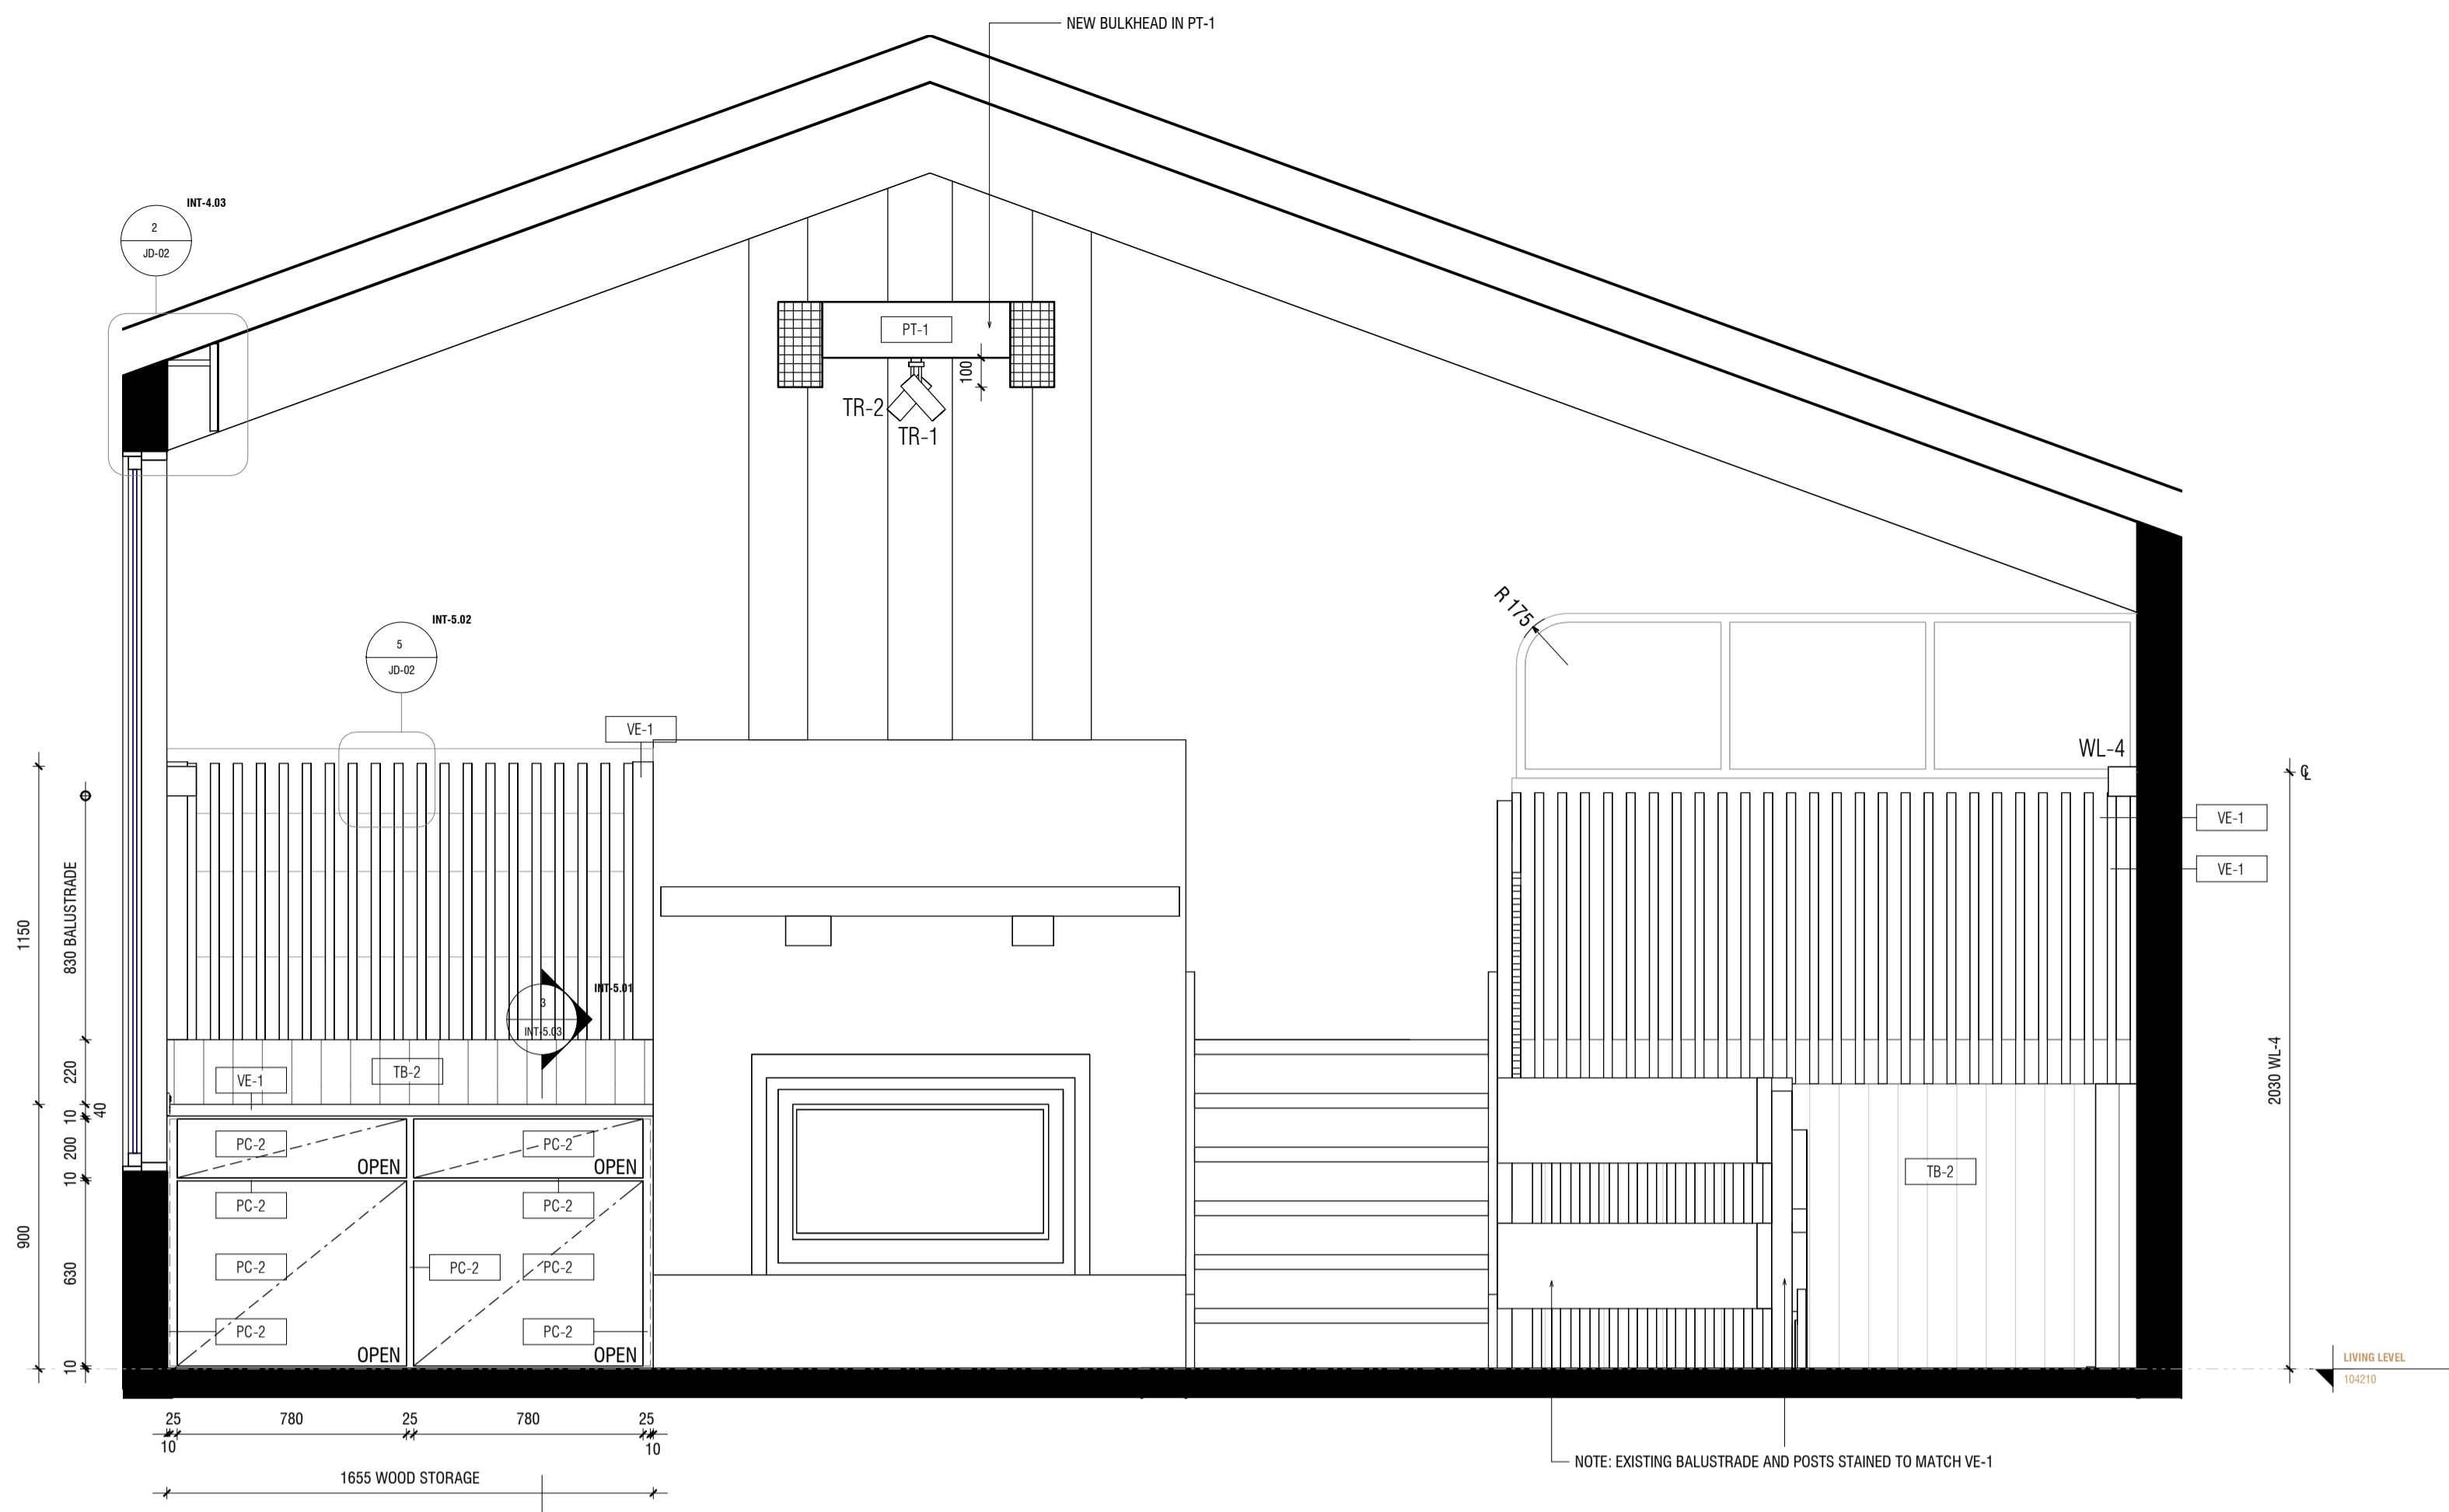

1 INT-5.02 ELEVATION 1
1 : 20

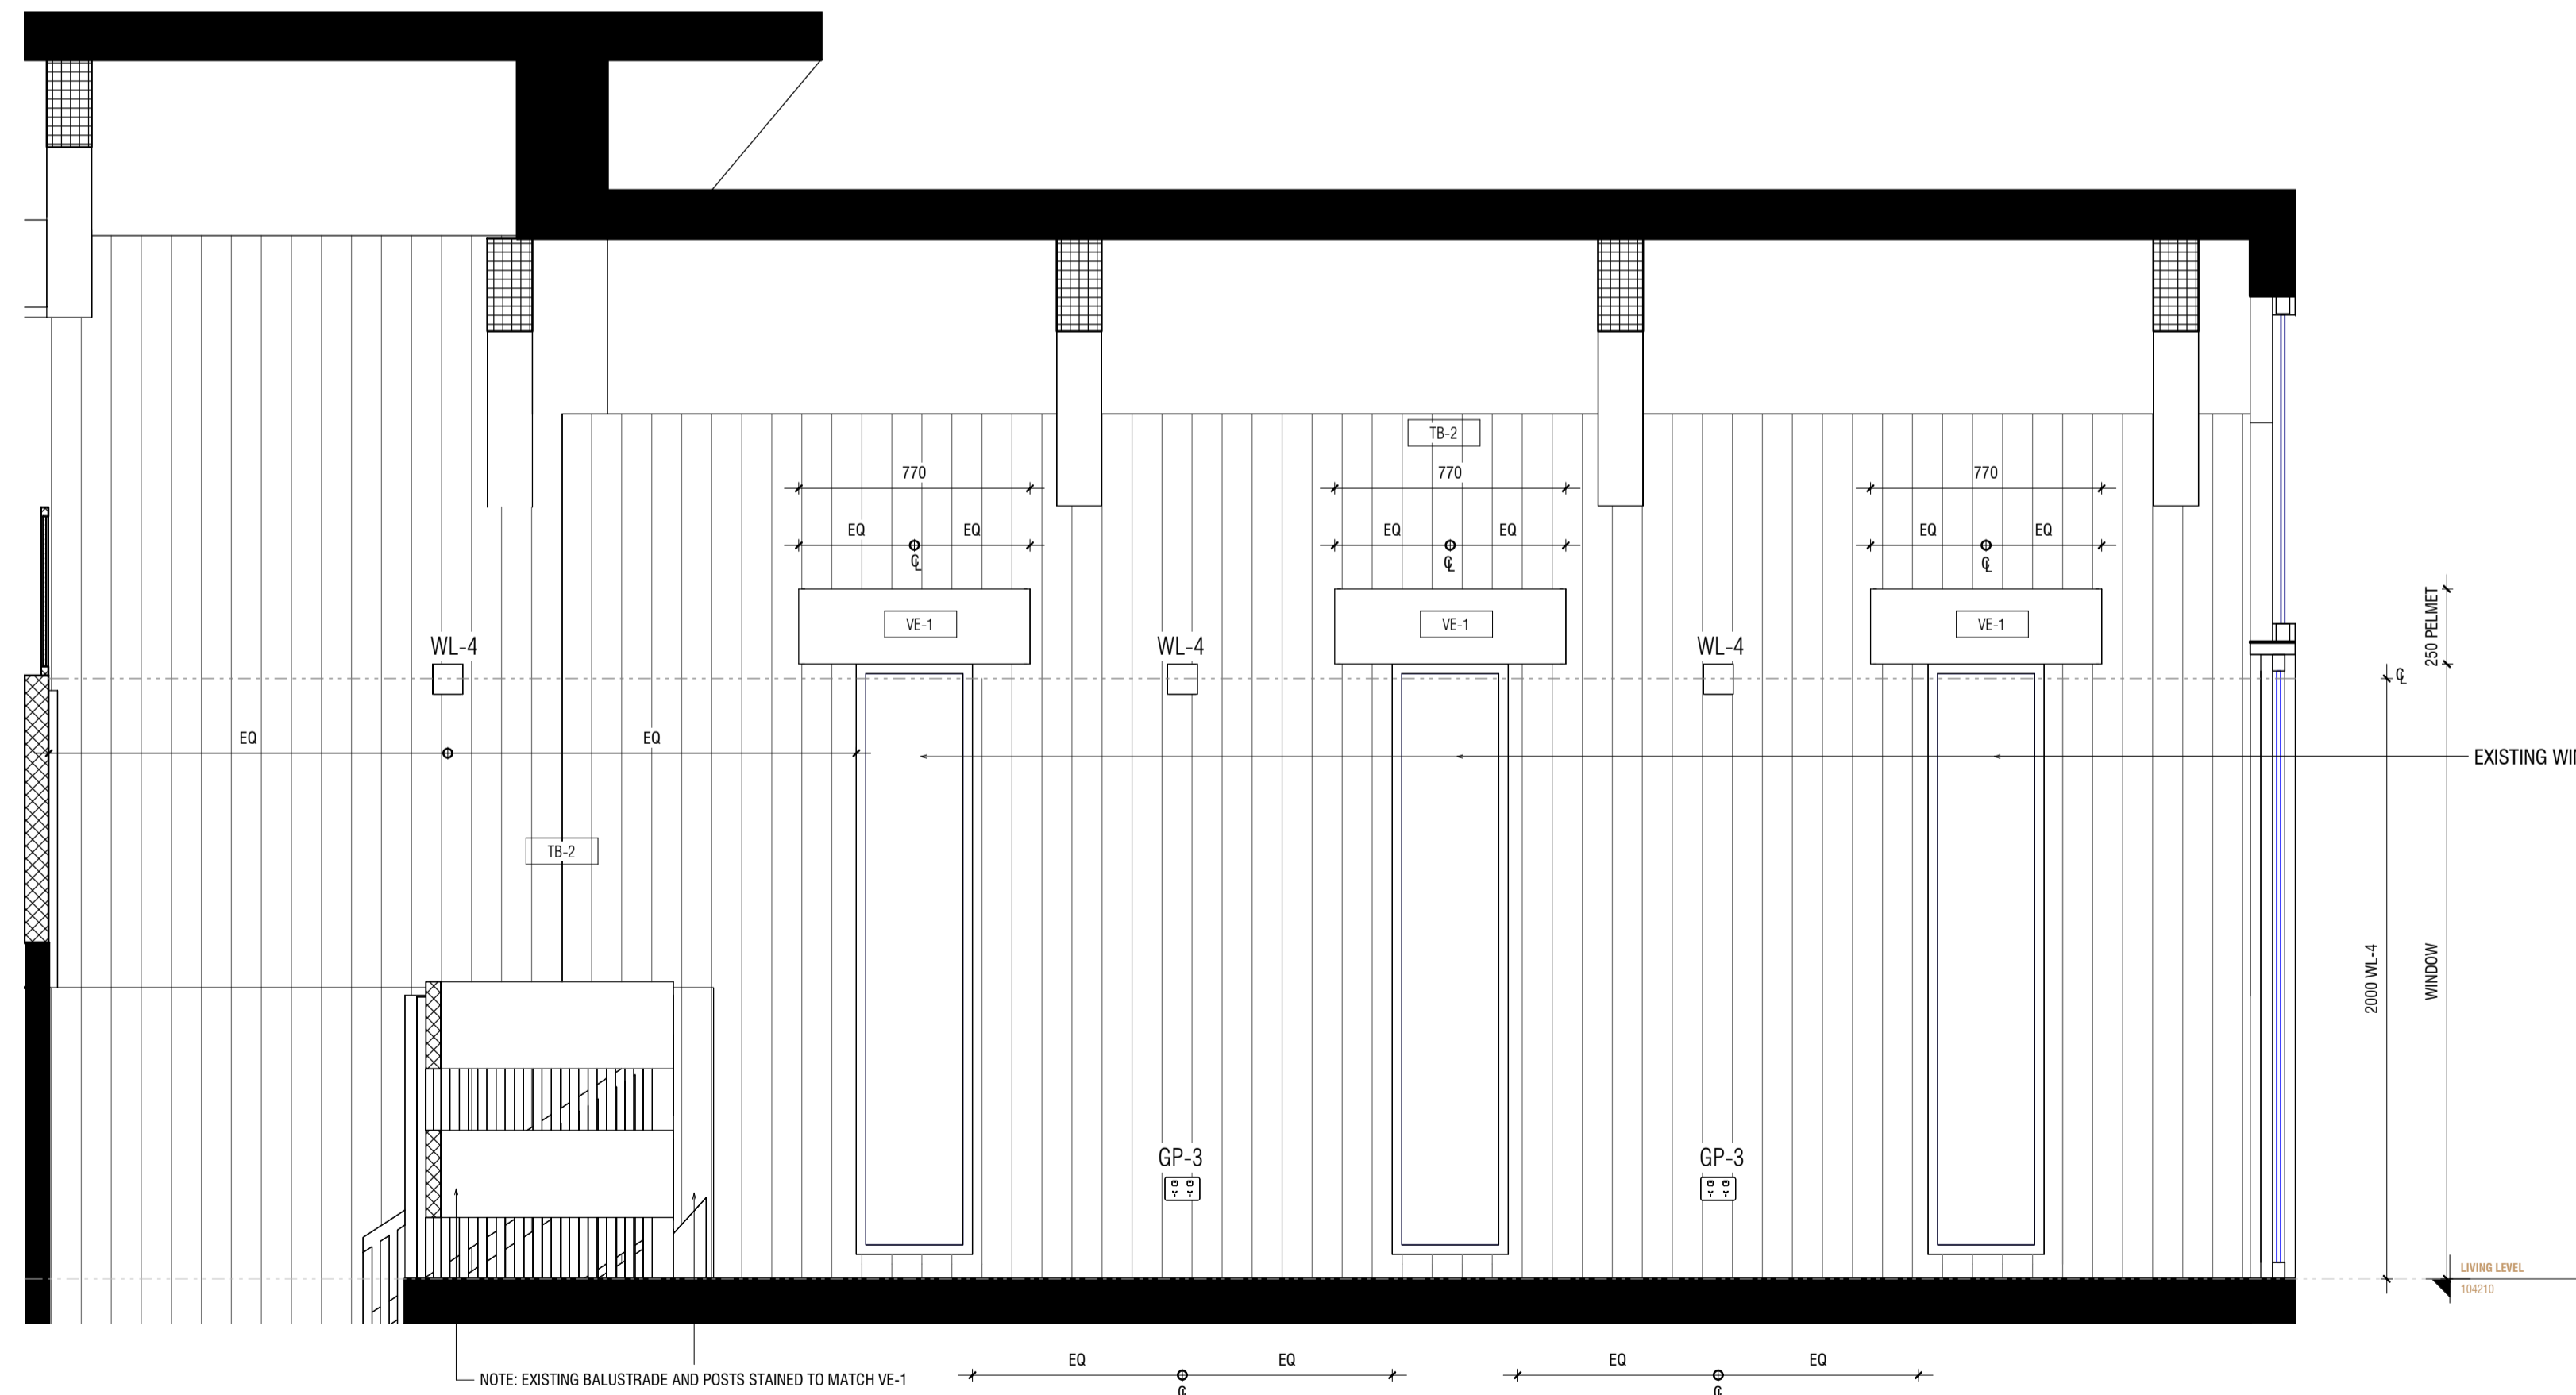

2 INT-5.02 ELEVATION 2
1 : 20

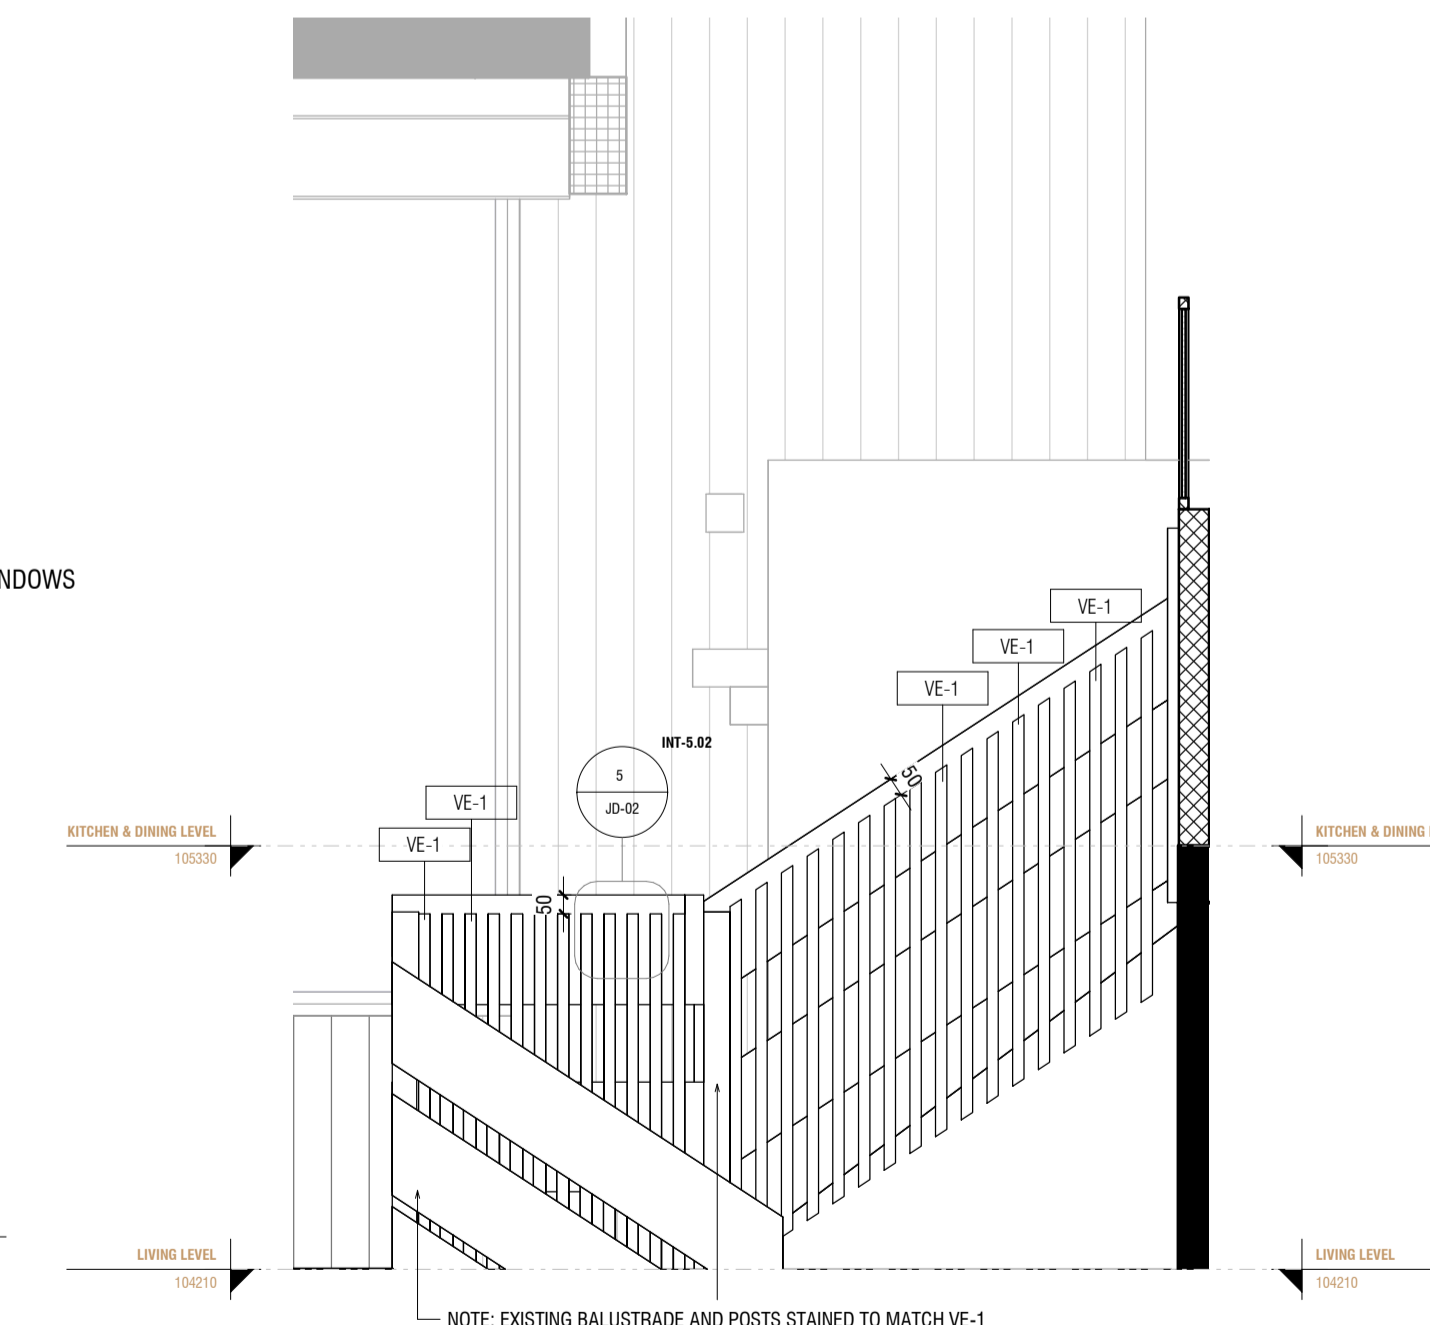


3 INT-5.02 ELEVATION 3
1 : 20

JOINERY

AS	ADJUSTABLE SHELF
AL	ALIGN
BAL	BALANCE
BS	BIFOLD SLIDING
CL	CENTRE LINE
DA	DOOR ACTIVATED
DLFH	BLUM DRAWER LEGRABOX FREE HIGH - 177 MM
DLFL	BLUM DRAWER LEGRABOX FREE LOW - 177 MM
DLPC	BLUM DRAWER LEGRABOX PURE C - 177 MM
DLPF	BLUM DRAWER LEGRABOX PURE F - 241 MM
DLPK	BLUM DRAWER LEGRABOX PURE K - 128.5 MM
DLPM	BLUM DRAWER LEGRABOX PURE M - 90.5 MM
DM	BLUM DRAWER MOVENTO (MELAMINE DRAWER BOX)
EQ	EQUAL
FS	FIXED SHELF
FP	FIXED PANNEL
HDB	HINGE DOOR - BLUM ONYX BLACK HINGES
HDN	HINGE DOOR - BLUM NICKEL PLATED HINGES
HF	HINGE FLAP
HR	HANGING RAIL
IAS	INTERNAL ADJUSTABLE SHELF
IDLFL	BLUM INTERNAL DRAWER LEGRABOX FREE HIGH - 177 MM
IDLFL	BLUM INTERNAL DRAWER LEGRABOX FREE LOW - 177 MM
IDLPC	BLUM INTERNAL DRAWER LEGRABOX PURE C - 177 MM
IDLPF	BLUM INTERNAL DRAWER LEGRABOX PURE F - 241 MM
IDLPK	BLUM INTERNAL DRAWER LEGRABOX PURE K - 128.5 MM
IDLPM	BLUM INTERNAL DRAWER LEGRABOX PURE M - 90.5 MM
IDM	BLUM INTERNAL DRAWER MOVENTO (MELAMINE DRAWER BOX)
IFS	INTERNAL FIXED SHELF
IHDB	INTERNAL HINGE DOOR - BLUM ONYX BLACK HINGES
IHDN	INTERNAL HINGE DOOR - BLUM NICKEL PLATED HINGES
IPAS	INTERNAL PULLOUT ANGLED SHOE SHELF
IPS	INTERNAL PULLOUT SHELF
IJ	MITRE JOIN
IS	PULLOUT SHELF
RD	RETRACTABLE DOOR
SL	SEAM LINE
SP	SLIDING PANEL
STSM	SUBJECT TO SITE MEASURE
STAS	SUBJECT TO APPLIANCE SPECS
Ⓟ	BI-FOLD OPERATION
Ⓡ	FINGER GRIP OPERATION WITH BLUMOTION
Ⓢ	MANUAL OPERATION WITH BLUMOTION
Ⓣ	PUSH TOUCH OPERATION WITH BLUM TIP ON FOR DOORS
Ⓤ	TIP ON OPERATION WITH BLUMOTION FOR DRAWERS
Ⓦ	SERVO-DRIVE OPERATION - BLUM
Ⓧ	AMBIALINE - BLUM INNER DIVIDER SYSTEM - LEGRABOX
Ⓨ	ORGALINE - BLUM INNER DIVIDER SYSTEM - MOVENTO

SCALE BAR

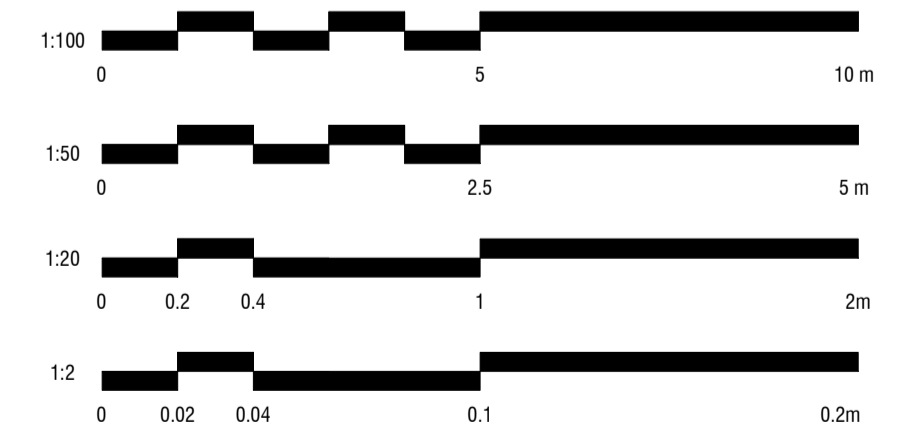

ALL MEASUREMENTS TO BE CHECKED BY TRADES ONSITE*

CHRISTOPHER
ELLIOTT


CHRISTOPHER ELLIOTT DESIGN PTY LTD
ABN 33131218650 ACN 131218650
T +61 (03)9077 8133 M +61 (0)403 653 649
INFO@CHRISTOPHERELLIOTTDESIGN.COM.AU
PO BOX 124 PRAHRAN 3181 VICTORIA AUSTRALIA

CLIENT AUSTRALIAN ALPINE CLUB
PROJECT ALPINE ROAD, HOTHAM HEIGHTS VIC 3741

All rights reserved. This document remains the property of Christopher Elliott Design Pty Ltd and is only to be used for its commissioned purpose. No part of this document may be reproduced, modified or transmitted in any form or by any means without the explicit written authority of Christopher Elliott Design Pty Ltd. Unauthorised use of this document in any form whatsoever is prohibited.


TITLE LIVING
SCALE @ A1 AS INDICATED
CHECKED BY CE
SHEET INT-5.02

PLOT DATE 05.06.20
DRAWN BY CA
REVISION A

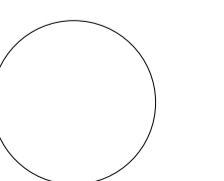


REVISION STATUS


REV.	DESCRIPTION	DATE
A	REVISION #3 CONSTRUCTION DOCS ISSUED	05.06.20

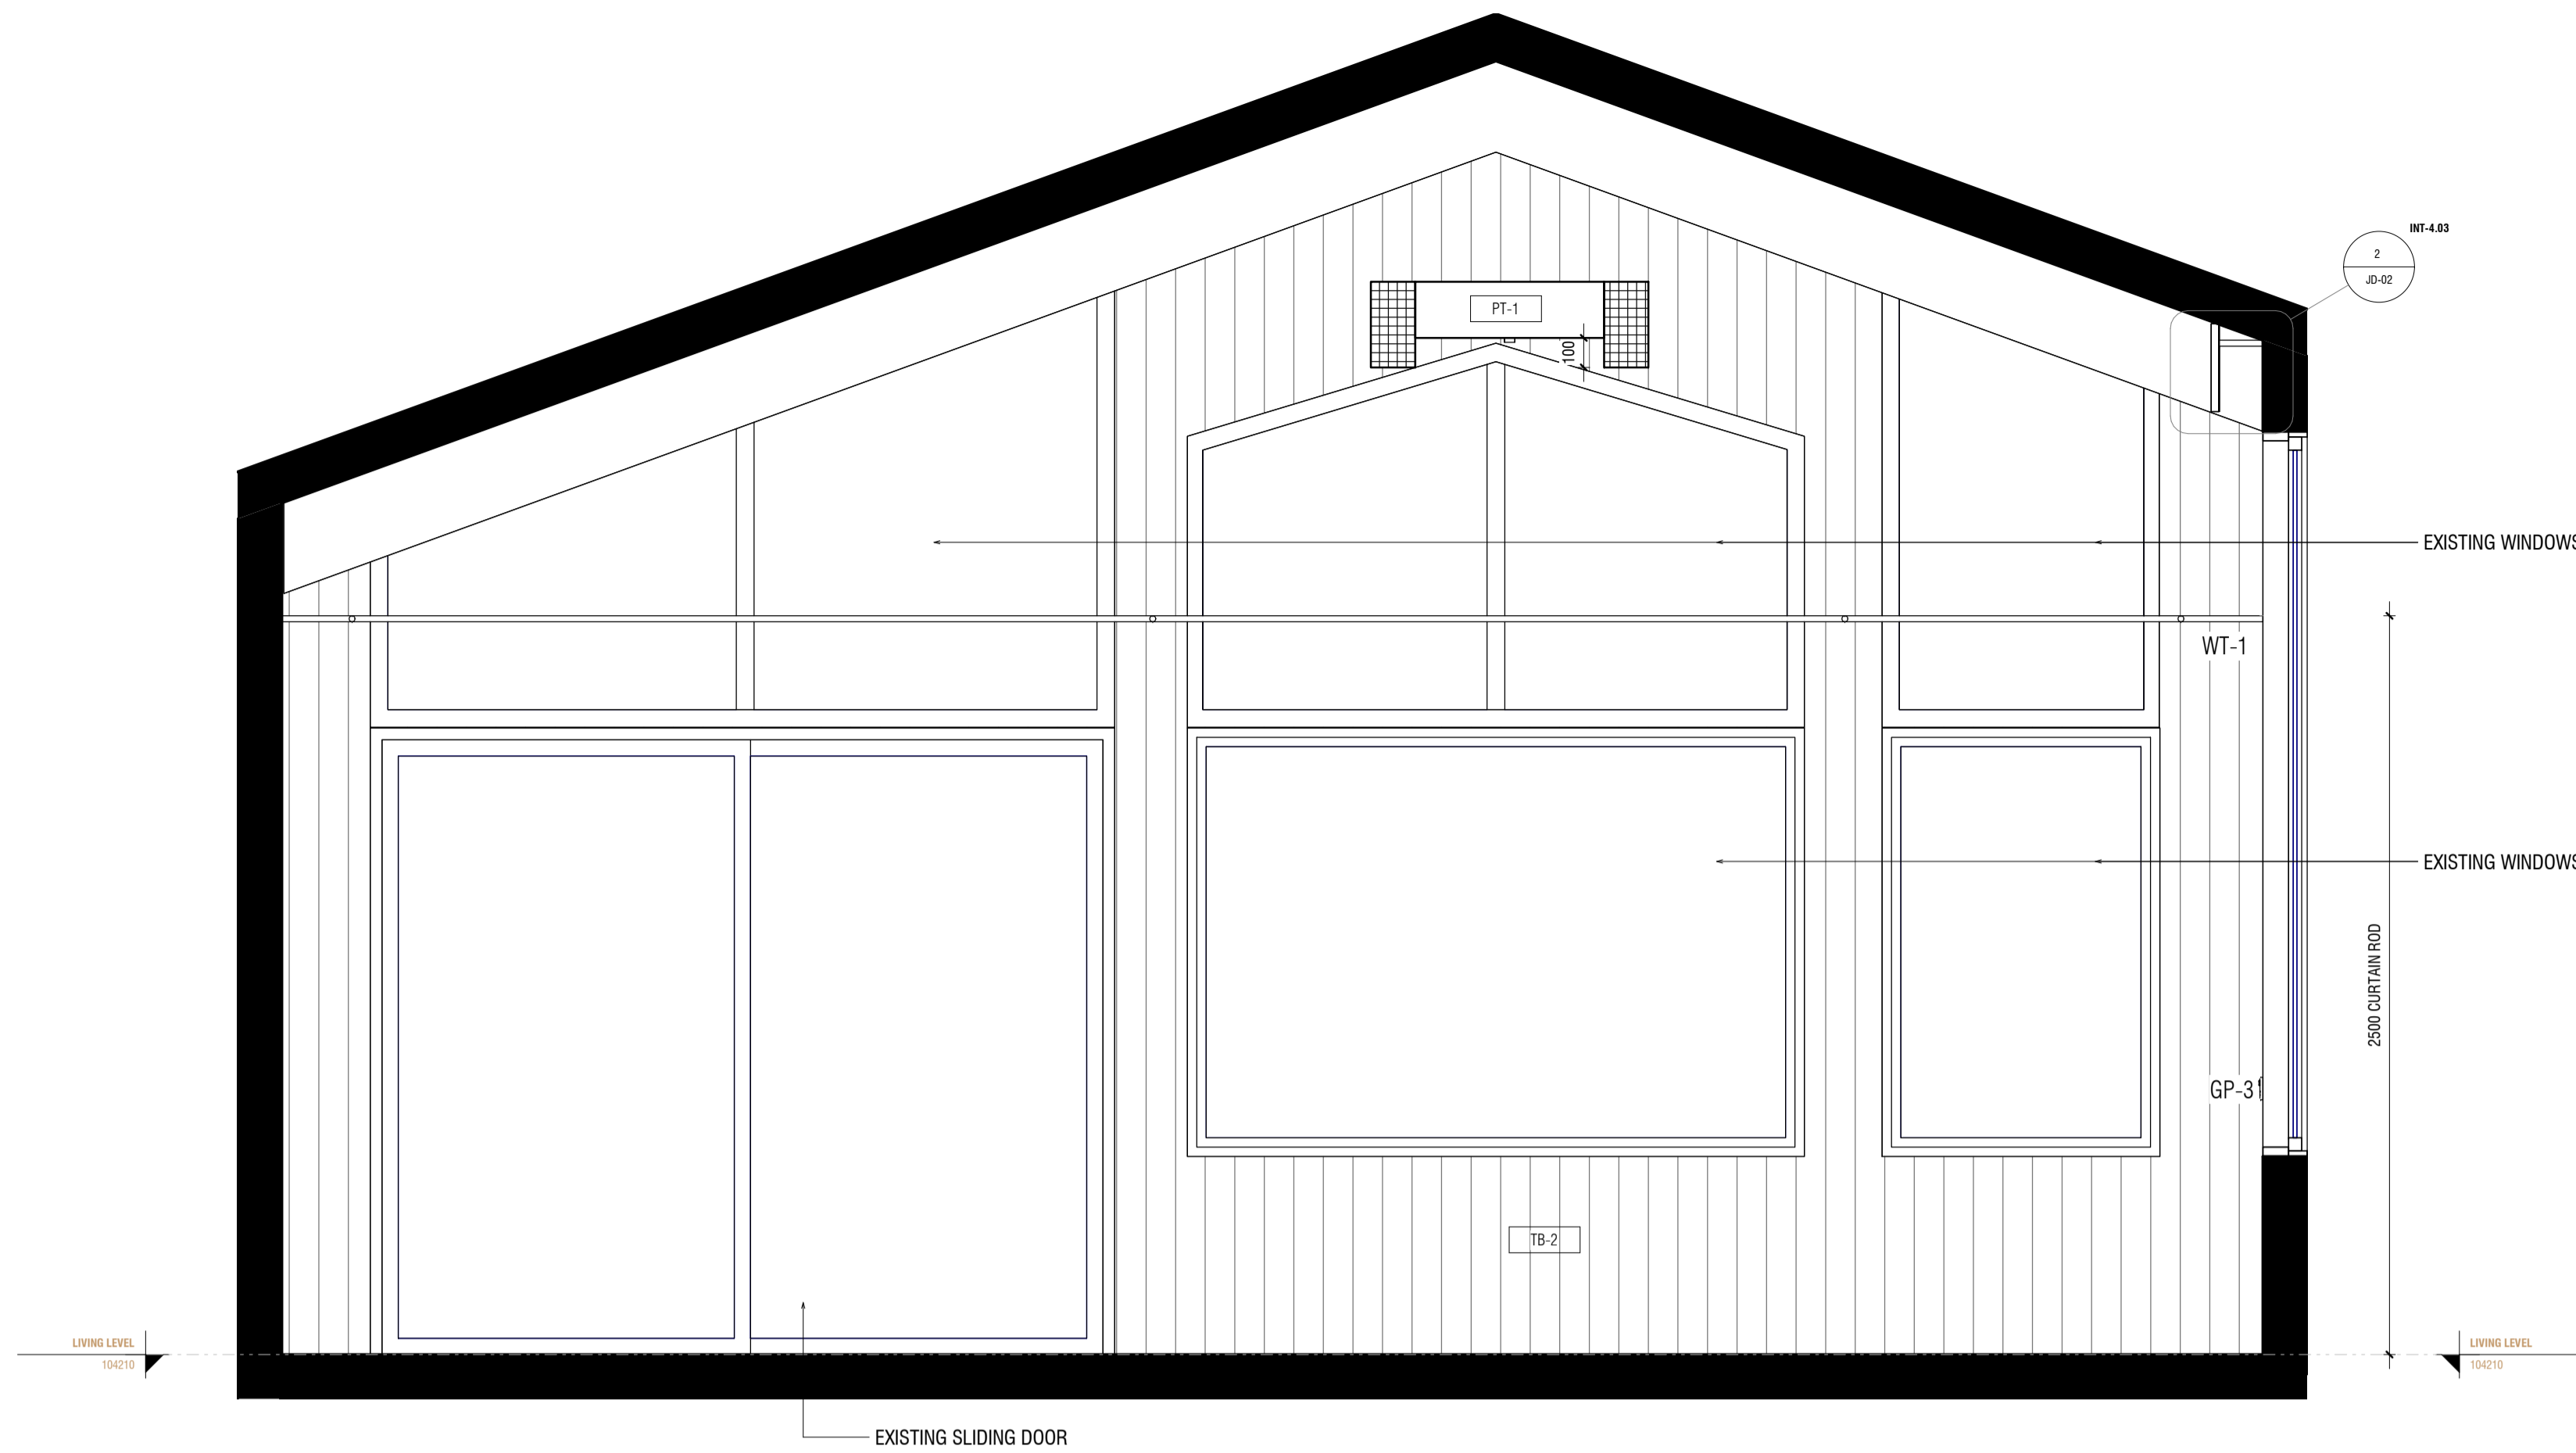

1 INT-5.03 ELEVATION 1
1:20

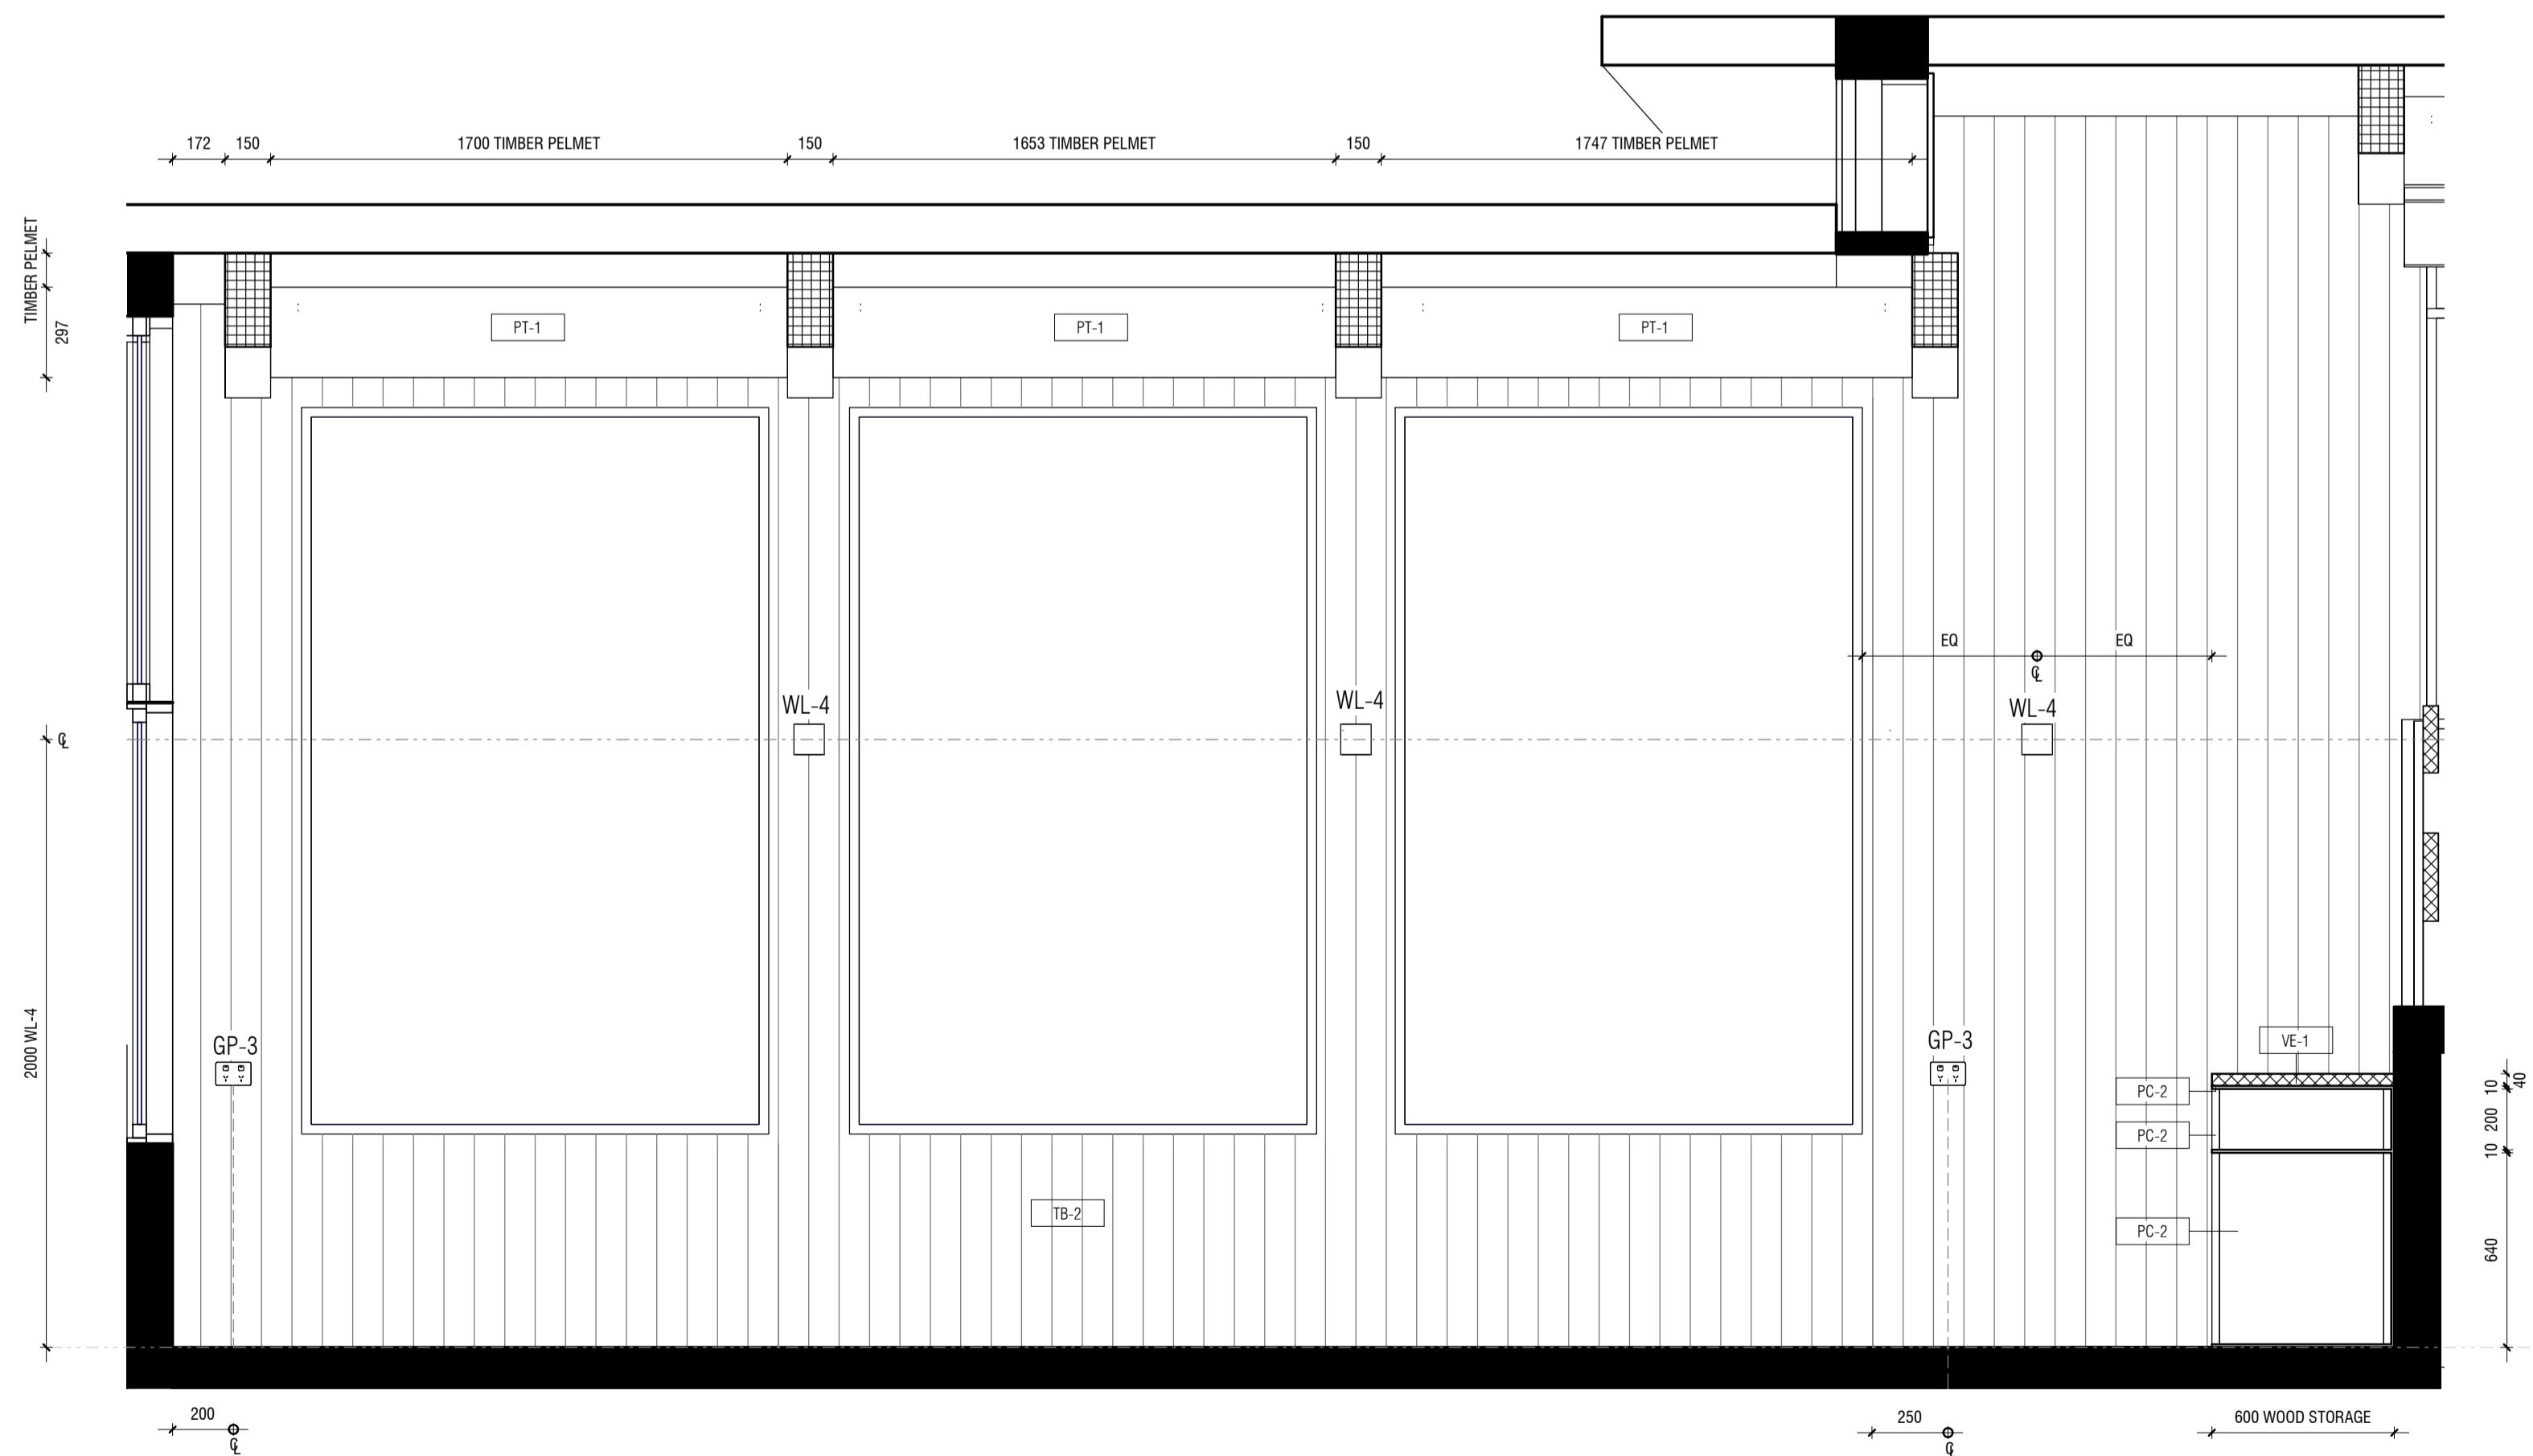

2 INT-5.03 ELEVATION 2
1:20

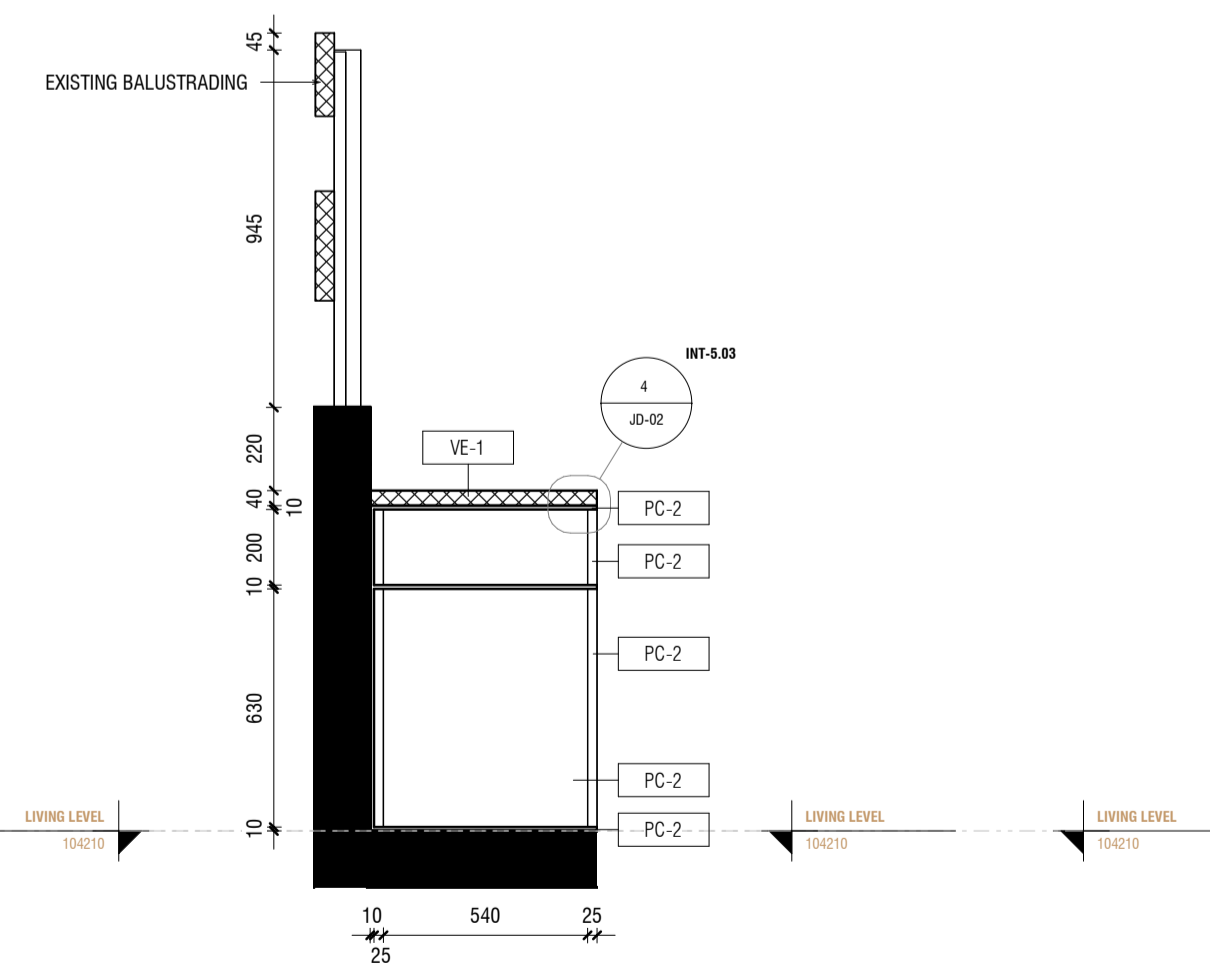


3 INT-5.03 SECTION 1
1:20

JOINERY

AS	ADJUSTABLE SHELF
AL	ALIGN
BAL	BALANCE
BS	BIFOLD SLIDING
CL	CENTRE LINE
DA	DOOR ACTIVATED
DLFH	BLUM DRAWER LEGRABOX FREE HIGH - 177 MM
DLFL	BLUM DRAWER LEGRABOX FREE LOW - 177 MM
DLPC	BLUM DRAWER LEGRABOX PURE C - 177 MM
DLPF	BLUM DRAWER LEGRABOX PURE F - 241 MM
DLPK	BLUM DRAWER LEGRABOX PURE K - 128.5 MM
DLPM	BLUM DRAWER LEGRABOX PURE M - 90.5 MM
DM	BLUM DRAWER MOVENTO (MELAMINE DRAWER BOX)
EQ	EQUAL
FS	FIXED SHELF
FP	FIXED PANNEL
HDB	HINGE DOOR - BLUM ONYX BLACK HINGES
HDN	HINGE DOOR - BLUM NICKEL PLATED HINGES
HF	HINGE FLAP
HR	HANGING RAIL
IAS	INTERNAL ADJUSTABLE SHELF
IDLFH	BLUM INTERNAL DRAWER LEGRABOX FREE HIGH - 177 MM
IDFL	BLUM INTERNAL DRAWER LEGRABOX FREE LOW - 177 MM
IDLPC	BLUM INTERNAL DRAWER LEGRABOX PURE C - 177 MM
IDLPF	BLUM INTERNAL DRAWER LEGRABOX PURE F - 241 MM
IDLPK	BLUM INTERNAL DRAWER LEGRABOX PURE K - 128.5 MM
IDLPM	BLUM INTERNAL DRAWER LEGRABOX PURE M - 90.5 MM
IDM	BLUM INTERNAL DRAWER MOVENTO (MELAMINE DRAWER BOX)
IFS	INTERNAL FIXED SHELF
IHDB	INTERNAL HINGE DOOR - BLUM ONYX BLACK HINGES
IHDN	INTERNAL HINGE DOOR - BLUM NICKEL PLATED HINGES
IPAS	INTERNAL PULLOUT ANGLED SHOE SHELF
IPS	INTERNAL PULLOUT SHELF
IJ	MITRE JOIN
IS	PULLOUT SHELF
RD	RETRACTABLE DOOR
SL	SEAM LINE
SP	SLIDING PANEL
STSM	SUBJECT TO SITE MEASURE
STAS	SUBJECT TO APPLIANCE SPECS

Ⓟ	BI-FOLD OPERATION
Ⓡ	FINGER GRIP OPERATION WITH BLUMOTION
Ⓜ	MANUAL OPERATION WITH BLUMOTION
Ⓟ	PUSH TOUCH OPERATION WITH BLUM TIP ON FOR DOORS
Ⓡ	TIP ON OPERATION WITH BLUMOTION FOR DRAWERS
Ⓢ	SERVO-DRIVE OPERATION - BLUM
Ⓜ	AMBIALINE - BLUM INNER DIVIDER SYSTEM - LEGRABOX
Ⓞ	ORGALINE - BLUM INNER DIVIDER SYSTEM - MOVENTO

SCALE BAR

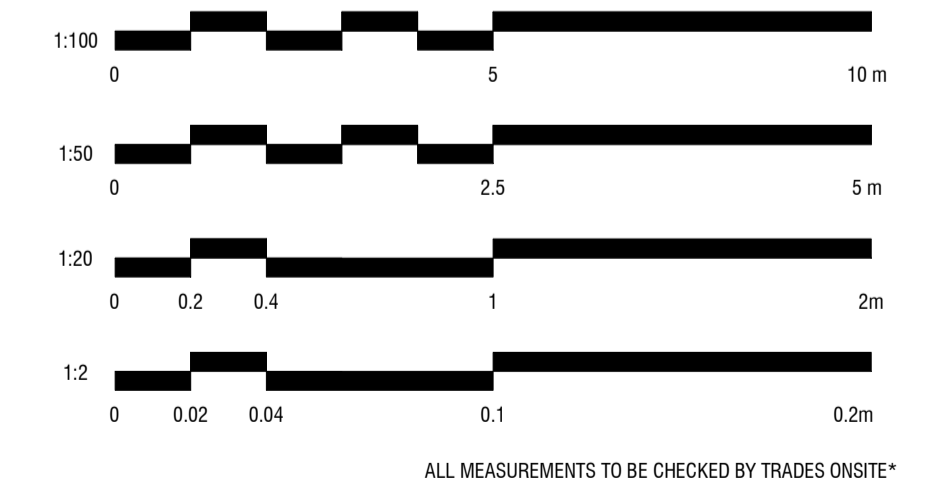

ALL MEASUREMENTS TO BE CHECKED BY TRADES ONSITE

CHRISTOPHER
ELLIOTT


CHRISTOPHER ELLIOTT DESIGN PTY LTD
ABN 33131218650 ACN 131218650
T+61 (03)9077 8133 M +61 (0)403 653 649
INFO@CHRISTOPHERELLIOTTDESIGN.COM.AU
PO BOX 124 PRAHRAN 3181 VICTORIA AUSTRALIA

CLIENT AUSTRALIAN ALPINE CLUB
PROJECT ALPINE ROAD, HOTHAM HEIGHTS VIC 3741

All rights reserved. This document remains the property of Christopher Elliott Design Pty Ltd and is only to be used for its commissioned purpose. No part of this document may be reproduced, modified or transmitted in any form or by any means without the explicit written authority of Christopher Elliott Design Pty Ltd. Unauthorised use of this document in any form whatsoever is prohibited.

TITLE LIVING
SCALE @ A1 AS INDICATED
CHECKED BY CE
SHEET INT-5.03

PLOT DATE 05.06.20
DRAWN BY CA
REVISION A

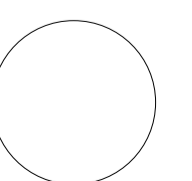


REVISION STATUS

REV.	DESCRIPTION	DATE
A	REVISION #3 CONSTRUCTION DOCS ISSUED	05.06.20


JOINERY

AS	ADJUSTABLE SHELF
AL	ALIGN
BAL	BALANCE
BS	BIFOLD SLIDING
CL	CENTRE LINE
DA	DOOR ACTIVATED
DLFH	BLUM DRAWER LEGRABOX FREE HIGH - 177 MM
DLFL	BLUM DRAWER LEGRABOX FREE LOW - 177 MM
DLPC	BLUM DRAWER LEGRABOX PURE C - 177 MM
DLPF	BLUM DRAWER LEGRABOX PURE F - 241 MM
DLPK	BLUM DRAWER LEGRABOX PURE K - 128.5 MM
DLPM	BLUM DRAWER LEGRABOX PURE M - 90.5 MM
DM	BLUM DRAWER MOVENTO (MELAMINE DRAWER BOX)
EQ	EQUAL
FS	FIXED SHELF
FP	FIXED PANNEL
HDB	HINGE DOOR - BLUM ONYX BLACK HINGES
HDN	HINGE DOOR - BLUM NICKEL PLATED HINGES
HF	HINGE FLAP
HR	HANGING RAIL
IAS	INTERNAL ADJUSTABLE SHELF
IDLH	BLUM INTERNAL DRAWER LEGRABOX FREE HIGH - 177 MM
IDLFL	BLUM INTERNAL DRAWER LEGRABOX FREE LOW - 177 MM
IDLPC	BLUM INTERNAL DRAWER LEGRABOX PURE C - 177 MM
IDLPF	BLUM INTERNAL DRAWER LEGRABOX PURE F - 241 MM
IDLPK	BLUM INTERNAL DRAWER LEGRABOX PURE K - 128.5 MM
IDLPM	BLUM INTERNAL DRAWER LEGRABOX PURE M - 90.5 MM
IDM	BLUM INTERNAL DRAWER MOVENTO (MELAMINE DRAWER BOX)
IFS	INTERNAL FIXED SHELF
IHDB	INTERNAL HINGE DOOR - BLUM ONYX BLACK HINGES
IHDN	INTERNAL HINGE DOOR - BLUM NICKEL PLATED HINGES
IPAS	INTERNAL PULLOUT ANGLED SHOE SHELF
IPS	INTERNAL PULLOUT SHELF
IJ	MITRE JOIN
IS	PULLOUT SHELF
IS	RETRACTABLE DOOR
IS	SEAM LINE
IS	SLIDING PANEL
IS	SUBJECT TO SITE MEASURE
IS	SUBJECT TO APPLIANCE SPECS
Ⓟ	BI-FOLD OPERATION
Ⓡ	FINGER GRIP OPERATION WITH BLUMOTION
Ⓢ	MANUAL OPERATION WITH BLUMOTION
Ⓣ	PUSH TOUCH OPERATION WITH BLUM TIP ON FOR DOORS
Ⓤ	TIP ON OPERATION WITH BLUMOTION FOR DRAWERS
Ⓦ	SERVO-DRIVE OPERATION - BLUM
Ⓧ	AMBIALINE - BLUM INNER DIVIDER SYSTEM - LEGRABOX
Ⓨ	ORGALINE - BLUM INNER DIVIDER SYSTEM - MOVENTO

SCALE BAR

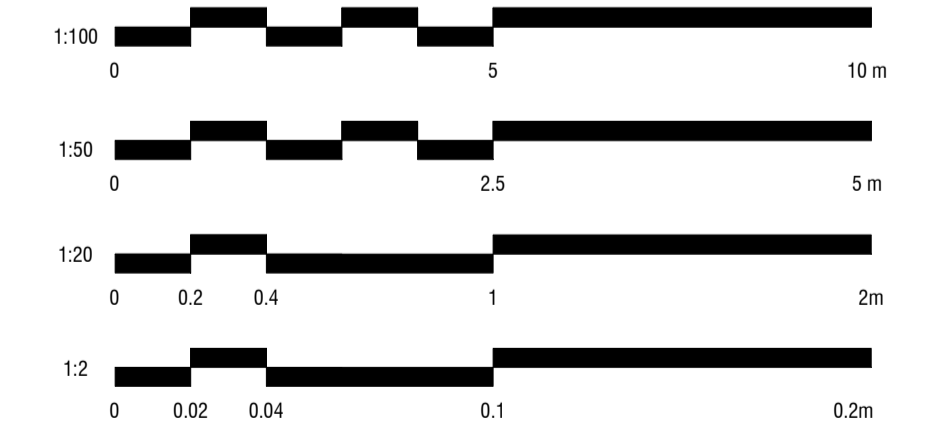

ALL MEASUREMENTS TO BE CHECKED BY TRADES ONSITE*

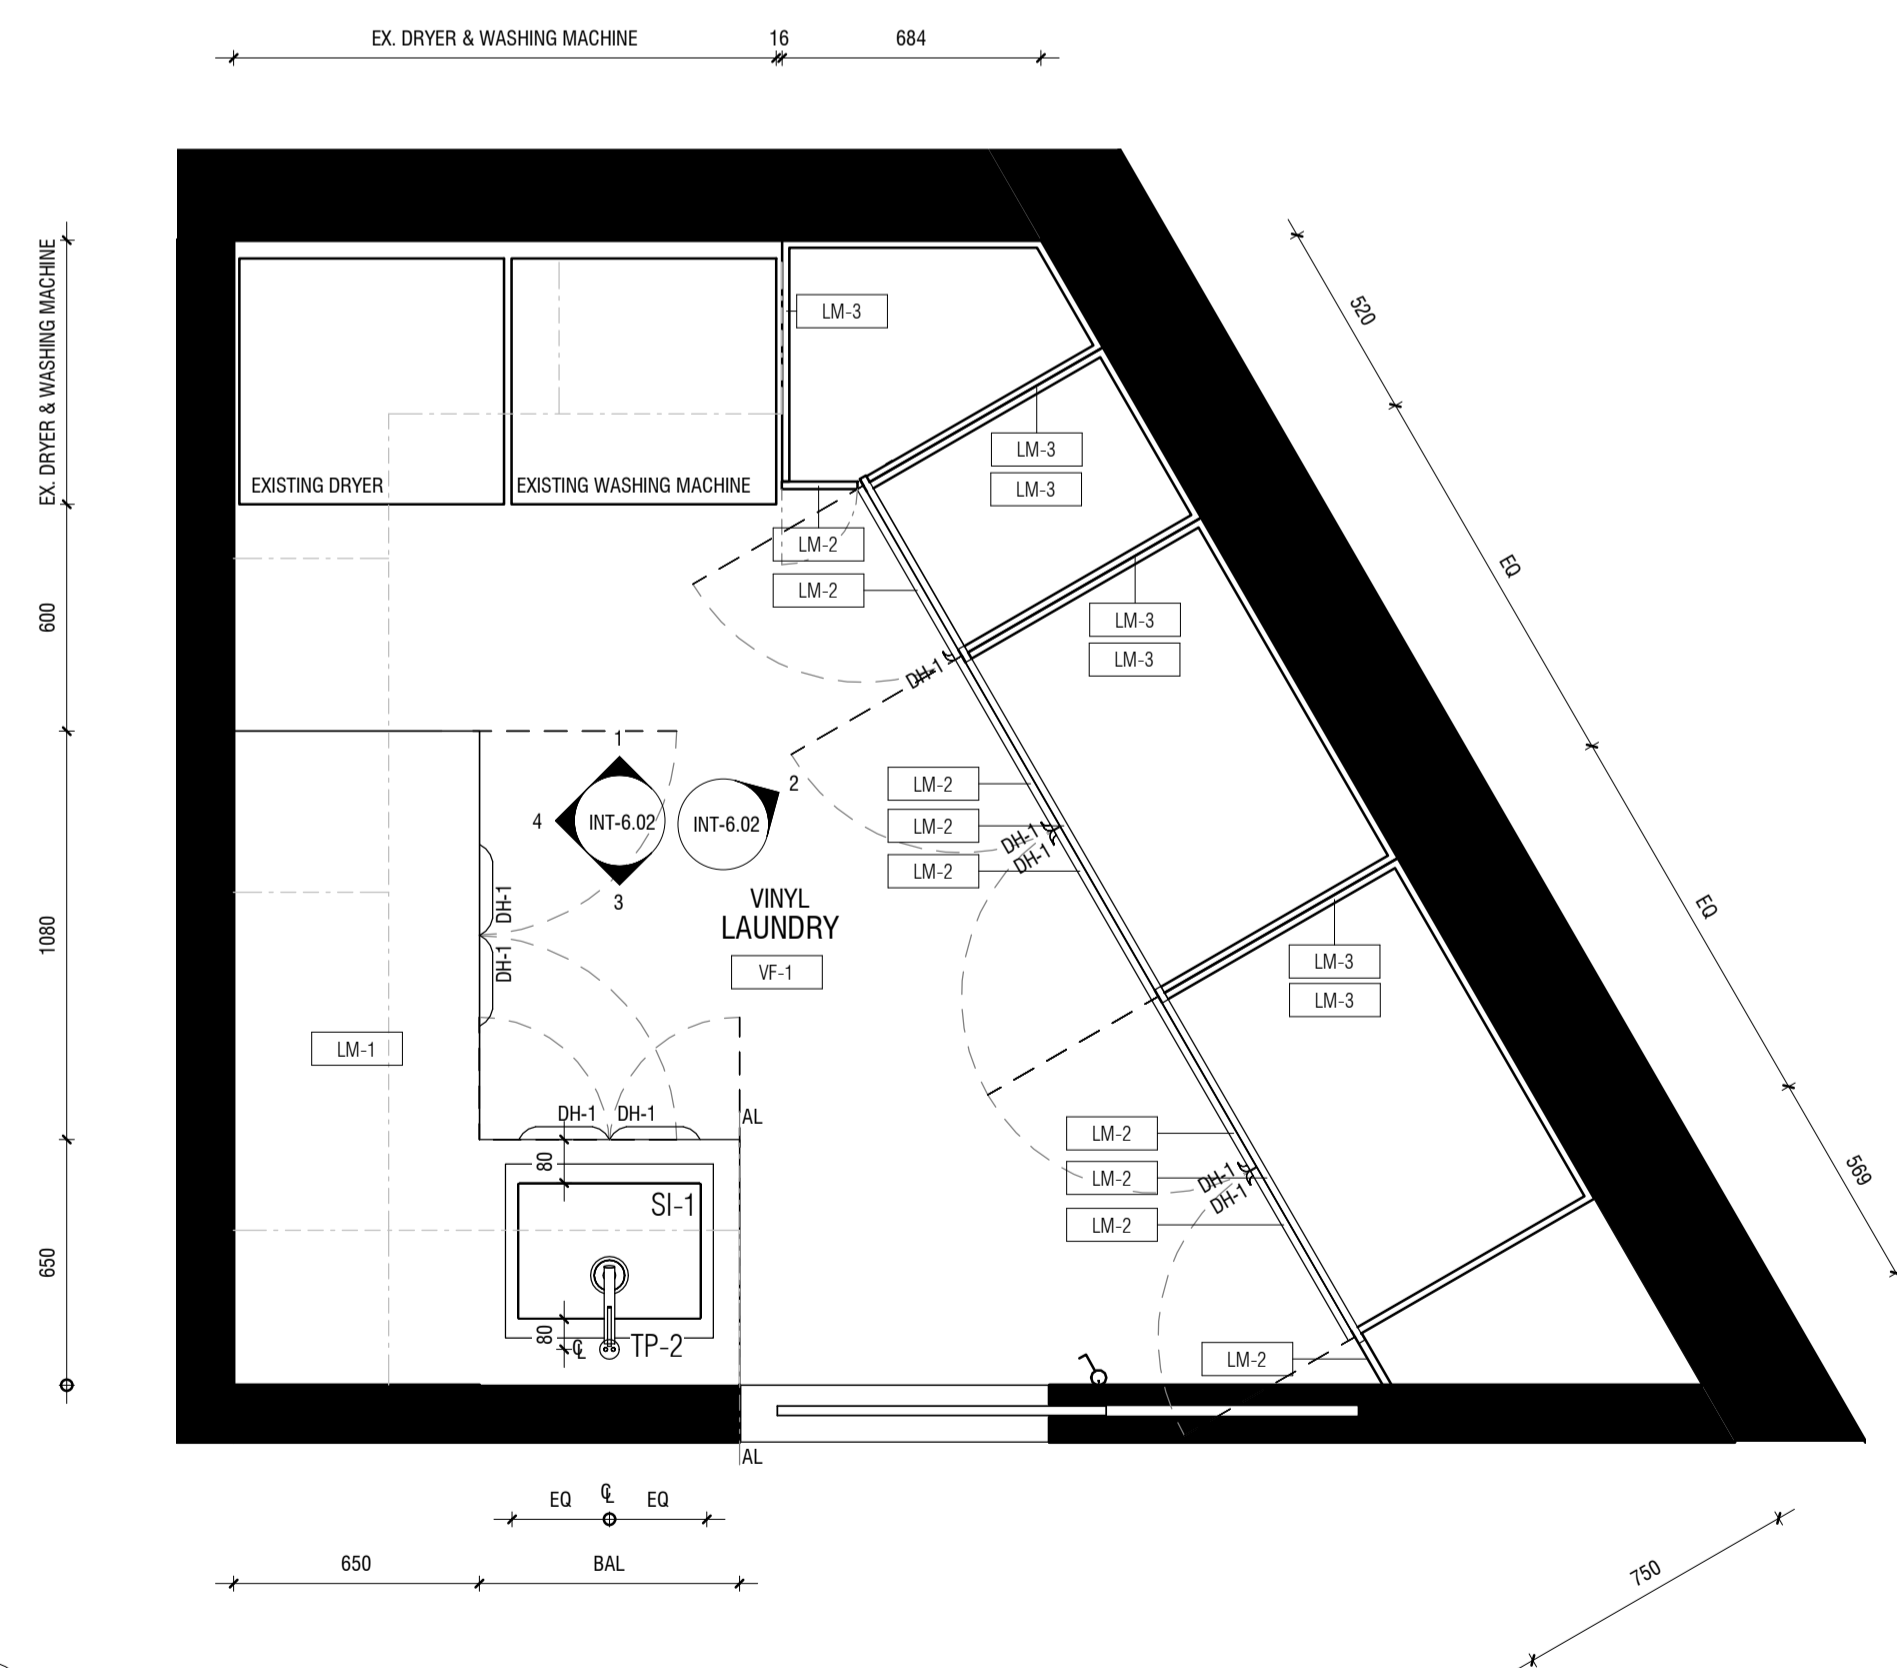

1 LAUNDRY FLOOR PLAN
1 : 20

CHRISTOPHER
ELLIOTT


CHRISTOPHER ELLIOTT DESIGN PTY LTD
ABN 33131218650 ACN 131218650
T +61 (0)3 9077 8133 M +61 (0)403 653 649
INFO@CHRISTOPHERELLIOTTDESIGN.COM.AU
PO BOX 124 PRAHRAN 3181 VICTORIA AUSTRALIA

CLIENT AUSTRALIAN ALPINE CLUB
PROJECT ALPINE ROAD, HOTHAM HEIGHTS VIC 3741

All rights reserved. This document remains the property of Christopher Elliott Design Pty Ltd and is only to be used for its commissioned purpose. No part of this document may be reproduced, modified or transmitted in any form or by any means without the explicit written authority of Christopher Elliott Design Pty Ltd. Unauthorised use of this document in any form whatsoever is prohibited.

TITLE LAUNDRY
SCALE @ A1 AS INDICATED
CHECKED BY CE
SHEET INT-6.01


PLOT DATE 05.06.20
DRAWN BY CA
REVISION A

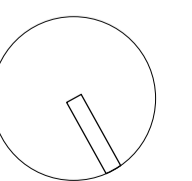


CONSTRUCTION ISSUE

REVISION STATUS


REV.	DESCRIPTION	DATE
A	REVISION #3 CONSTRUCTION DOCS ISSUED	05.06.20

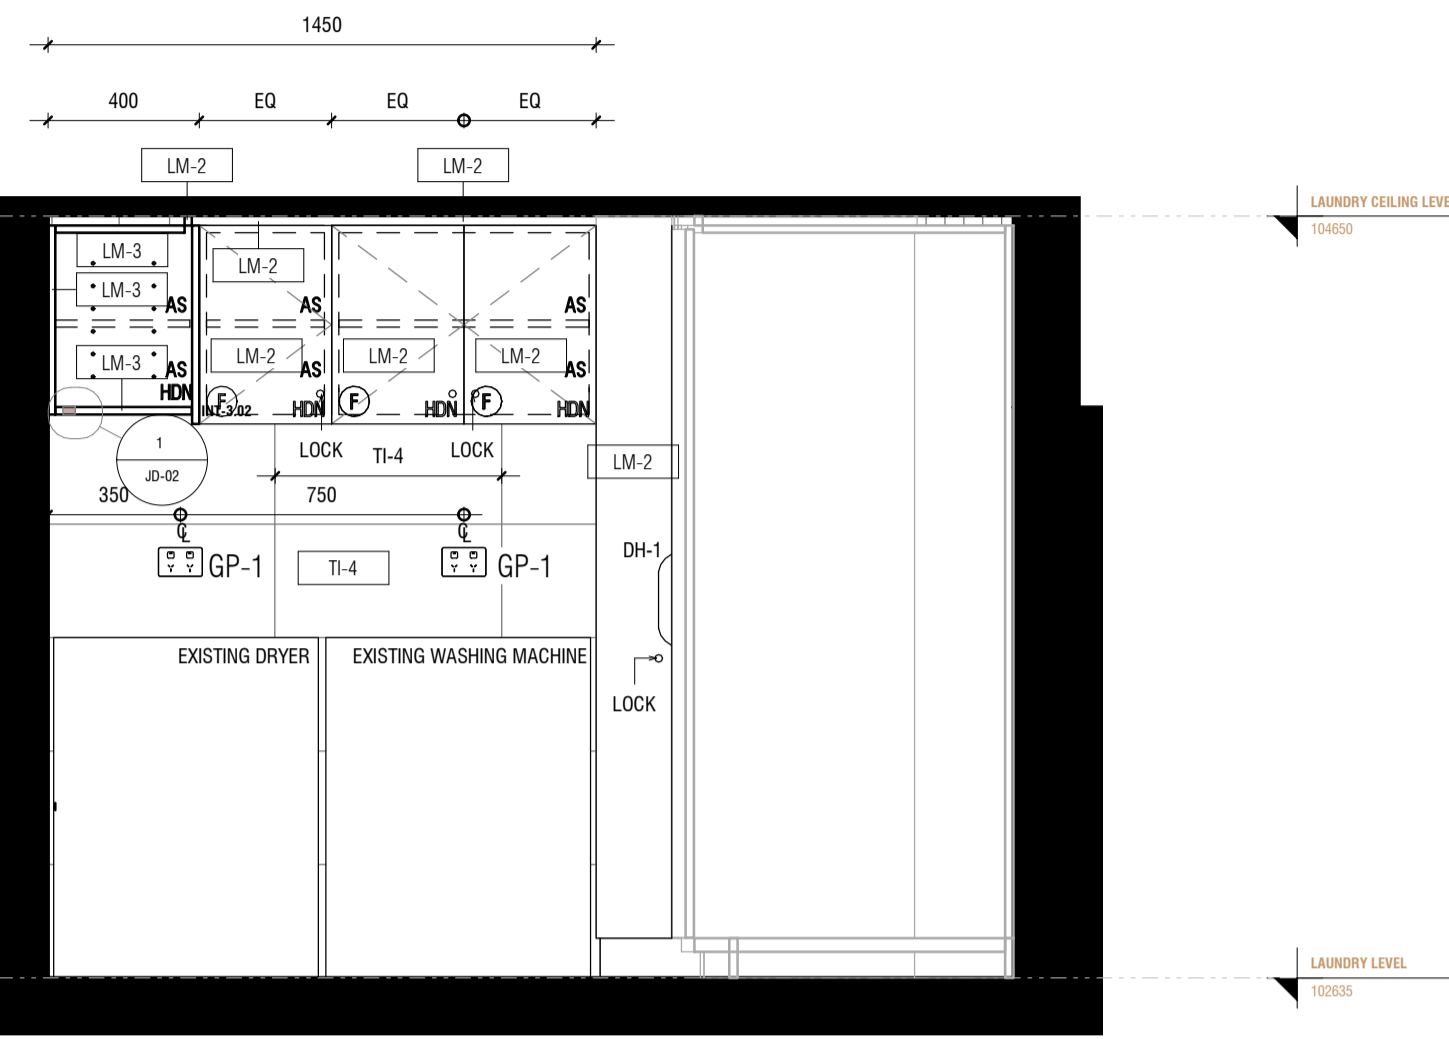


1 INT-6.02 ELEVATION 1
1 : 20

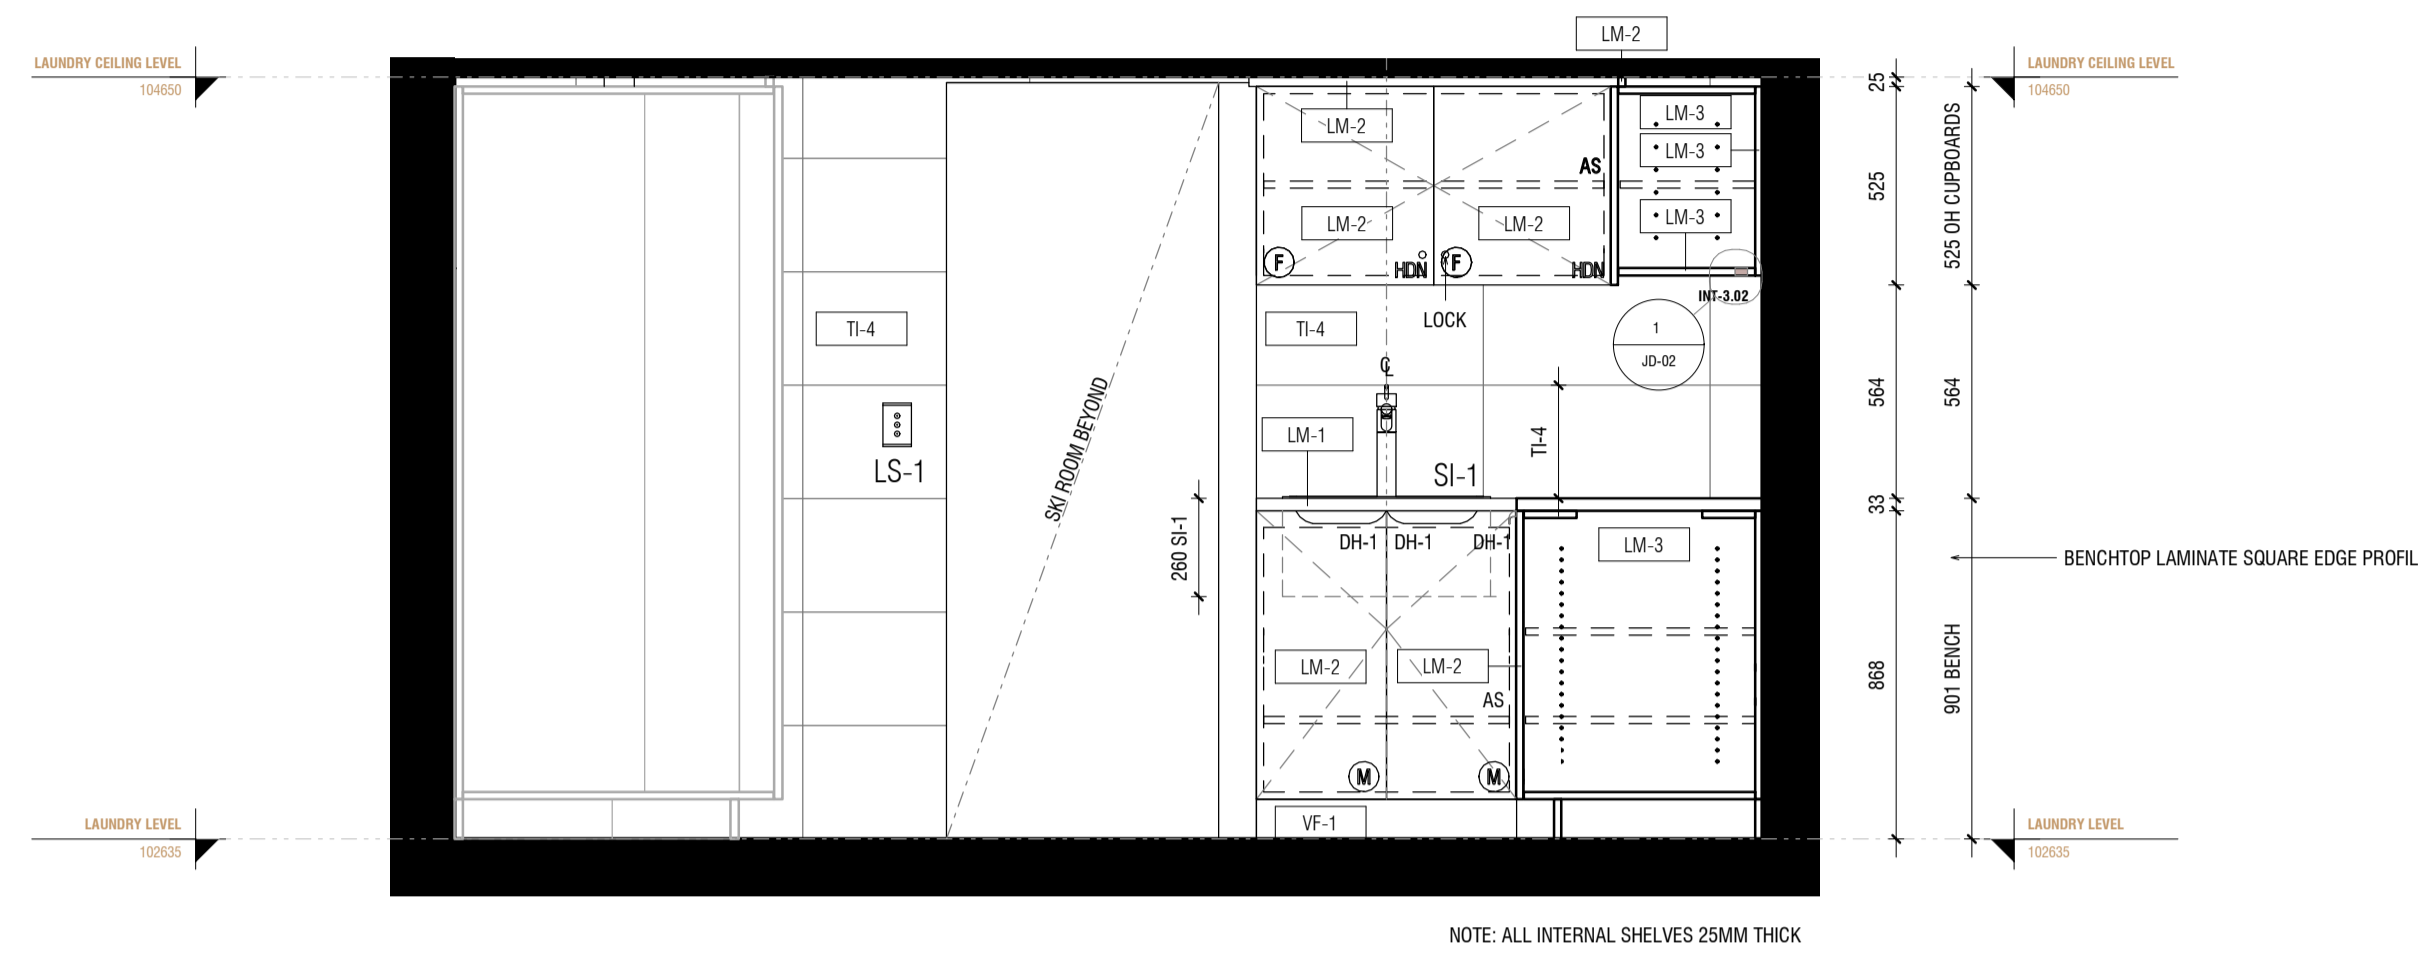

3 INT-6.02 ELEVATION 3
1 : 20

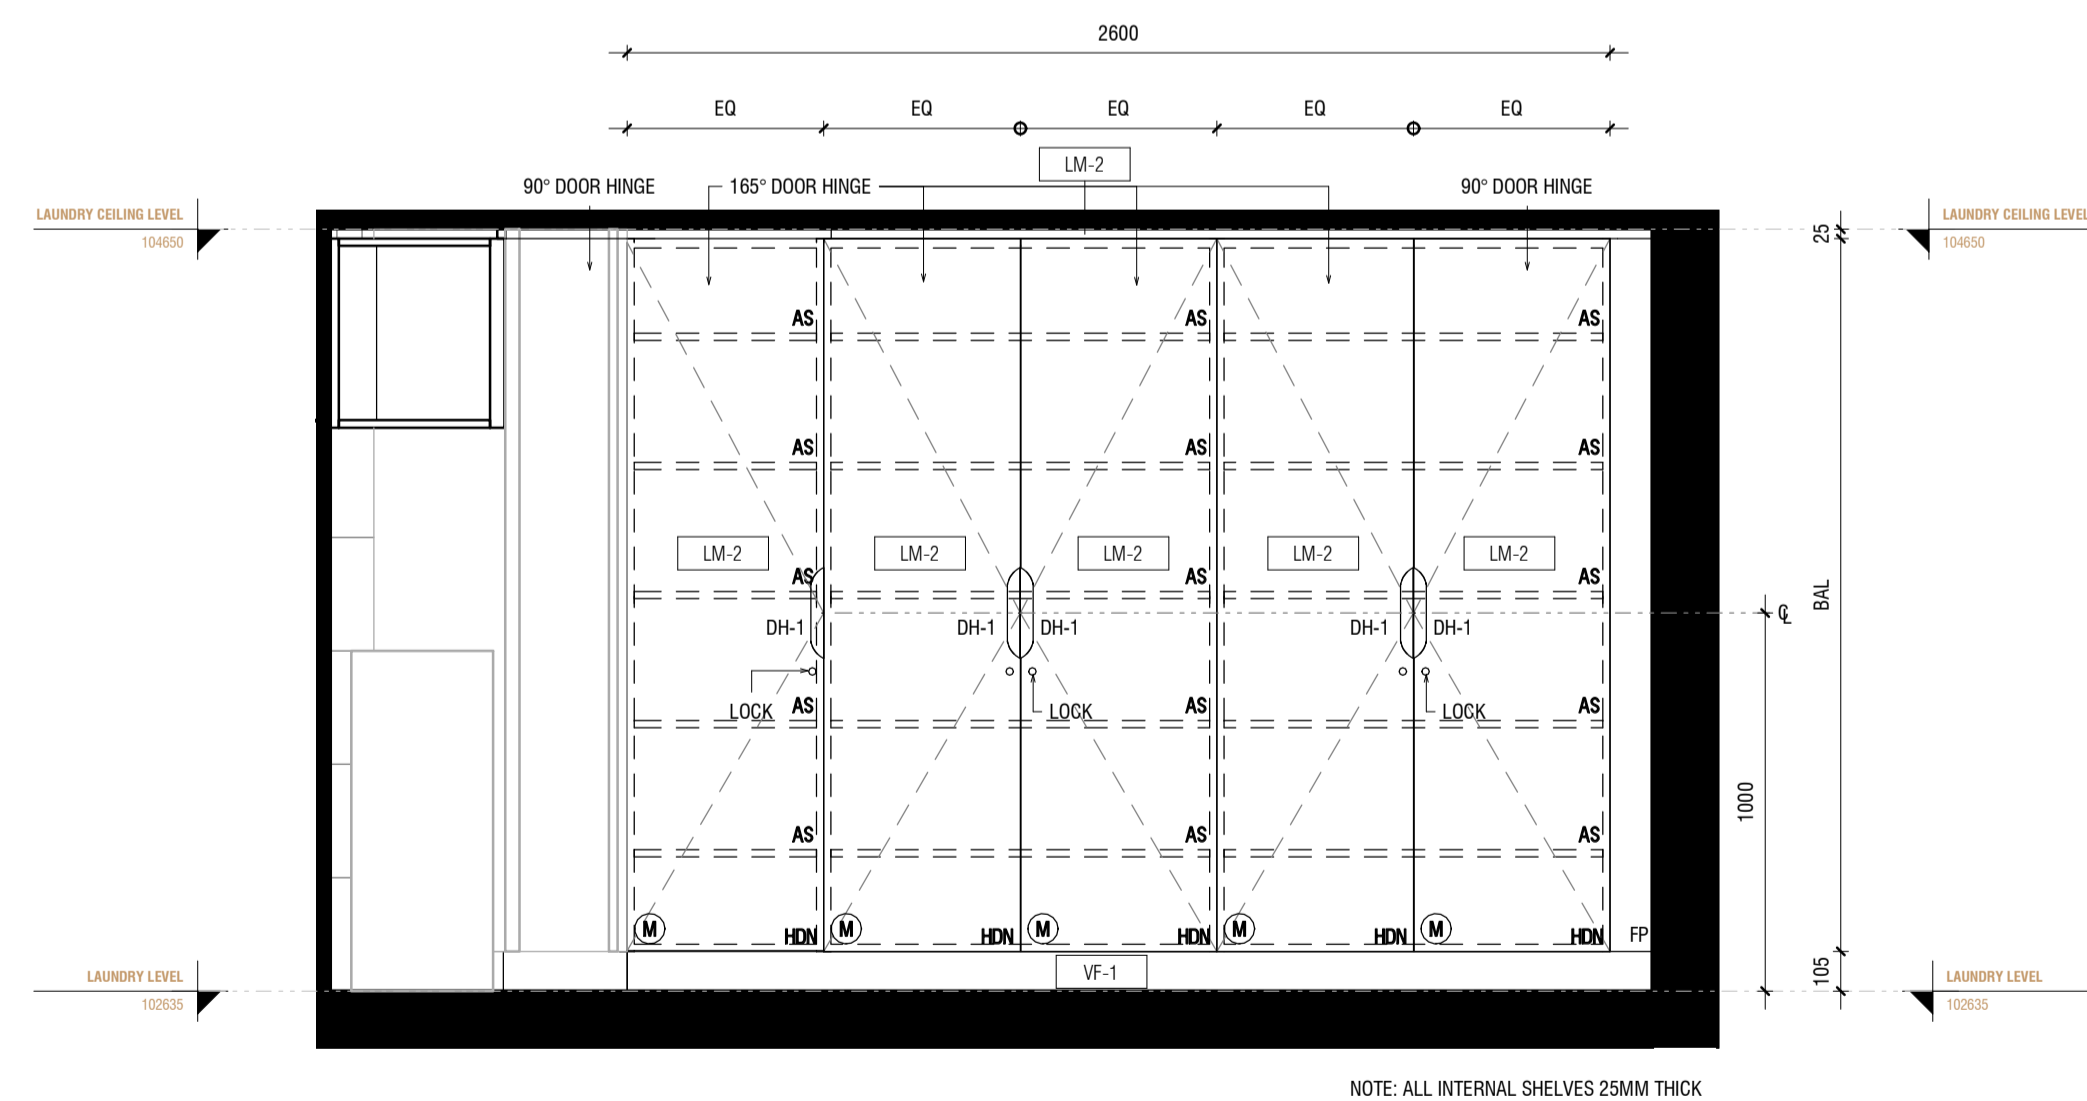

2 INT-6.02 ELEVATION 2
1 : 20

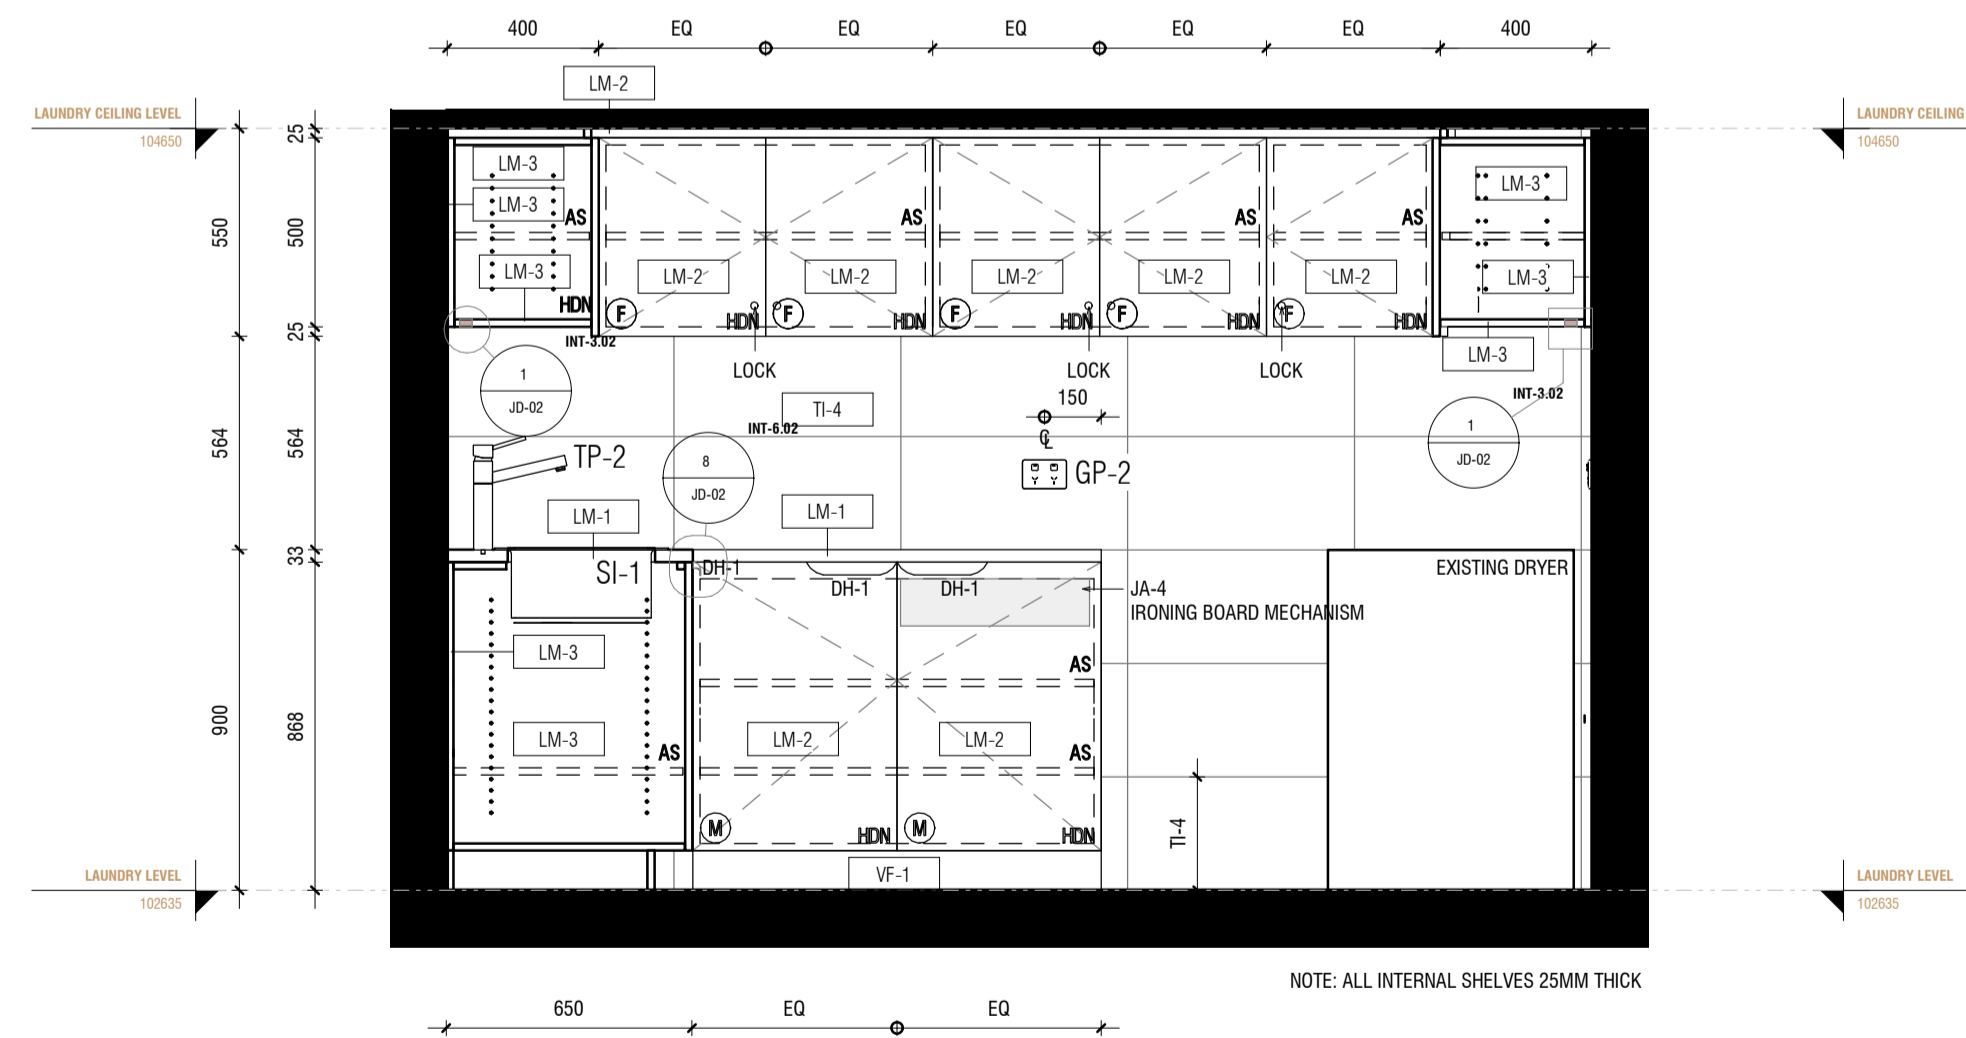


4 INT-6.02 ELEVATION 4
1 : 20

JOINERY

AS	ADJUSTABLE SHELF
AL	ALIGN
BAL	BALANCE
BS	BIFOLD SLIDING
CL	CENTRE LINE
DA	DOOR ACTIVATED
DLFH	BLUM DRAWER LEGRABOX FREE HIGH - 177 MM
DLFL	BLUM DRAWER LEGRABOX FREE LOW - 177 MM
DLPC	BLUM DRAWER LEGRABOX PURE C - 177 MM
DLPF	BLUM DRAWER LEGRABOX PURE F - 241 MM
DLPK	BLUM DRAWER LEGRABOX PURE K - 128.5 MM
DLPM	BLUM DRAWER LEGRABOX PURE M - 90.5 MM
DM	BLUM DRAWER MOVENTO (MELAMINE DRAWER BOX)
EQ	EQUAL
FS	FIXED SHELF
FP	FIXED PANNEL
HDB	HINGE DOOR - BLUM ONYX BLACK HINGES
HDN	HINGE DOOR - BLUM NICKEL PLATED HINGES
HF	HINGE FLAP
HR	HANGING RAIL
IAS	INTERNAL ADJUSTABLE SHELF
IDLFH	BLUM INTERNAL DRAWER LEGRABOX FREE HIGH - 177 MM
IDLFL	BLUM INTERNAL DRAWER LEGRABOX FREE LOW - 177 MM
IDLPC	BLUM INTERNAL DRAWER LEGRABOX PURE C - 177 MM
IDLPF	BLUM INTERNAL DRAWER LEGRABOX PURE F - 241 MM
IDLPK	BLUM INTERNAL DRAWER LEGRABOX PURE K - 128.5 MM
IDLPM	BLUM INTERNAL DRAWER LEGRABOX PURE M - 90.5 MM
IDM	BLUM INTERNAL DRAWER MOVENTO (MELAMINE DRAWER BOX)
IFS	INTERNAL FIXED SHELF
IHDB	INTERNAL HINGE DOOR - BLUM ONYX BLACK HINGES
IHDN	INTERNAL HINGE DOOR - BLUM NICKEL PLATED HINGES
IPAS	INTERNAL PULLOUT ANGLED SHOE SHELF
IPS	INTERNAL PULLOUT SHELF
IJS	INTERNAL JOIN
IS	PULLOUT SHELF
RD	RETRACTABLE DOOR
SL	SEAM LINE
SP	SLIDING PANEL
STSM	SUBJECT TO SITE MEASURE
STAS	SUBJECT TO APPLIANCE SPECS
Ⓟ	BIFOLD OPERATION
Ⓡ	FINGER GRIP OPERATION WITH BLUMOTION
Ⓜ	MANUAL OPERATION WITH BLUMOTION
Ⓟ	PUSH TOUCH OPERATION WITH BLUM TIP ON FOR DOORS
Ⓡ	TIP ON OPERATION WITH BLUMOTION FOR DRAWERS
Ⓢ	SERVO-DRIVE OPERATION - BLUM
Ⓜ	AMBIALINE - BLUM INNER DIVIDER SYSTEM - LEGRABOX
Ⓞ	ORGALINE - BLUM INNER DIVIDER SYSTEM - MOVENTO

SCALE BAR

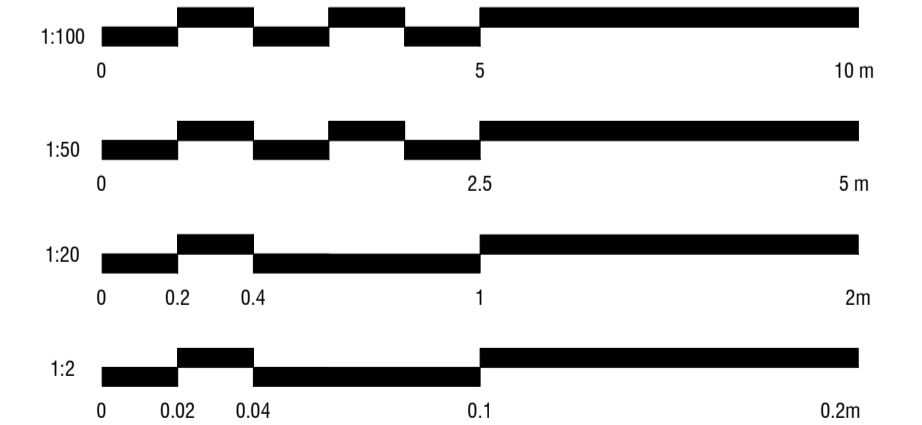

ALL MEASUREMENTS TO BE CHECKED BY TRADES ONSITE*

CHRISTOPHER
ELLIOTT


CHRISTOPHER ELLIOTT DESIGN PTY LTD
ABN 33131218650 ACN 131218650
T +61 (03)9077 8133 M +61 (0)403 653 649
INFO@CHRISTOPHERELLIOTTDESIGN.COM.AU
PO BOX 124 PRAHRAN 3181 VICTORIA AUSTRALIA

CLIENT AUSTRALIAN ALPINE CLUB
PROJECT ALPINE ROAD, HOTHAM HEIGHTS VIC 3741

All rights reserved. This document remains the property of Christopher Elliott Design Pty Ltd and is only to be used for its commissioned purpose. No part of this document may be reproduced, modified or transmitted in any form or by any means without the explicit written authority of Christopher Elliott Design Pty Ltd. Unauthorised use of this document in any form whatsoever is prohibited.

TITLE LAUNDRY
SCALE @ A1 AS INDICATED
CHECKED BY CE
SHEET INT-6.02

PLOT DATE 05.06.20
DRAWN BY CA
REVISION A

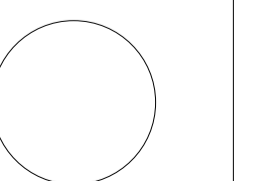


CONSTRUCTION ISSUE

REVISION STATUS

REV.	DESCRIPTION	DATE
A	REVISION #3 CONSTRUCTION DOCS ISSUED	05.06.20


JOINERY

AS	ADJUSTABLE SHELF
AL	ALIGN
BAL	BALANCE
BS	BIFOLD SLIDING
CL	CENTRE LINE
DA	DOOR ACTIVATED
DLFH	BLUM DRAWER LEGRABOX FREE HIGH - 177 MM
DLFL	BLUM DRAWER LEGRABOX FREE LOW - 177 MM
DLPC	BLUM DRAWER LEGRABOX PURE C - 177 MM
DLPF	BLUM DRAWER LEGRABOX PURE F - 241 MM
DLPK	BLUM DRAWER LEGRABOX PURE K - 128.5 MM
DLPM	BLUM DRAWER LEGRABOX PURE M - 90.5 MM
DM	BLUM DRAWER MOVENTO (MELAMINE DRAWER BOX)
EQ	EQUAL
FS	FIXED SHELF
FP	FIXED PANNEL
HDB	HINGE DOOR - BLUM ONYX BLACK HINGES
HDN	HINGE DOOR - BLUM NICKEL PLATED HINGES
HF	HINGE FLAP
HR	HANGING RAIL
IAS	INTERNAL ADJUSTABLE SHELF
IDLFH	BLUM INTERNAL DRAWER LEGRABOX FREE HIGH - 177 MM
IDLFL	BLUM INTERNAL DRAWER LEGRABOX FREE LOW - 177 MM
IDLPC	BLUM INTERNAL DRAWER LEGRABOX PURE C - 177 MM
IDLPF	BLUM INTERNAL DRAWER LEGRABOX PURE F - 241 MM
IDLPK	BLUM INTERNAL DRAWER LEGRABOX PURE K - 128.5 MM
IDLPM	BLUM INTERNAL DRAWER LEGRABOX PURE M - 90.5 MM
IDM	BLUM INTERNAL DRAWER MOVENTO (MELAMINE DRAWER BOX)
IFS	INTERNAL FIXED SHELF
IHDB	INTERNAL HINGE DOOR - BLUM ONYX BLACK HINGES
IHDN	INTERNAL HINGE DOOR - BLUM NICKEL PLATED HINGES
IPAS	INTERNAL PULLOUT ANGLED SHOE SHELF
IPS	INTERNAL PULLOUT SHELF
MJ	MITRE JOIN
PS	PULLOUT SHELF
RD	RETRACTABLE DOOR
SL	SEAM LINE
SP	SLIDING PANEL
STSM	SUBJECT TO SITE MEASURE
STAS	SUBJECT TO APPLIANCE SPECS
Ⓟ	BI-FOLD OPERATION
Ⓣ	FINGER GRIP OPERATION WITH BLUMOTION
Ⓜ	MANUAL OPERATION WITH BLUMOTION
Ⓟ	PUSH TOUCH OPERATION WITH BLUM TIP ON FOR DOORS
Ⓡ	TIP ON OPERATION WITH BLUMOTION FOR DRAWERS
Ⓢ	SERVO-DRIVE OPERATION - BLUM
Ⓜ	AMBIALINE - BLUM INNER DIVIDER SYSTEM - LEGRABOX
Ⓞ	ORGALINE - BLUM INNER DIVIDER SYSTEM - MOVENTO

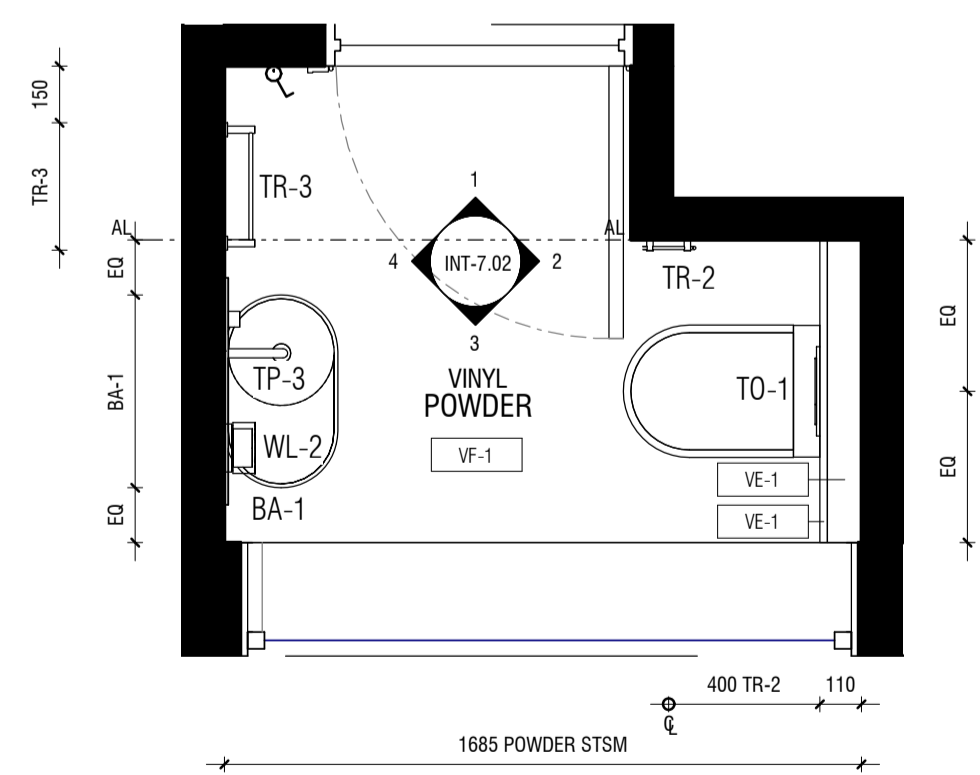

1 POWDER FLOOR PLAN
1 : 20

SCALE BAR

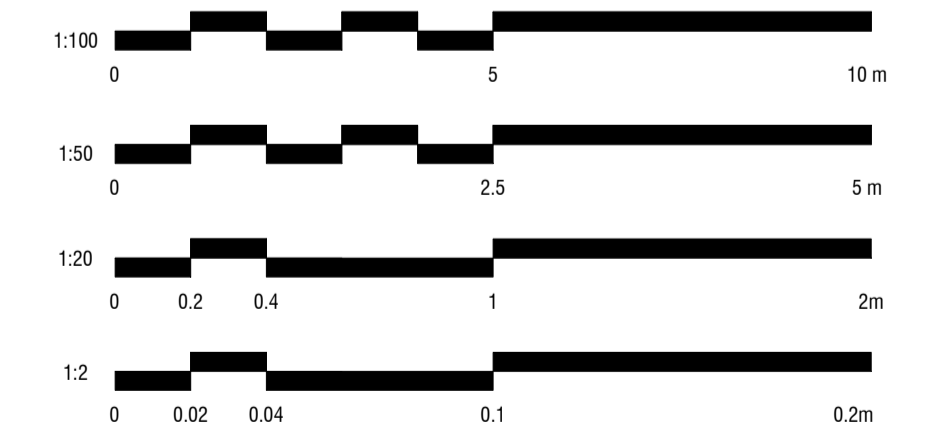

ALL MEASUREMENTS TO BE CHECKED BY TRADES ONSITE*

CHRISTOPHER
ELLIOTT


CHRISTOPHER ELLIOTT DESIGN PTY LTD
ABN 33131218650 ACN 131218650
T+61 (03)9077 8133 M +61 (0)403 653 649
INFO@CHRISTOPHERELLIOTTDESIGN.COM.AU
PO BOX 124 PRAHRAN 3181 VICTORIA AUSTRALIA

CLIENT AUSTRALIAN ALPINE CLUB
PROJECT ALPINE ROAD, HOTHAM HEIGHTS VIC 3741

All rights reserved. This document remains the property of Christopher Elliott Design Pty Ltd and is only to be used for its commissioned purpose. No part of this document may be reproduced, modified or transmitted in any form or by any means without the explicit written authority of Christopher Elliott Design Pty Ltd. Unauthorised use of this document in any form whatsoever is prohibited.

TITLE POWDER
SCALE @ A1 AS INDICATED
CHECKED BY CE
SHEET INT-7.01


PLOT DATE 05.06.20
DRAWN BY CA
REVISION A

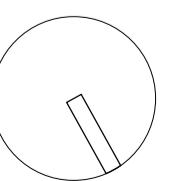


CONSTRUCTION ISSUE

REVISION STATUS


REV.	DESCRIPTION	DATE
A	REVISION #3 CONSTRUCTION DOCS ISSUED	05.06.20

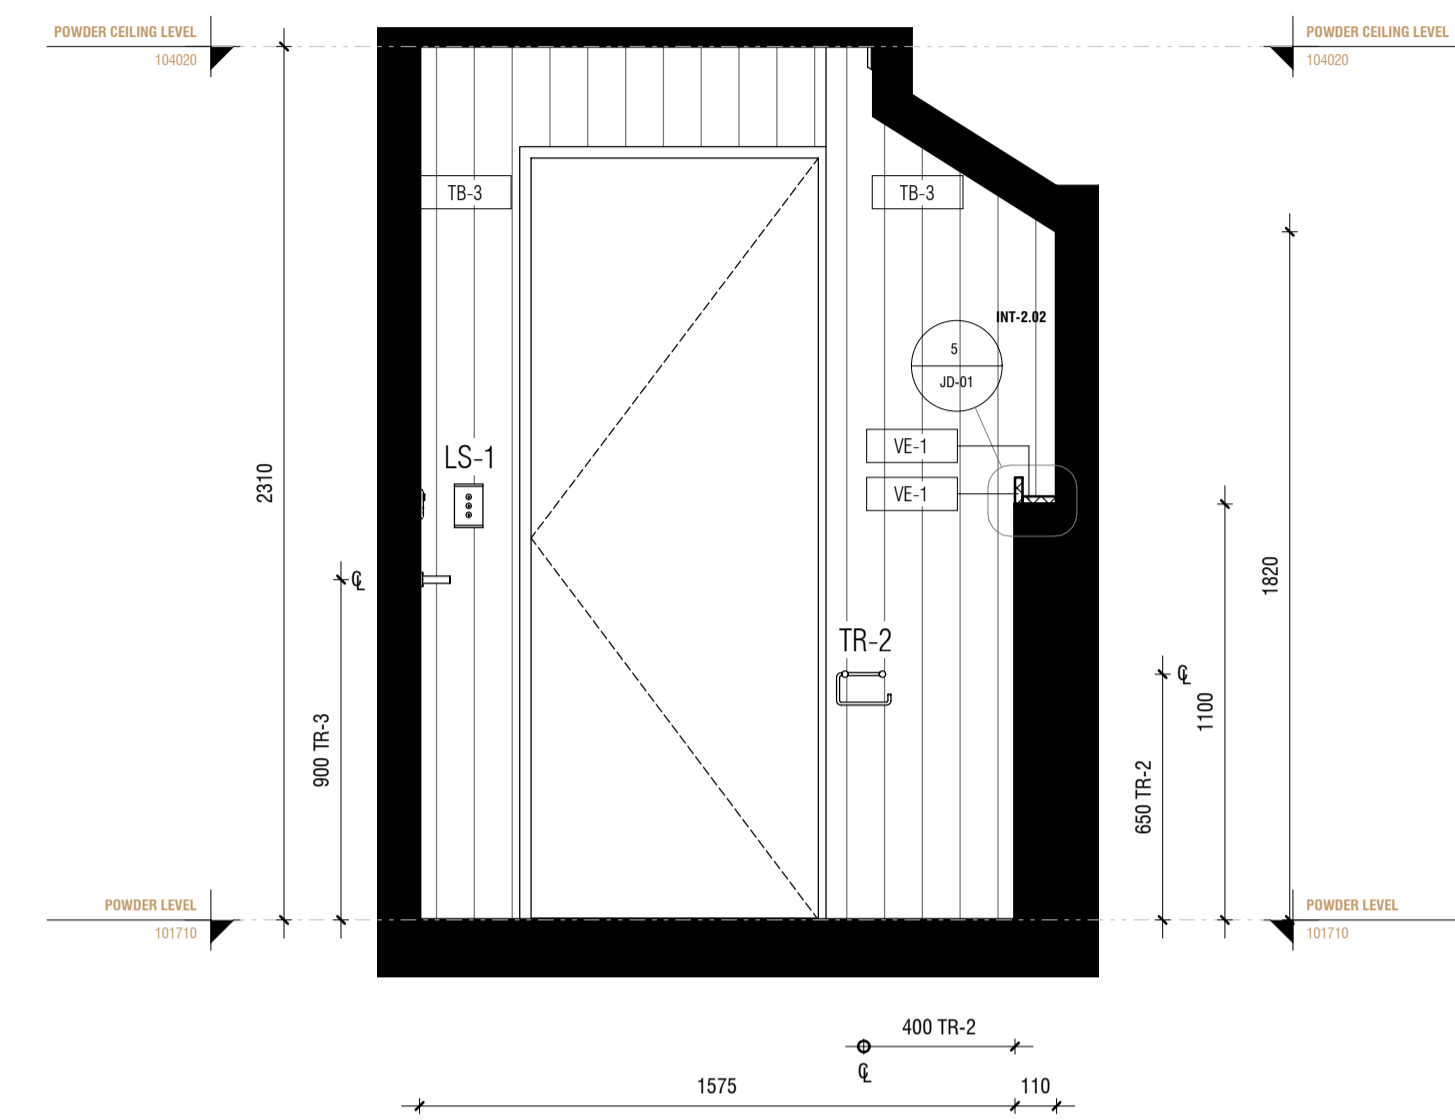


1 INT-7.02 ELEVATION 1
1:20

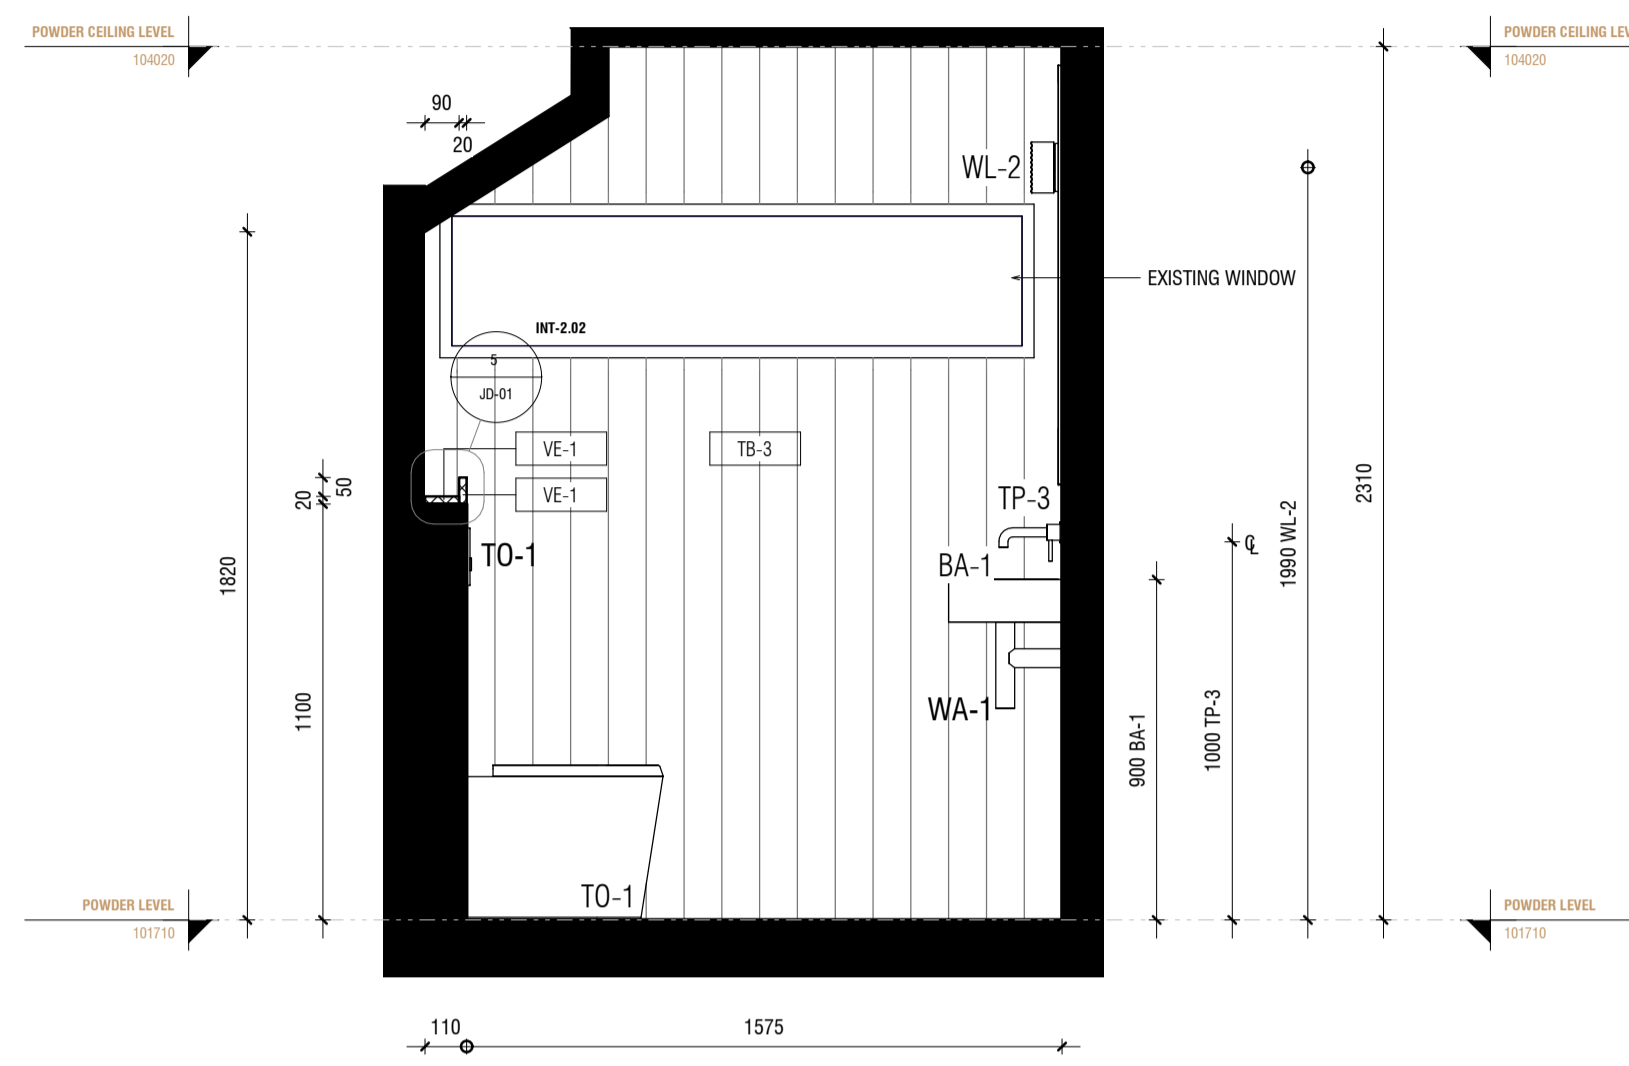

3 INT-7.02 ELEVATION 3
1:20

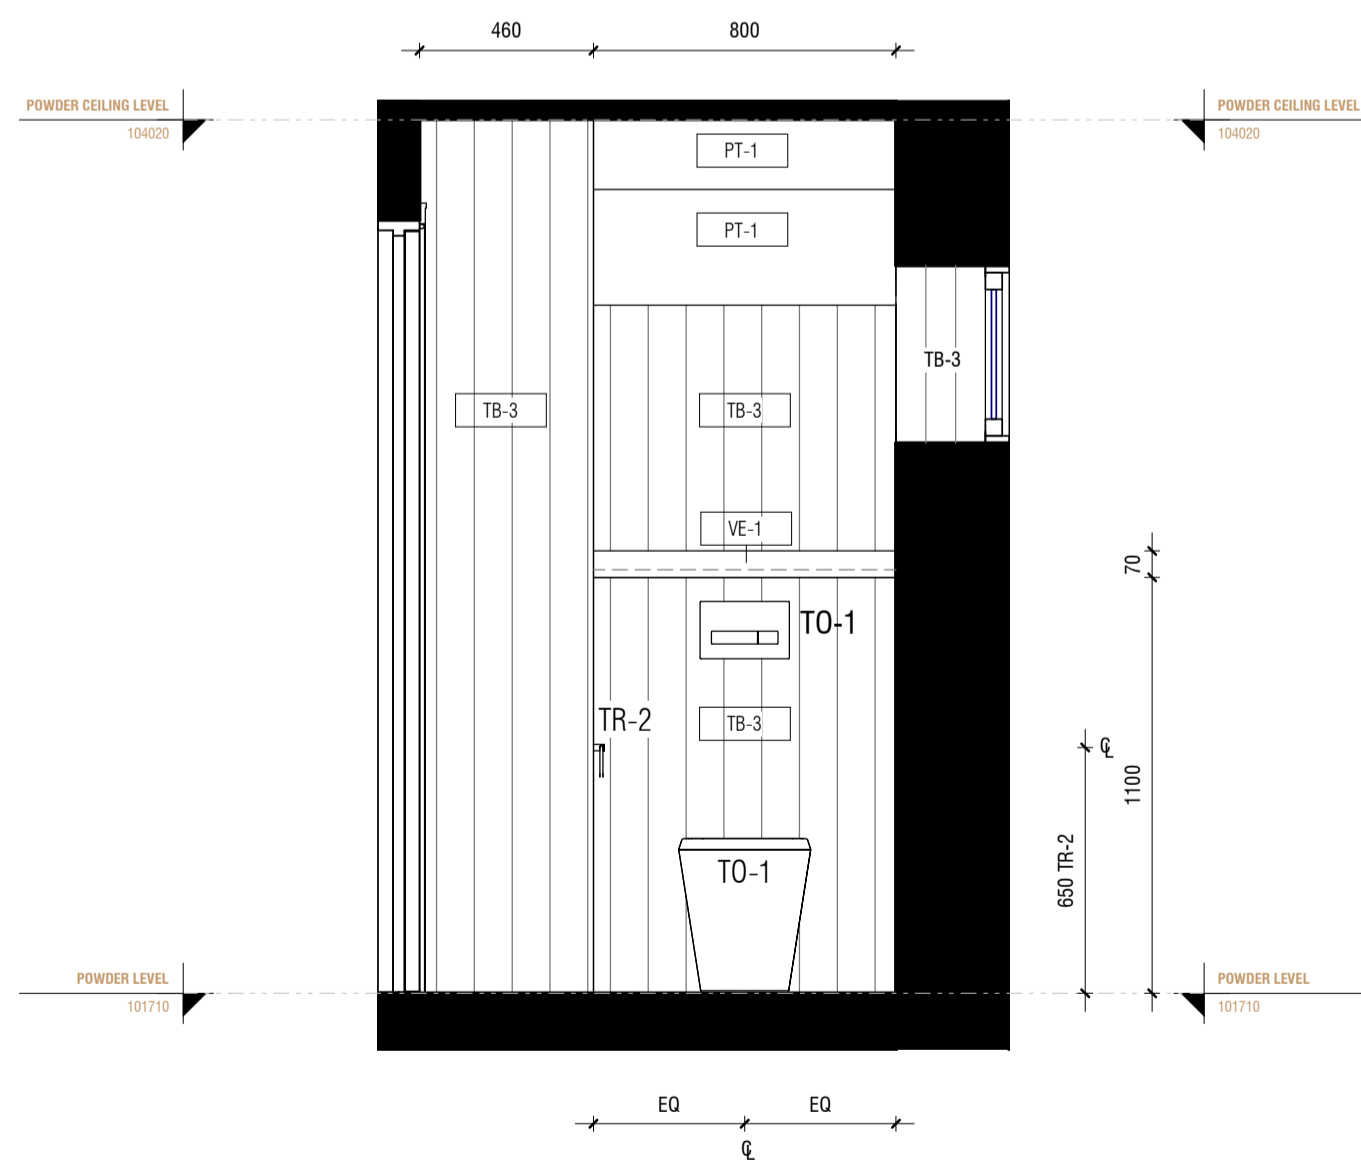

2 INT-7.02 ELEVATION 2
1:20

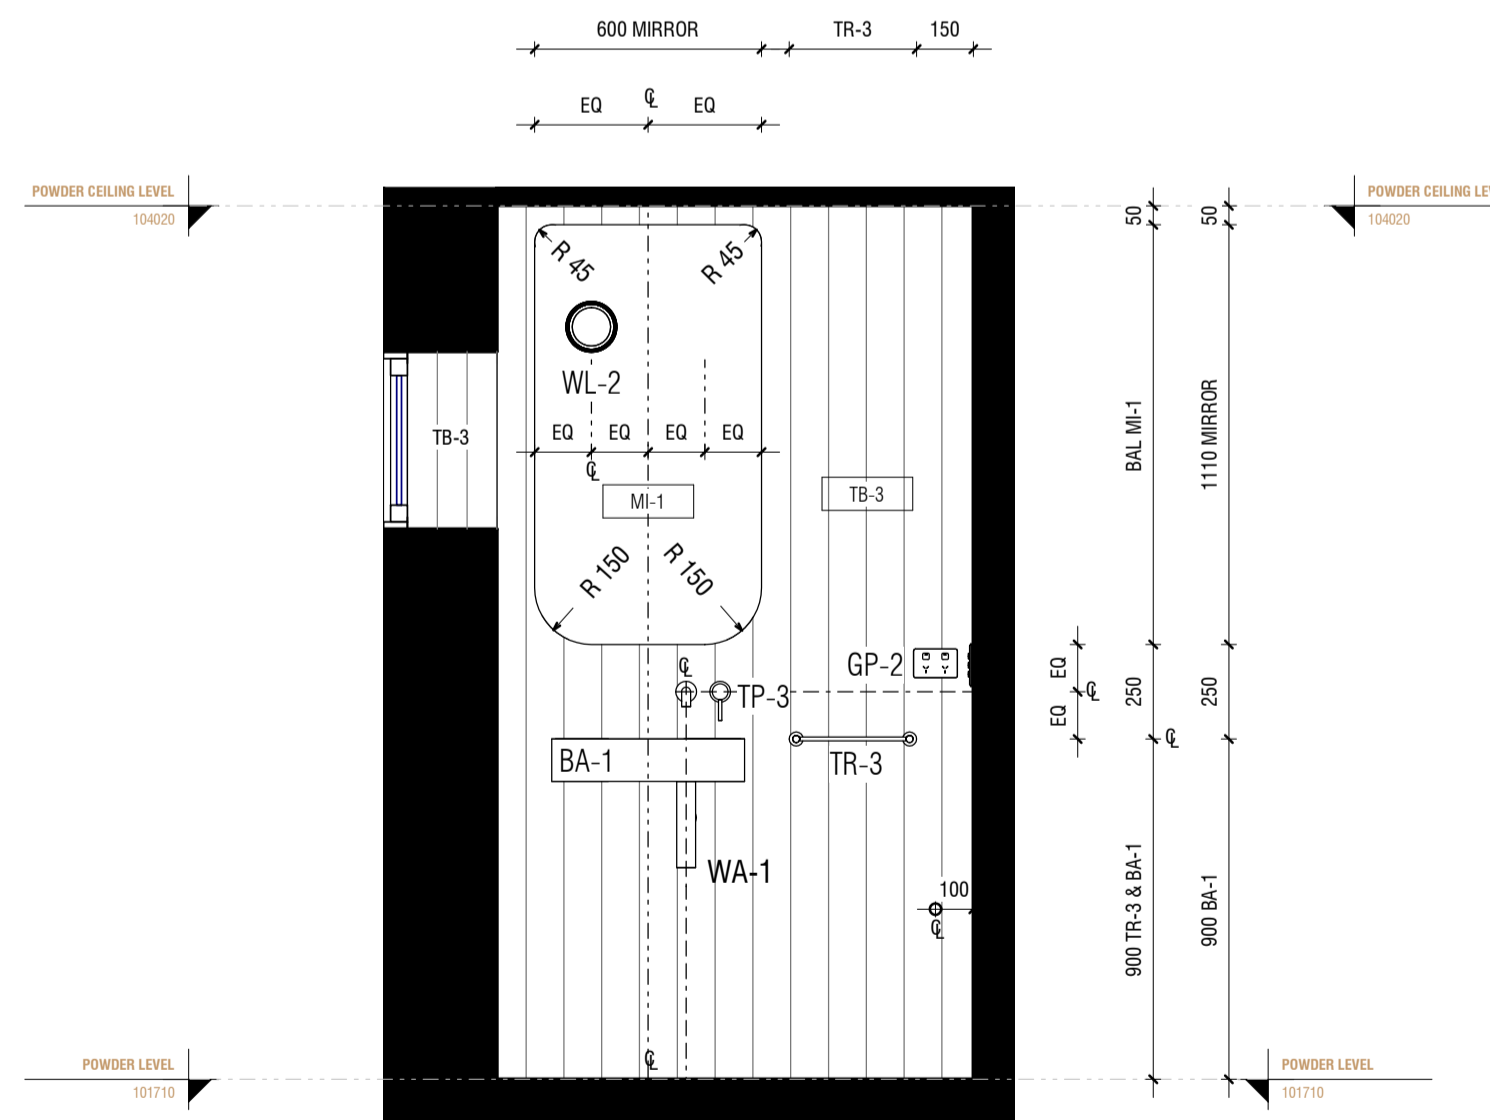


4 INT-7.02 ELEVATION 4
1:20

JOINERY

AS	ADJUSTABLE SHELF
AL	ALIGN
BAL	BALANCE
BS	BIFOLD SLIDING
CL	CENTRE LINE
DA	DOOR ACTIVATED
DLFH	BLUM DRAWER LEGRABOX FREE HIGH - 177 MM
DLFL	BLUM DRAWER LEGRABOX FREE LOW - 177 MM
DLPC	BLUM DRAWER LEGRABOX PURE C - 177 MM
DLPF	BLUM DRAWER LEGRABOX PURE F - 241 MM
DLPK	BLUM DRAWER LEGRABOX PURE K - 128.5 MM
DLPM	BLUM DRAWER LEGRABOX PURE M - 90.5 MM
DM	BLUM DRAWER MOVENTO (MELAMINE DRAWER BOX)
EQ	EQUAL
FS	FIXED SHELF
FP	FIXED PANNEL
HDB	HINGE DOOR - BLUM ONYX BLACK HINGES
HDN	HINGE DOOR - BLUM NICKEL PLATED HINGES
HF	HINGE FLAP
HR	HANGING RAIL
IAS	INTERNAL ADJUSTABLE SHELF
IDLFH	BLUM INTERNAL DRAWER LEGRABOX FREE HIGH - 177 MM
IDLFL	BLUM INTERNAL DRAWER LEGRABOX FREE LOW - 177 MM
IDLPC	BLUM INTERNAL DRAWER LEGRABOX PURE C - 177 MM
IDLPF	BLUM INTERNAL DRAWER LEGRABOX PURE F - 241 MM
IDLPK	BLUM INTERNAL DRAWER LEGRABOX PURE K - 128.5 MM
IDLPM	BLUM INTERNAL DRAWER LEGRABOX PURE M - 90.5 MM
IDM	BLUM INTERNAL DRAWER MOVENTO (MELAMINE DRAWER BOX)
IFS	INTERNAL FIXED SHELF
IHDB	INTERNAL HINGE DOOR - BLUM ONYX BLACK HINGES
IHDN	INTERNAL HINGE DOOR - BLUM NICKEL PLATED HINGES
IPAS	INTERNAL PULLOUT ANGLED SHOE SHELF
IPS	INTERNAL PULLOUT SHELF
MJ	MITRE JOIN
PS	PULLOUT SHELF
RD	RETRACTABLE DOOR
SL	SEAM LINE
SP	SLIDING PANEL
STSM	SUBJECT TO SITE MEASURE
STAS	SUBJECT TO APPLIANCE SPECS

SCALE BAR

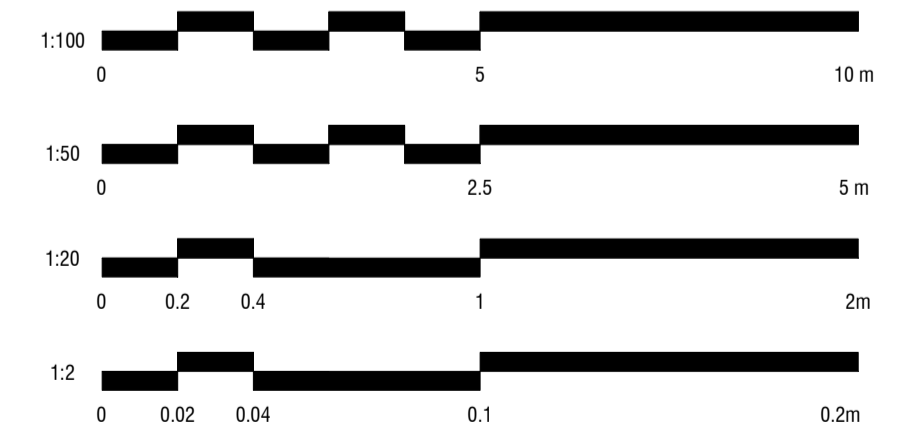

ALL MEASUREMENTS TO BE CHECKED BY TRADES ONSITE*

**CHRISTOPHER
ELLIOTT**


CHRISTOPHER ELLIOTT DESIGN PTY LTD
ABN 33131218650 ACN 131218650
T+61 (03)9077 8133 M +61 (0)403 653 649
INFO@CHRISTOPHERELLIOTTDESIGN.COM.AU
PO BOX 124 PRAHRAN 3181 VICTORIA AUSTRALIA

CLIENT AUSTRALIAN ALPINE CLUB
PROJECT ALPINE ROAD, HOTHAM HEIGHTS VIC 3741

All rights reserved. This document remains the property of Christopher Elliott Design Pty Ltd and is only to be used for its commissioned purpose. No part of this document may be reproduced, modified or transmitted in any form or by any means without the explicit written authority of Christopher Elliott Design Pty Ltd. Unauthorised use of this document in any form whatsoever is prohibited.


TITLE POWDER
SCALE @ A1 AS INDICATED
CHECKED BY CE
SHEET INT-7.02

PLOT DATE 05.06.20
DRAWN BY CA
REVISION A

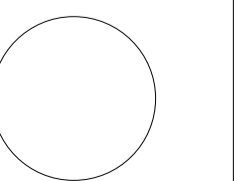

REVISION STATUS

REV.	DESCRIPTION	DATE
A	REVISION #3 CONSTRUCTION DOCS ISSUED	05.06.20

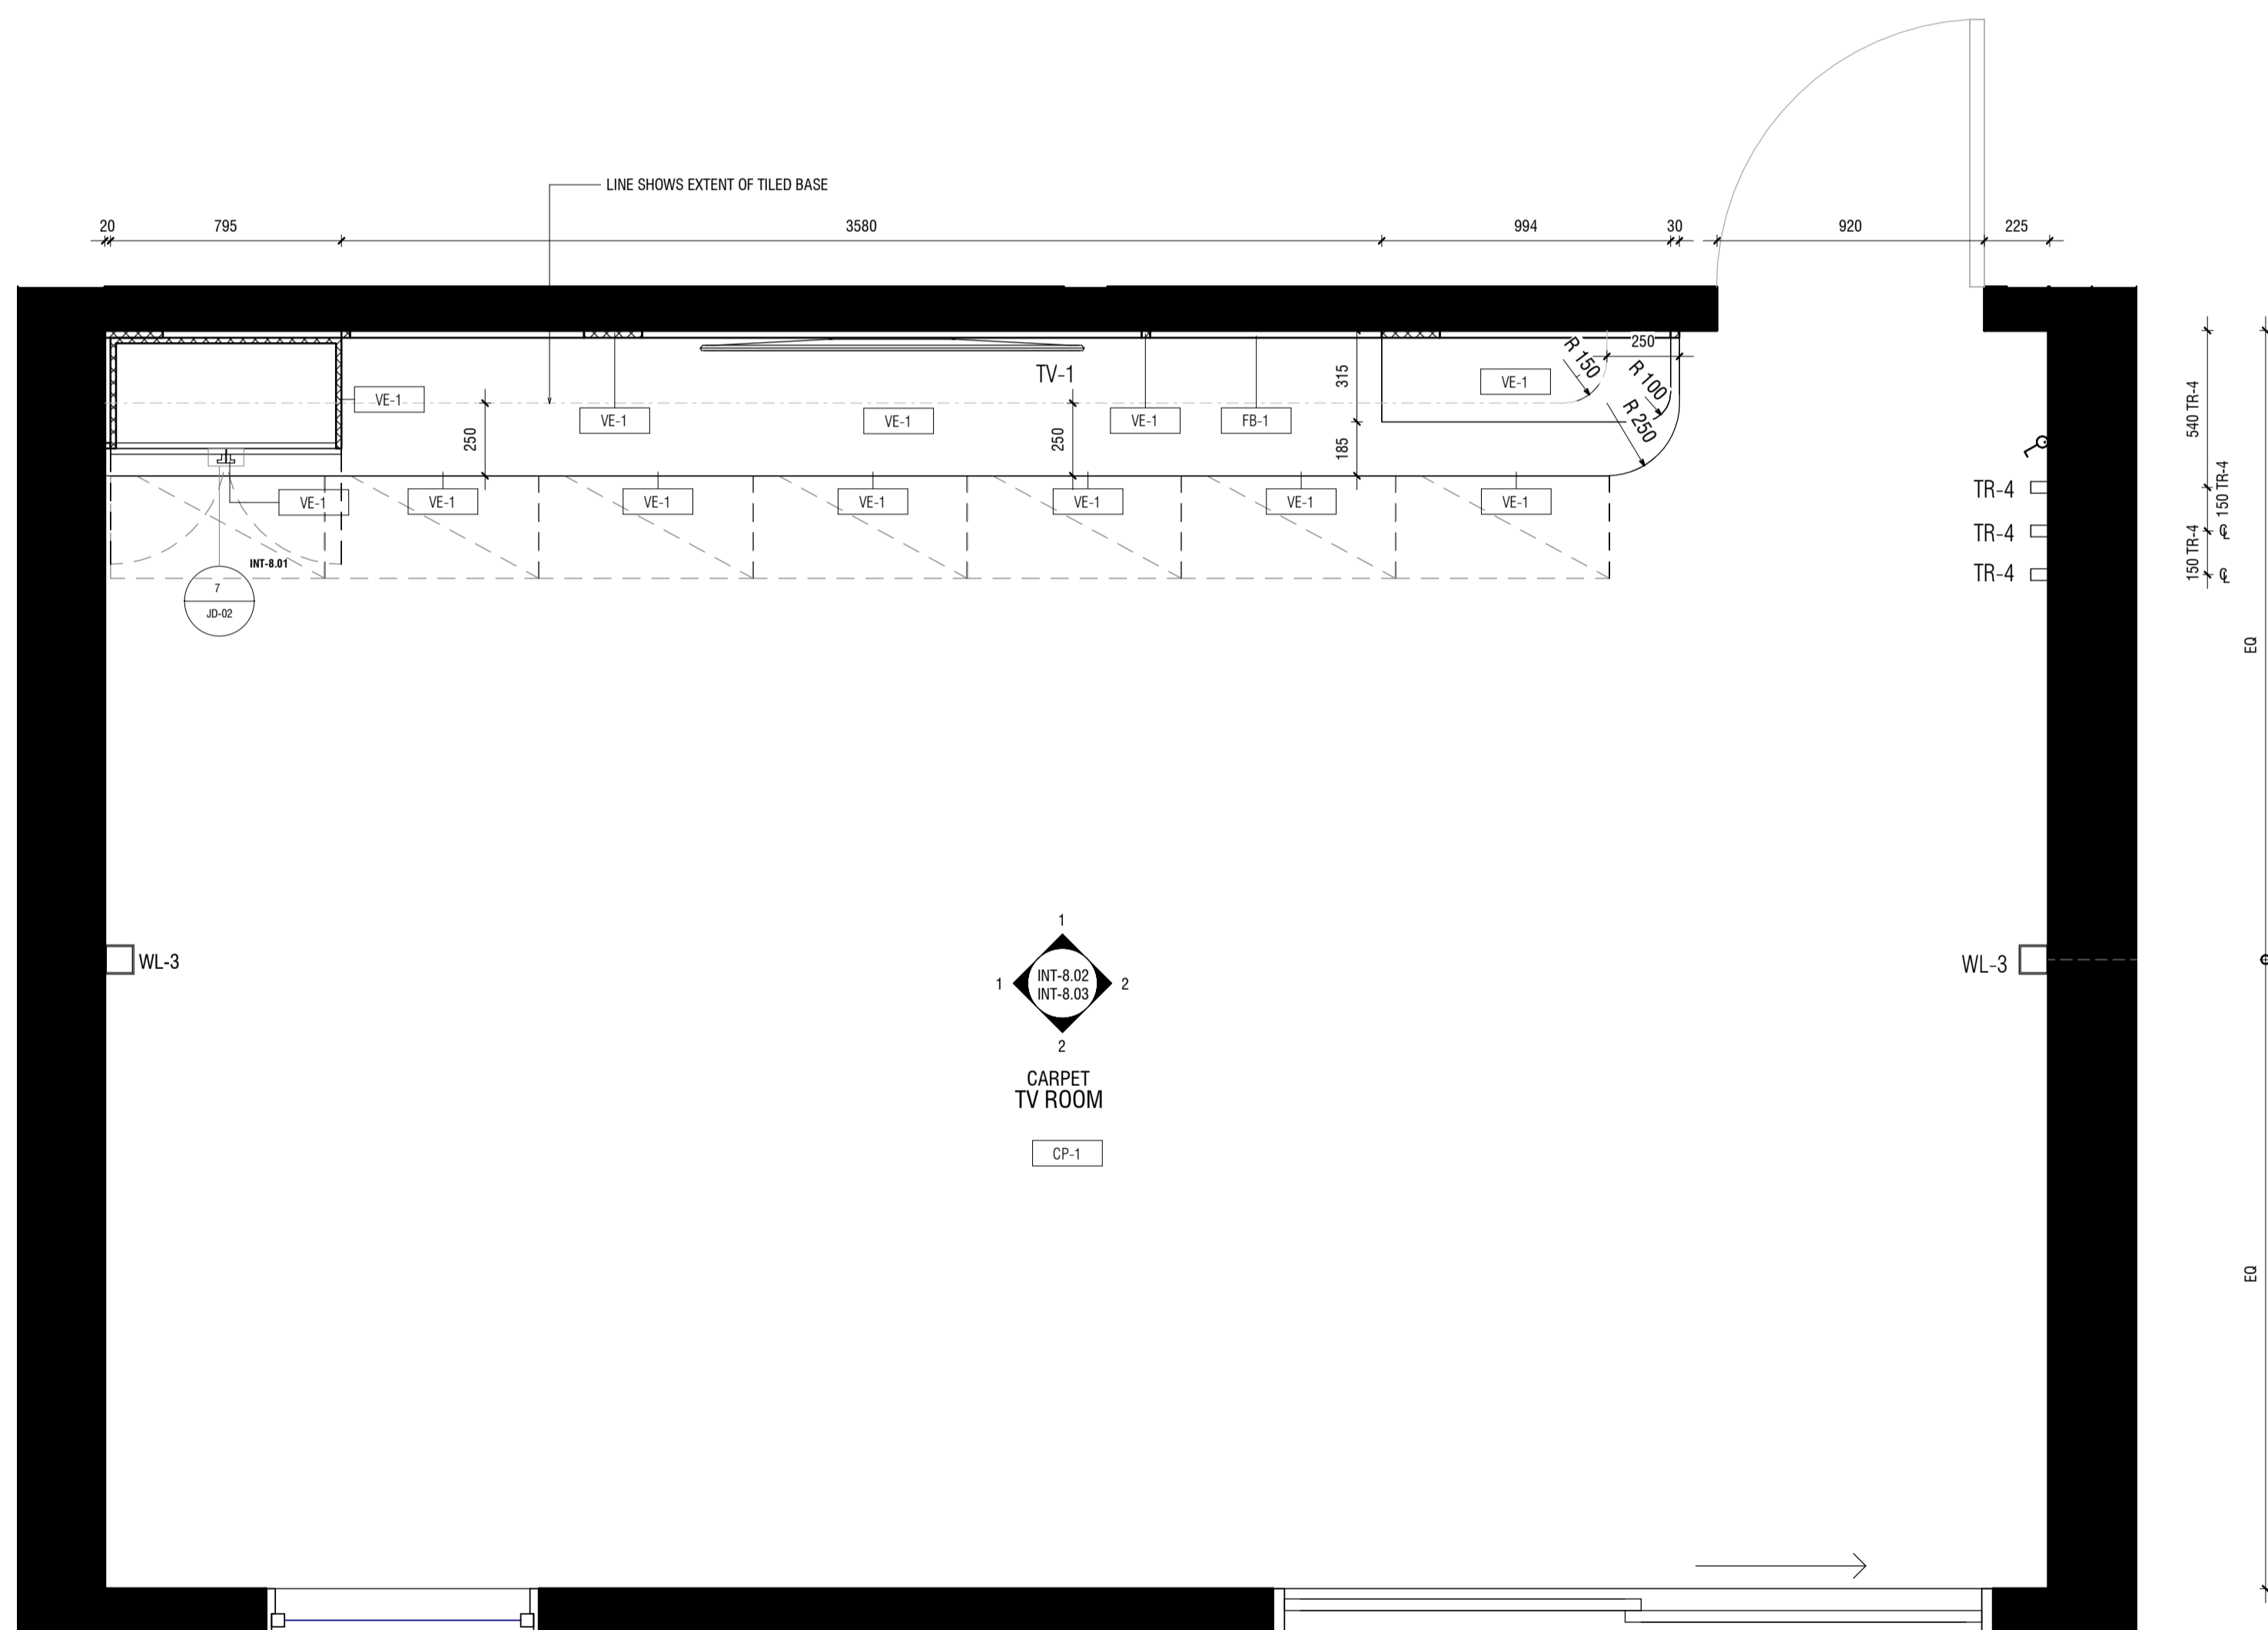


NOTE: EZY REVEAL TO WINDOW REVEAL

JOINERY

AS	ADJUSTABLE SHELF
AL	ALIGN
BAL	BALANCE
BS	BIFOLD SLIDING
CL	CENTRE LINE
DA	DOOR ACTIVATED
DLFH	BLUM DRAWER LEGRABOX FREE HIGH - 177 MM
DLFL	BLUM DRAWER LEGRABOX FREE LOW - 177 MM
DLPC	BLUM DRAWER LEGRABOX PURE C - 177 MM
DLPF	BLUM DRAWER LEGRABOX PURE F - 241 MM
DLPK	BLUM DRAWER LEGRABOX PURE K - 128.5 MM
DLPM	BLUM DRAWER LEGRABOX PURE M - 90.5 MM
DM	BLUM DRAWER MOVENTO (MELAMINE DRAWER BOX)
EQ	EQUAL
FS	FIXED SHELF
FP	FIXED PANNEL
HDB	HINGE DOOR - BLUM ONYX BLACK HINGES
HDN	HINGE DOOR - BLUM NICKEL PLATED HINGES
HF	HINGE FLAP
HR	HANGING RAIL
IAS	INTERNAL ADJUSTABLE SHELF
IDLFH	BLUM INTERNAL DRAWER LEGRABOX FREE HIGH - 177 MM
IDLFL	BLUM INTERNAL DRAWER LEGRABOX FREE LOW - 177 MM
IDLPC	BLUM INTERNAL DRAWER LEGRABOX PURE C - 177 MM
IDLPF	BLUM INTERNAL DRAWER LEGRABOX PURE F - 241 MM
IDLPK	BLUM INTERNAL DRAWER LEGRABOX PURE K - 128.5 MM
IDLPM	BLUM INTERNAL DRAWER LEGRABOX PURE M - 90.5 MM
IDM	BLUM INTERNAL DRAWER MOVENTO (MELAMINE DRAWER BOX)
IFS	INTERNAL FIXED SHELF
IHDB	INTERNAL HINGE DOOR - BLUM ONYX BLACK HINGES
IHDN	INTERNAL HINGE DOOR - BLUM NICKEL PLATED HINGES
IPAS	INTERNAL PULLOUT ANGLED SHOE SHELF
IPS	INTERNAL PULLOUT SHELF
IJ	MITRE JOIN
IS	PULLOUT SHELF
ISD	RETRACTABLE DOOR
ISL	SEAM LINE
ISP	SLIDING PANEL
ISTMS	SUBJECT TO SITE MEASURE
ISTAS	SUBJECT TO APPLIANCE SPECS
ⓑ	BI-FOLD OPERATION
Ⓕ	FINGER GRIP OPERATION WITH BLUMOTION
Ⓜ	MANUAL OPERATION WITH BLUMOTION
Ⓟ	PUSH TOUCH OPERATION WITH BLUM TIP ON FOR DOORS
Ⓣ	TIP ON OPERATION WITH BLUMOTION FOR DRAWERS
Ⓢ	SERVO-DRIVE OPERATION - BLUM
ⓐ	AMBIALINE - BLUM INNER DIVIDER SYSTEM - LEGRABOX
ⓓ	ORGALINE - BLUM INNER DIVIDER SYSTEM - MOVENTO

SCALE BAR

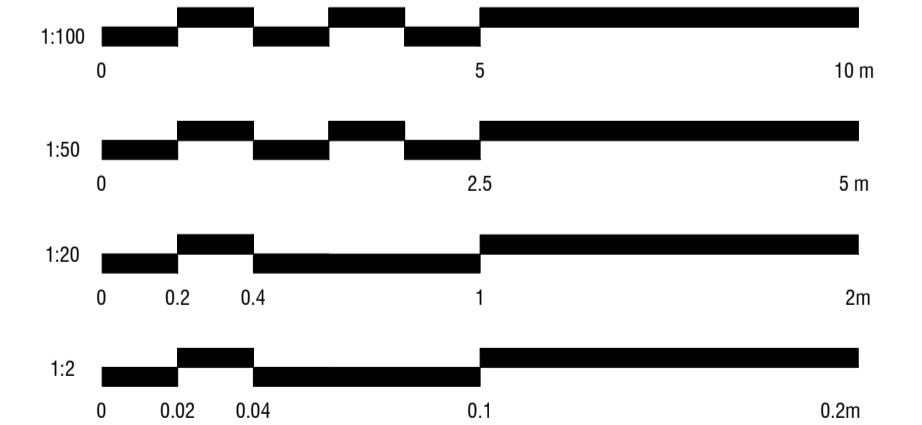

ALL MEASUREMENTS TO BE CHECKED BY TRADES ONSITE*

1 TV ROOM FLOOR PLAN
1:20

CHRISTOPHER
ELLIOTT


CHRISTOPHER ELLIOTT DESIGN PTY LTD
ABN 33131218650 ACN 131218650
T+61 (03)9077 8133 M +61 (0)403 653 649
INFO@CHRISTOPHERELLIOTTDESIGN.COM.AU
PO BOX 124 PRAHRAN 3181 VICTORIA AUSTRALIA

CLIENT AUSTRALIAN ALPINE CLUB
PROJECT ALPINE ROAD, HOTHAM HEIGHTS VIC 3741

All rights reserved. This document remains the property of Christopher Elliott Design Pty Ltd and is only to be used for its commissioned purpose. No part of this document may be reproduced, modified or transmitted in any form or by any means without the explicit written authority of Christopher Elliott Design Pty Ltd. Unauthorised use of this document in any form whatsoever is prohibited.

TITLE TV ROOM
SCALE @ A1 AS INDICATED
CHECKED BY CE
SHEET INT-8.01


PLOT DATE 05.06.20
DRAWN BY CA
REVISION A

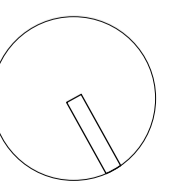


CONSTRUCTION ISSUE

REVISION STATUS

REV.	DESCRIPTION	DATE
A	REVISION #3 CONSTRUCTION DOCS ISSUED	05.06.20

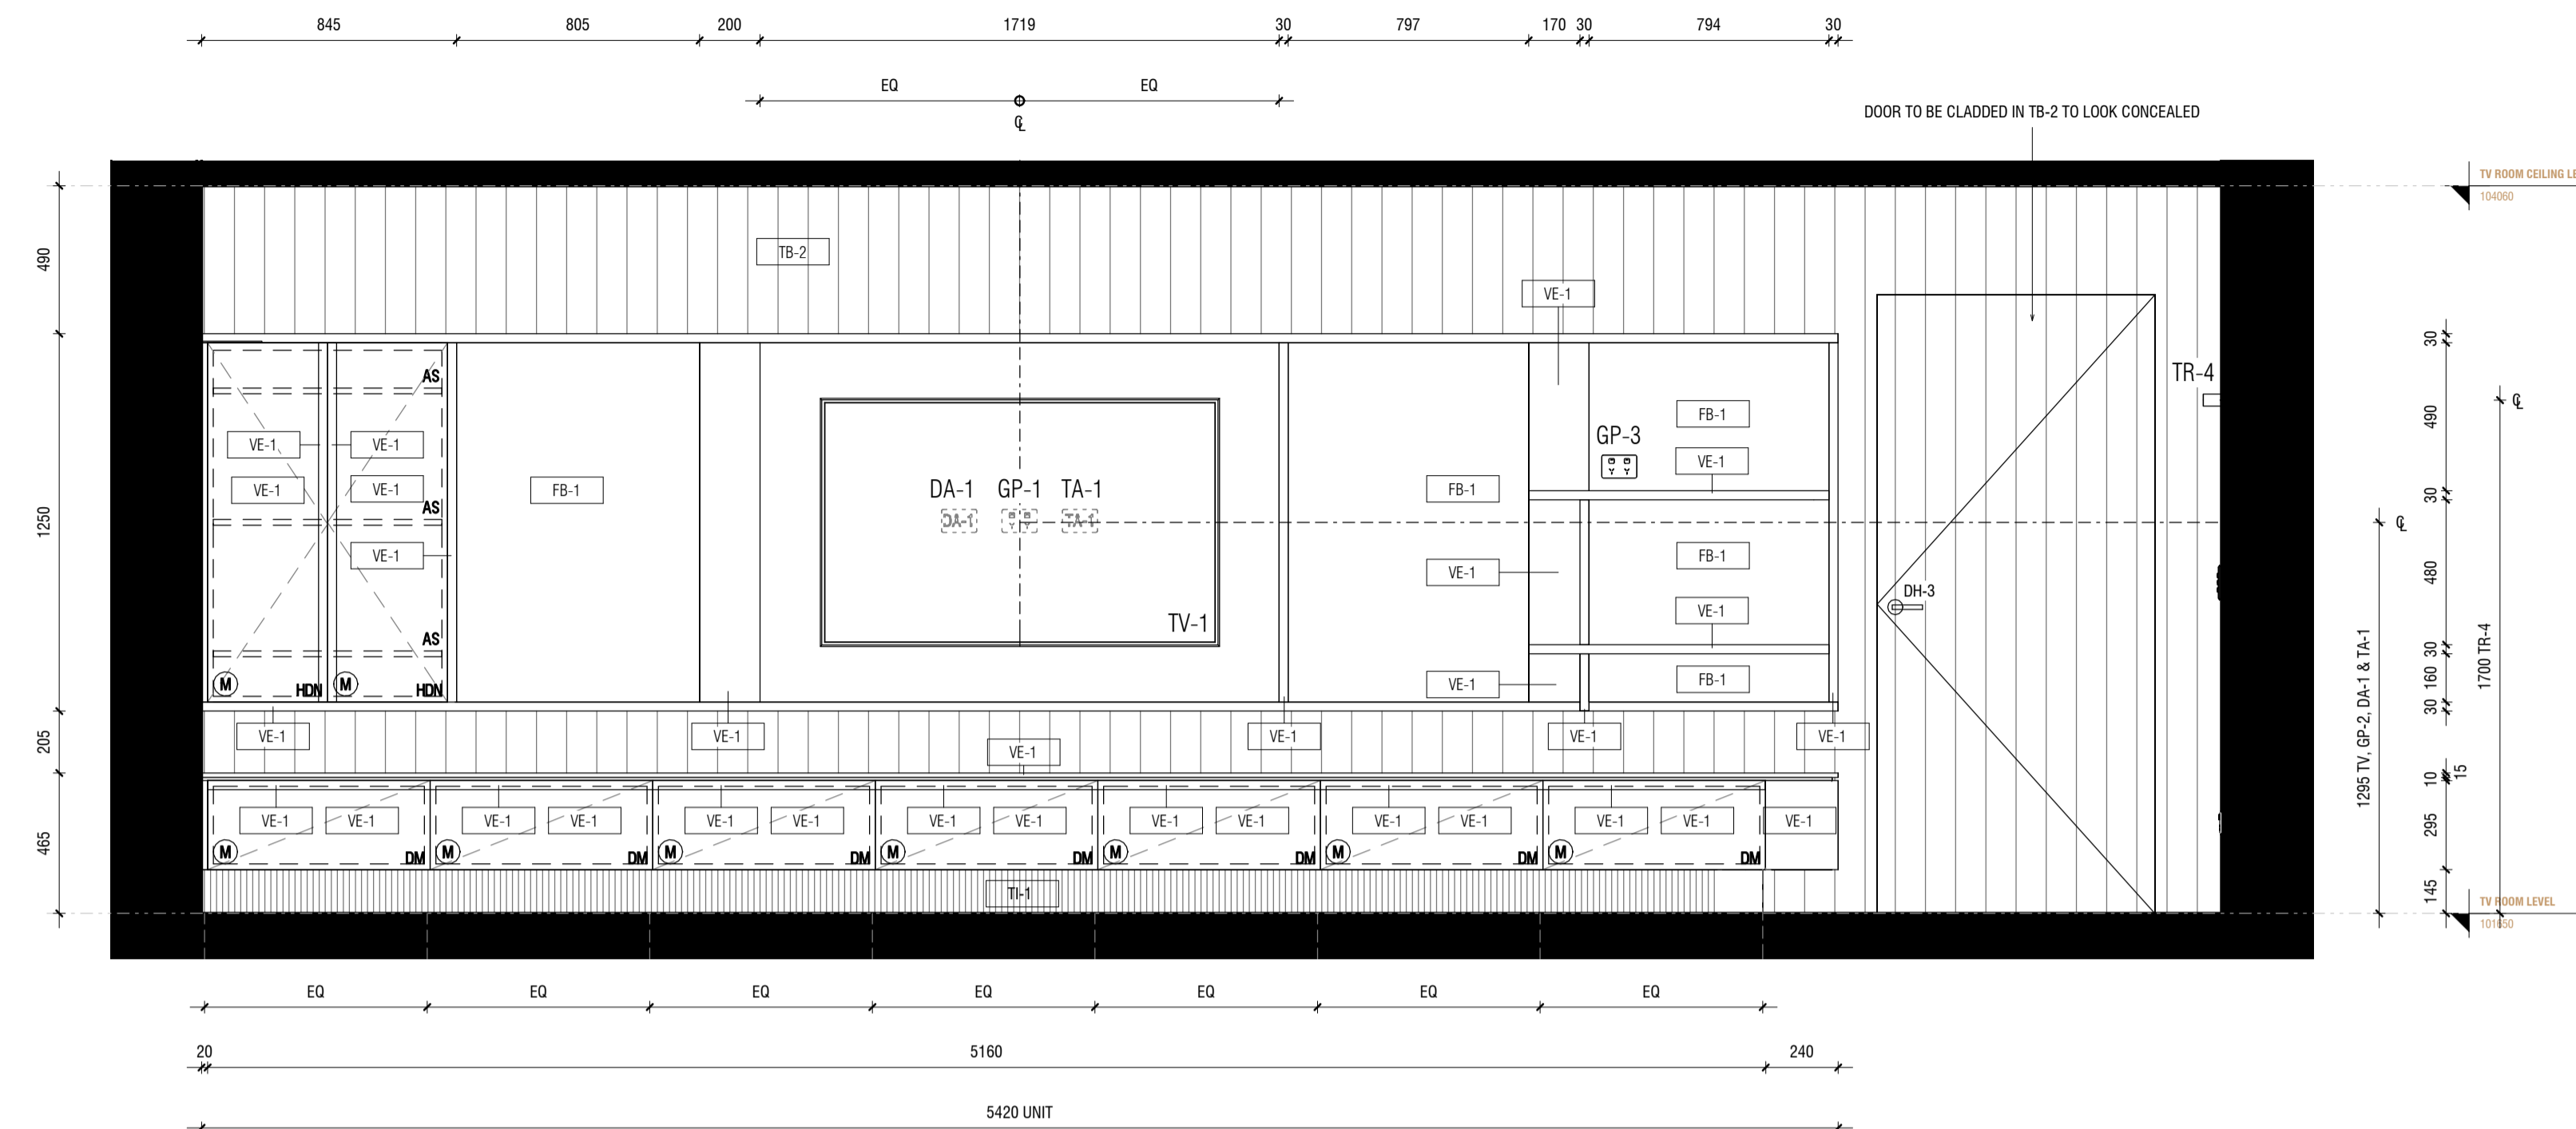

1 INT-8.02 ELEVATION 1
1:20

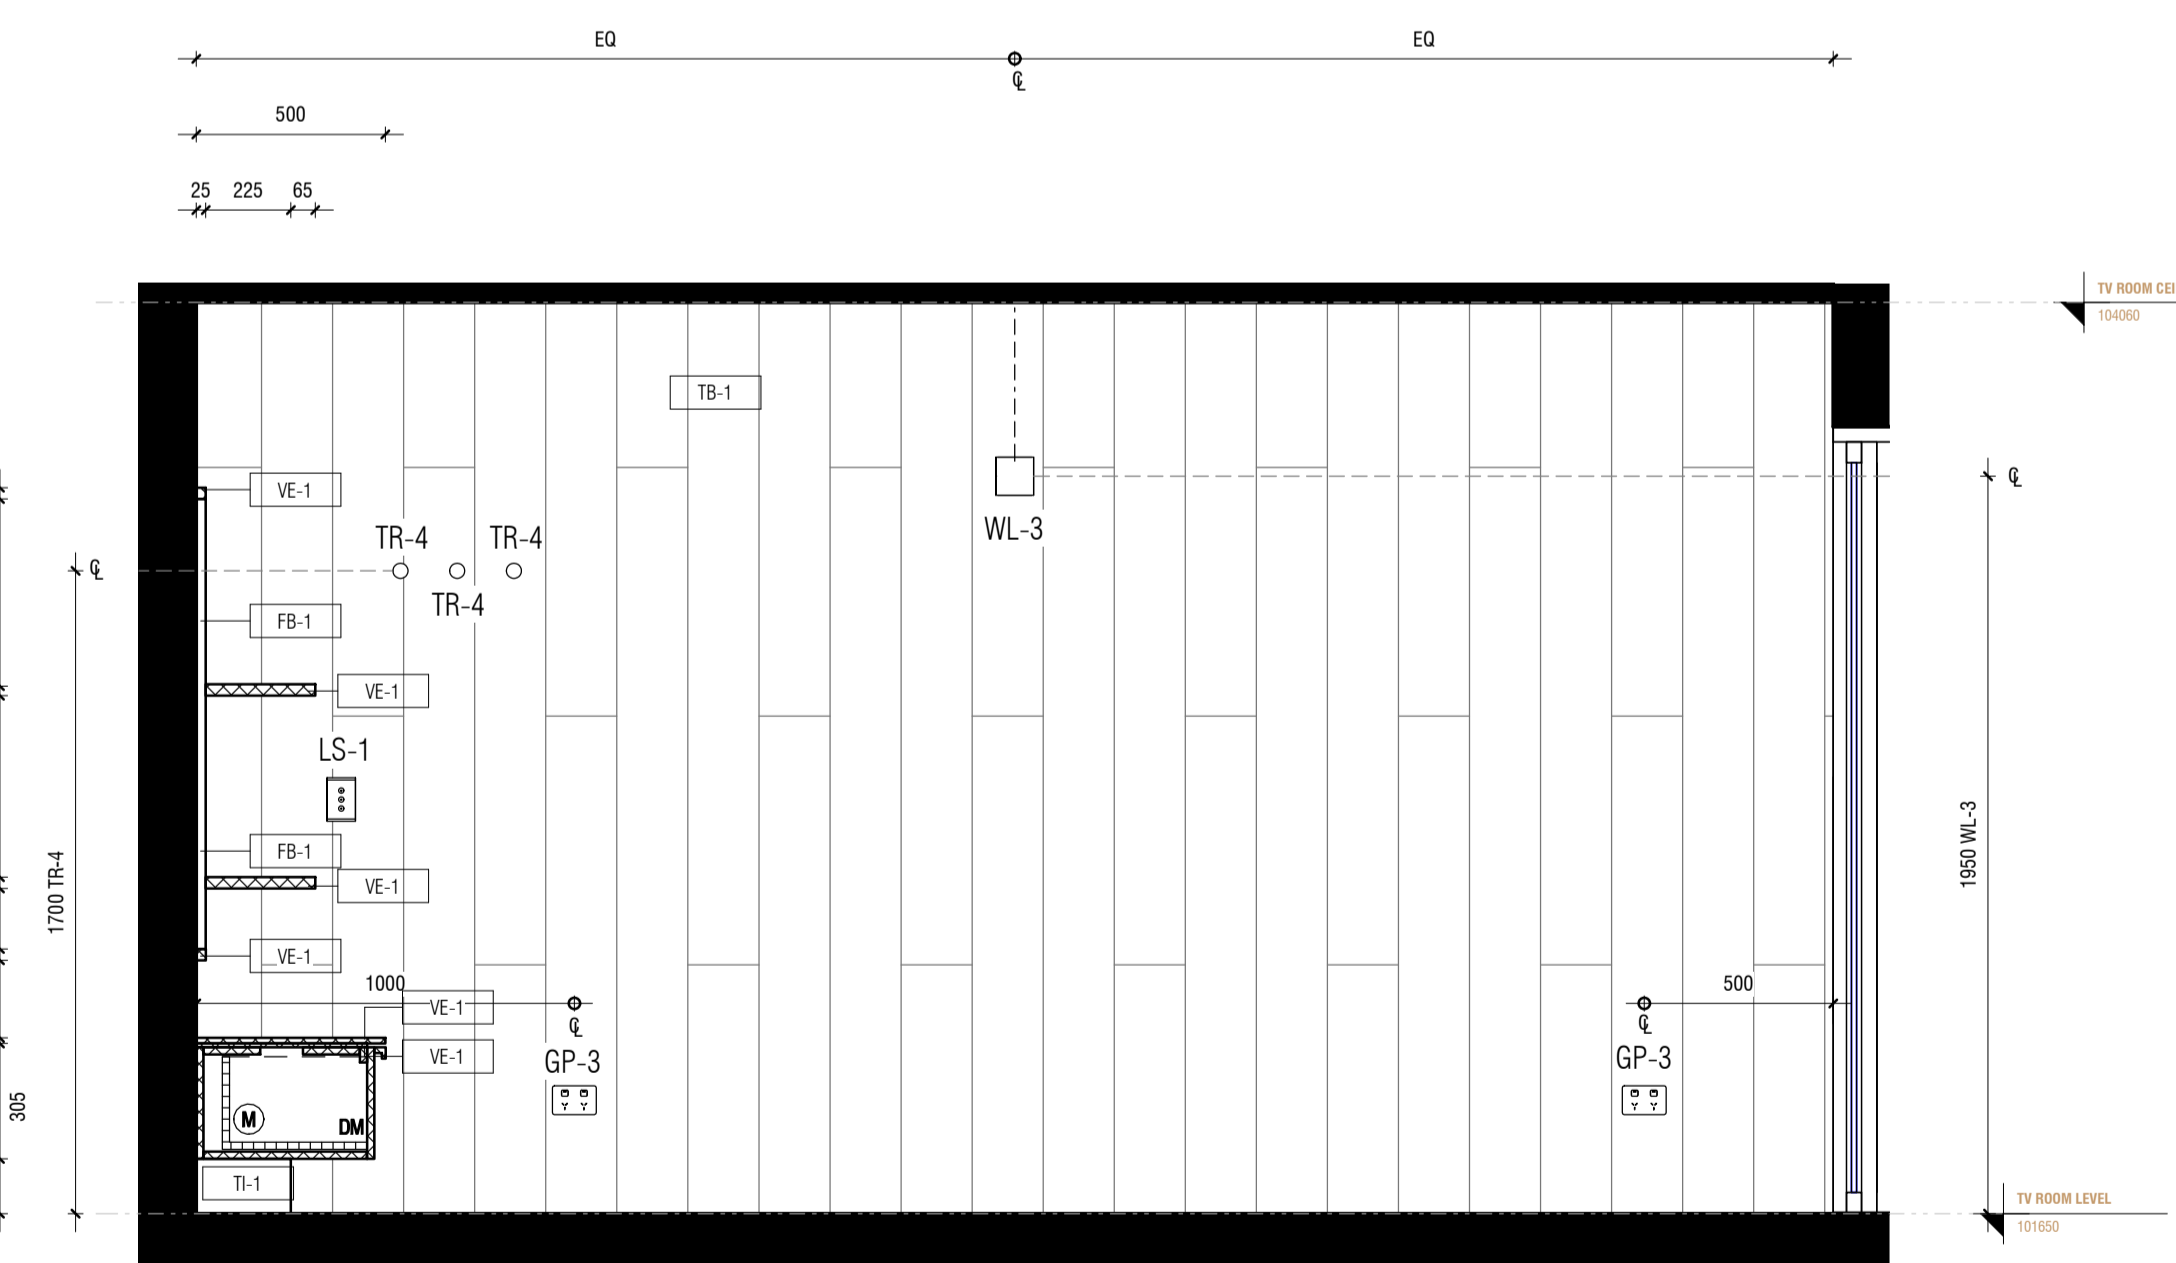


2 INT-8.02 ELEVATION 2
1:20

JOINERY

AS	ADJUSTABLE SHELF
AL	ALIGN
BAL	BALANCE
BS	BIFOLD SLIDING
CL	CENTRE LINE
DA	DOOR ACTIVATED
DLFH	BLUM DRAWER LEGRABOX FREE HIGH - 177 MM
DLFL	BLUM DRAWER LEGRABOX FREE LOW - 177 MM
DLPC	BLUM DRAWER LEGRABOX PURE C - 177 MM
DLPF	BLUM DRAWER LEGRABOX PURE F - 241 MM
DLPK	BLUM DRAWER LEGRABOX PURE K - 128.5 MM
DLPM	BLUM DRAWER LEGRABOX PURE M - 90.5 MM
DM	BLUM DRAWER MOVENTO (MELAMINE DRAWER BOX)
EQ	EQUAL
FS	FIXED SHELF
FP	FIXED PANNEL
HDB	HINGE DOOR - BLUM ONYX BLACK HINGES
HDN	HINGE DOOR - BLUM NICKEL PLATED HINGES
HF	HINGE FLAP
HR	HANGING RAIL
IAS	INTERNAL ADJUSTABLE SHELF
IDLFH	BLUM INTERNAL DRAWER LEGRABOX FREE HIGH - 177 MM
IDLFL	BLUM INTERNAL DRAWER LEGRABOX FREE LOW - 177 MM
IDLPC	BLUM INTERNAL DRAWER LEGRABOX PURE C - 177 MM
IDLPF	BLUM INTERNAL DRAWER LEGRABOX PURE F - 241 MM
IDLPK	BLUM INTERNAL DRAWER LEGRABOX PURE K - 128.5 MM
IDLPM	BLUM INTERNAL DRAWER LEGRABOX PURE M - 90.5 MM
IDM	BLUM INTERNAL DRAWER MOVENTO (MELAMINE DRAWER BOX)
IFS	INTERNAL FIXED SHELF
IPAS	INTERNAL PULLOUT ANGLED SHOE SHELF
IPS	INTERNAL PULLOUT SHELF
IJ	MITRE JOIN
IS	PULLOUT SHELF
RD	RETRACTABLE DOOR
SL	SEAM LINE
SP	SLIDING PANNEL
STSM	SUBJECT TO SITE MEASURE
STAS	SUBJECT TO APPLIANCE SPECS
Ⓟ	BI-FOLD OPERATION
Ⓡ	FINGER GRIP OPERATION WITH BLUMOTION
Ⓜ	MANUAL OPERATION WITH BLUMOTION
Ⓟ	PUSH TOUCH OPERATION WITH BLUM TIP ON FOR DOORS
Ⓡ	TIP ON OPERATION WITH BLUMOTION FOR DRAWERS
Ⓢ	SERVO-DRIVE OPERATION - BLUM
Ⓜ	AMBIALINE - BLUM INNER DIVIDER SYSTEM - LEGRABOX
Ⓜ	ORGALINE - BLUM INNER DIVIDER SYSTEM - MOVENTO

SCALE BAR

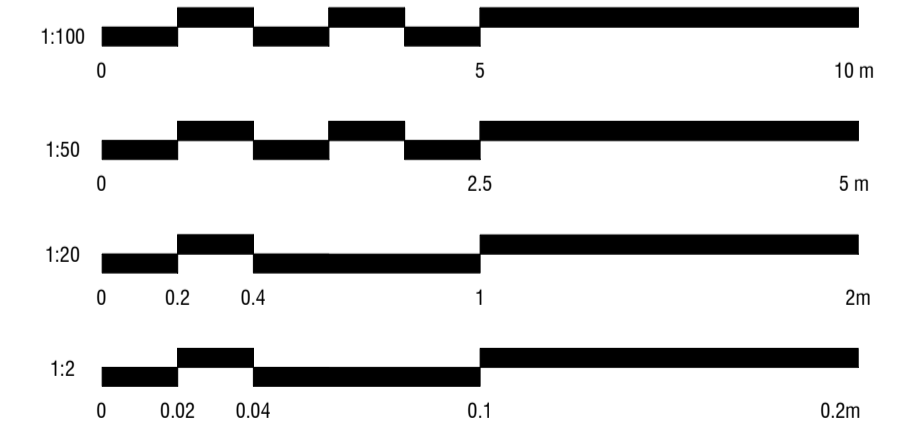

ALL MEASUREMENTS TO BE CHECKED BY TRADES ONSITE*

CHRISTOPHER
ELLIOTT


CHRISTOPHER ELLIOTT DESIGN PTY LTD
ABN 33131218650 ACN 131218650
T+61 (03)9077 8133 M +61 (0)403 653 649
INFO@CHRISTOPHERELLIOTTDESIGN.COM.AU
PO BOX 124 PRAHRAN 3181 VICTORIA AUSTRALIA

CLIENT AUSTRALIAN ALPINE CLUB
PROJECT ALPINE ROAD, HOTHAM HEIGHTS VIC 3741

All rights reserved. This document remains the property of Christopher Elliott Design Pty Ltd and is only to be used for its commissioned purpose. No part of this document may be reproduced, modified or transmitted in any form or by any means without the explicit written authority of Christopher Elliott Design Pty Ltd. Unauthorised use of this document in any form whatsoever is prohibited.

TITLE TV ROOM
SCALE @ A1 AS INDICATED
CHECKED BY CE
SHEET INT-8.02


PLOT DATE 05.06.20
DRAWN BY CA
REVISION A

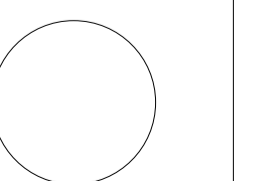


CONSTRUCTION ISSUE

REVISION STATUS

REV.	DESCRIPTION	DATE
A	REVISION #3 CONSTRUCTION DOCS ISSUED	05.06.20

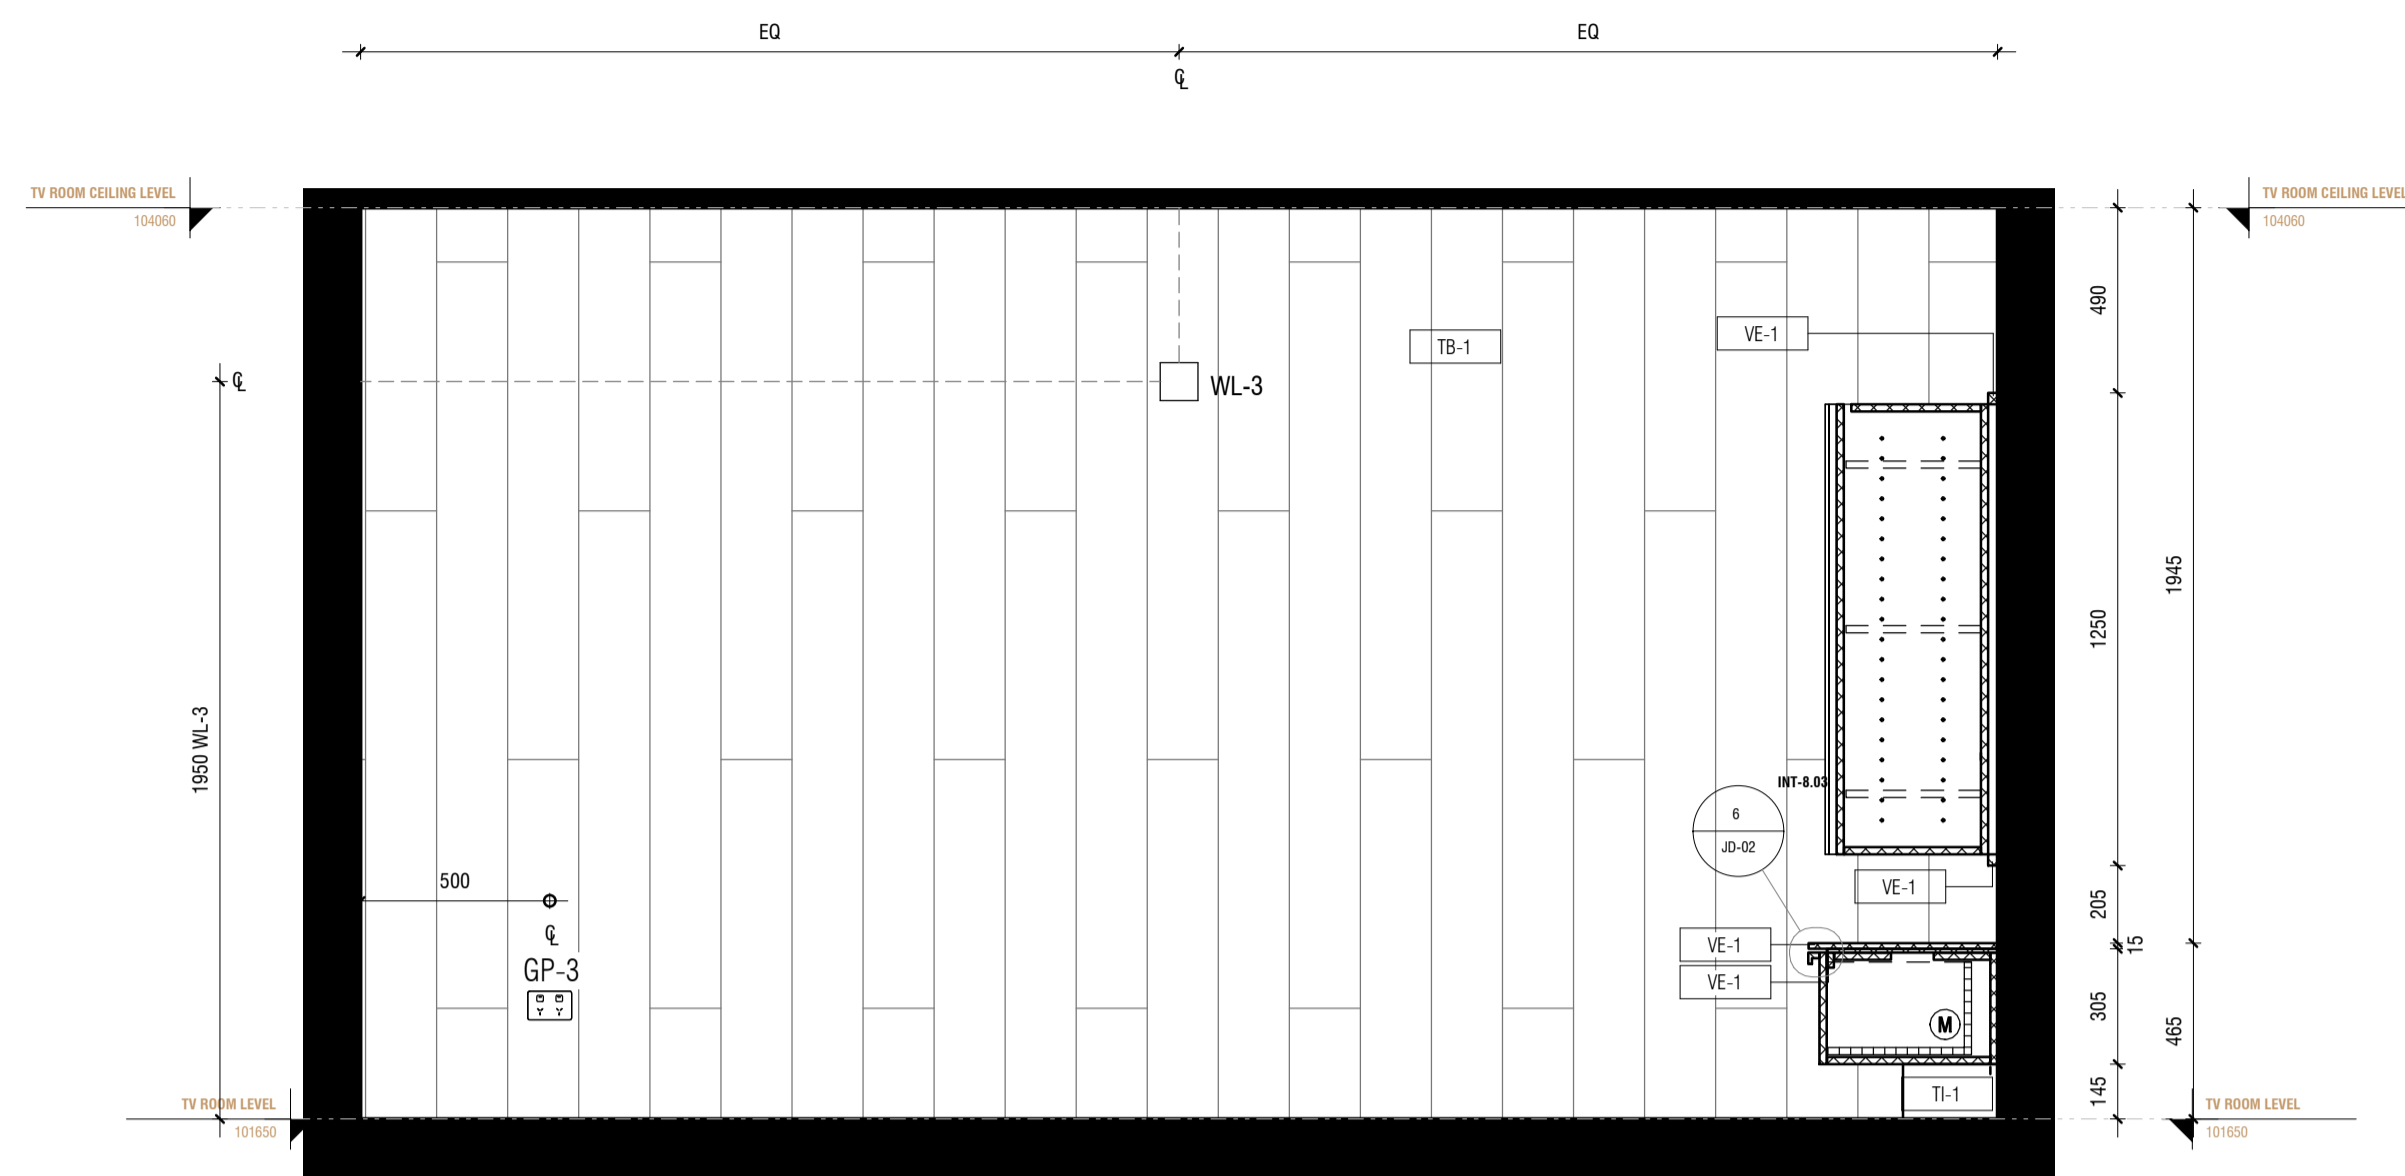

1 INT-8.03 ELEVATION 1
1 : 20

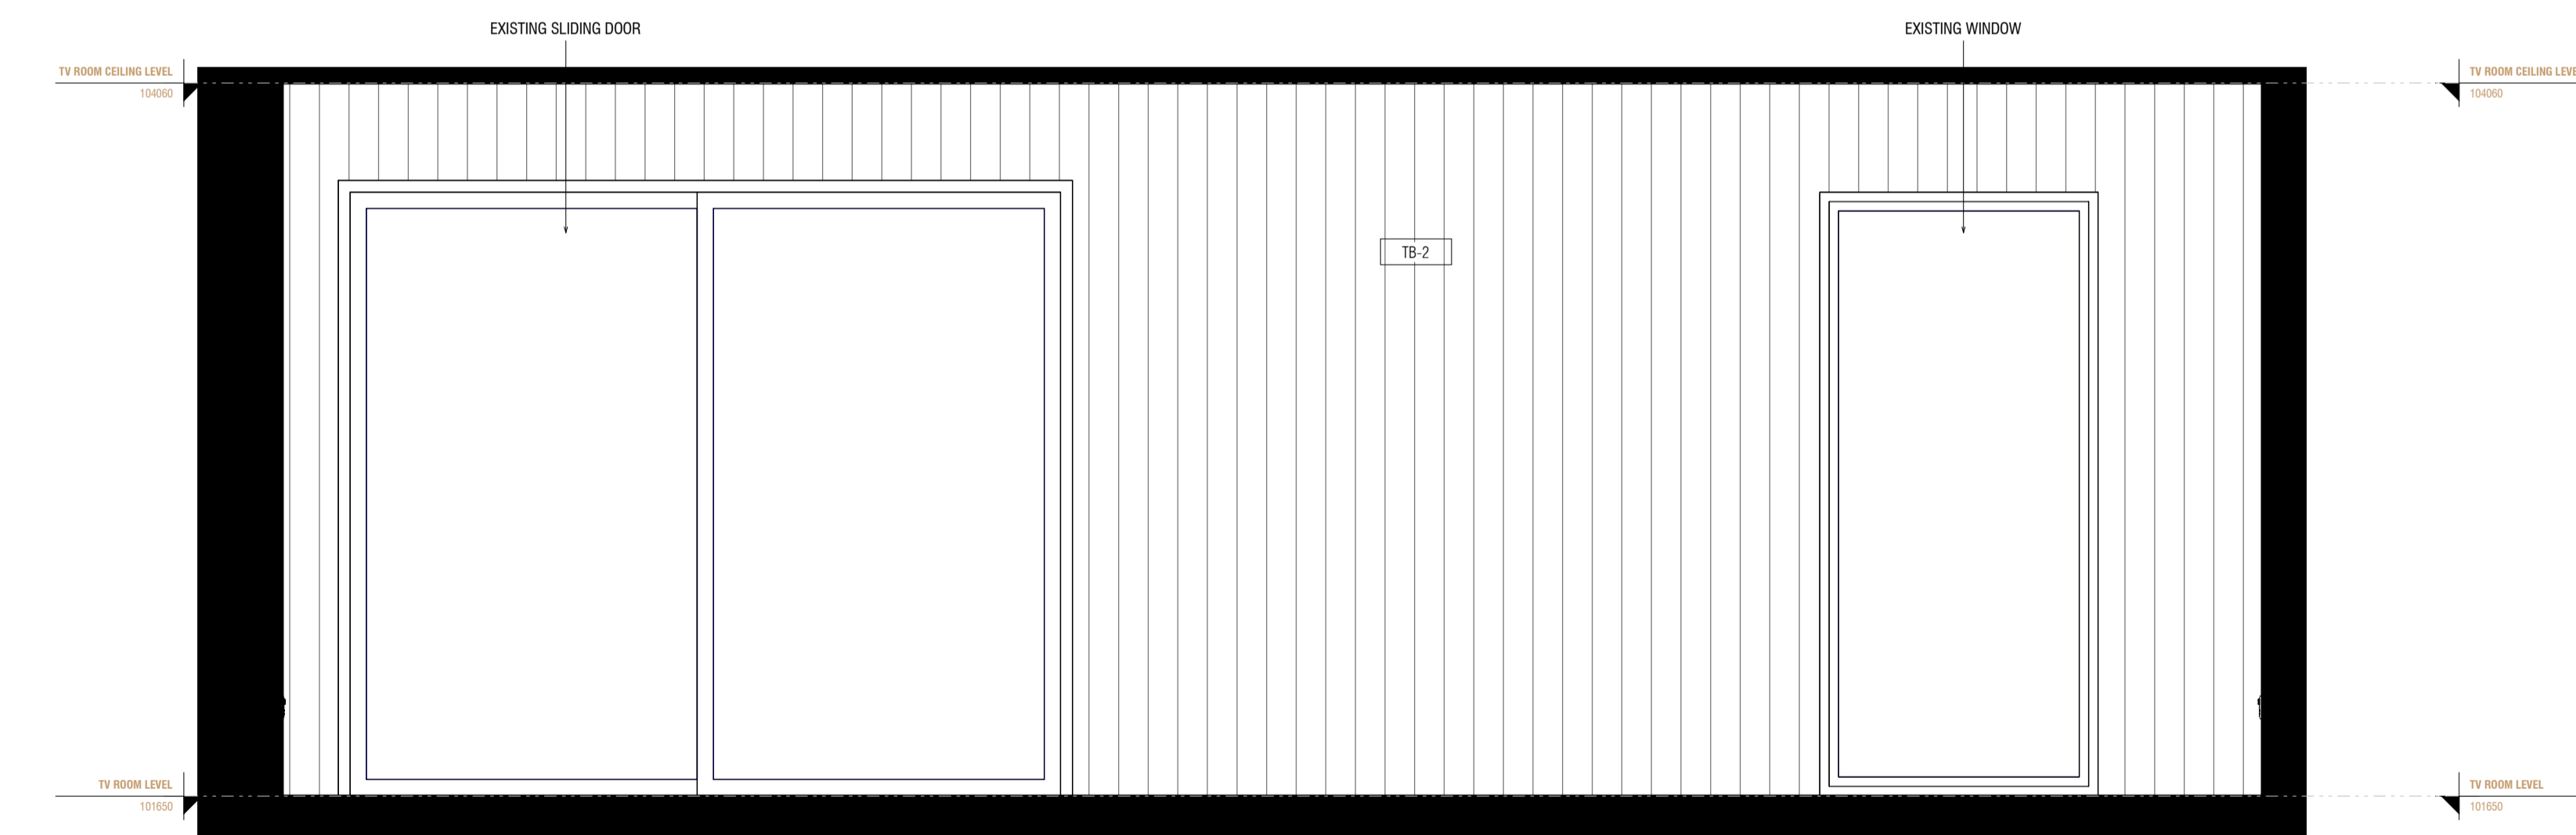


2 INT-8.03 ELEVATION 2
1 : 20

JOINERY

AS	ADJUSTABLE SHELF
AL	ALIGN
BAL	BALANCE
BS	BIFOLD SLIDING
CL	CENTRE LINE
DA	DOOR ACTIVATED
DLFH	BLUM DRAWER LEGRABOX FREE HIGH - 177 MM
DLFL	BLUM DRAWER LEGRABOX FREE LOW - 177 MM
DLPC	BLUM DRAWER LEGRABOX PURE C - 177 MM
DLPF	BLUM DRAWER LEGRABOX PURE F - 241 MM
DLPK	BLUM DRAWER LEGRABOX PURE K - 128.5 MM
DLPM	BLUM DRAWER LEGRABOX PURE M - 90.5 MM
DM	BLUM DRAWER MOVENTO (MELAMINE DRAWER BOX)
EQ	EQUAL
FS	FIXED SHELF
FP	FIXED PANNEL
HDB	HINGE DOOR - BLUM ONYX BLACK HINGES
HDN	HINGE DOOR - BLUM NICKEL PLATED HINGES
HF	HINGE FLAP
HR	HANGING RAIL
IAS	INTERNAL ADJUSTABLE SHELF
IDLFH	BLUM INTERNAL DRAWER LEGRABOX FREE HIGH - 177 MM
IDLFL	BLUM INTERNAL DRAWER LEGRABOX FREE LOW - 177 MM
IDLPC	BLUM INTERNAL DRAWER LEGRABOX PURE C - 177 MM
IDLPF	BLUM INTERNAL DRAWER LEGRABOX PURE F - 241 MM
IDLPK	BLUM INTERNAL DRAWER LEGRABOX PURE K - 128.5 MM
IDLPM	BLUM INTERNAL DRAWER LEGRABOX PURE M - 90.5 MM
IDM	BLUM INTERNAL DRAWER MOVENTO (MELAMINE DRAWER BOX)
IFS	INTERNAL FIXED SHELF
IHDB	INTERNAL HINGE DOOR - BLUM ONYX BLACK HINGES
IHDN	INTERNAL HINGE DOOR - BLUM NICKEL PLATED HINGES
IPAS	INTERNAL PULLOUT ANGLED SHOE SHELF
IPS	INTERNAL PULLOUT SHELF
MJ	MITRE JOIN
PS	PULLOUT SHELF
RD	RETRACTABLE DOOR
SL	SEAM LINE
SP	SLIDING PANEL
STSM	SUBJECT TO SITE MEASURE
STAS	SUBJECT TO APPLIANCE SPECS
Ⓟ	BI-FOLD OPERATION
Ⓡ	FINGER GRIP OPERATION WITH BLUMOTION
Ⓜ	MANUAL OPERATION WITH BLUMOTION
Ⓟ	PUSH TOUCH OPERATION WITH BLUM TIP ON FOR DOORS
Ⓡ	TIP ON OPERATION WITH BLUMOTION FOR DRAWERS
Ⓢ	SERVO-DRIVE OPERATION - BLUM
Ⓜ	AMBIALINE - BLUM INNER DIVIDER SYSTEM - LEGRABOX
Ⓞ	ORGALINE - BLUM INNER DIVIDER SYSTEM - MOVENTO

SCALE BAR

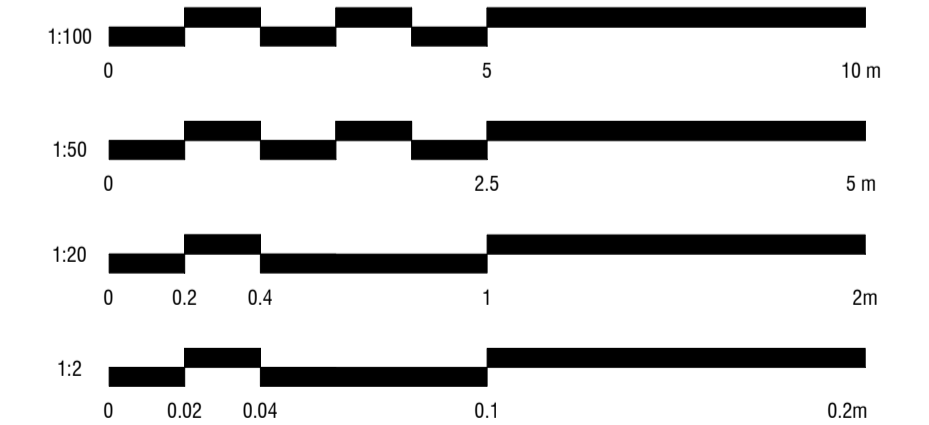

CHRISTOPHER
ELLIOTT


CHRISTOPHER ELLIOTT DESIGN PTY LTD
ABN 33131218650 ACN 131218650
T+61 (03)9077 8133 M +61 (0)403 653 649
INFO@CHRISTOPHERELLIOTTDESIGN.COM.AU
PO BOX 124 PRAHRAN 3181 VICTORIA AUSTRALIA

CLIENT AUSTRALIAN ALPINE CLUB
PROJECT ALPINE ROAD, HOTHAM HEIGHTS VIC 3741

All rights reserved. This document remains the property of Christopher Elliott Design Pty Ltd and is only to be used for its commissioned purpose. No part of this document may be reproduced, modified or transmitted in any form or by any means without the explicit written authority of Christopher Elliott Design Pty Ltd. Unauthorised use of this document in any form whatsoever is prohibited.


TITLE TV ROOM
SCALE @ A1 AS INDICATED
CHECKED BY CE
SHEET INT-8.03

PLOT DATE 05.06.20
DRAWN BY CA
REVISION A

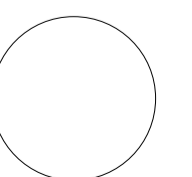


REVISION STATUS


REV.	DESCRIPTION	DATE
A	REVISION #3 CONSTRUCTION DOCS ISSUED	05.06.20

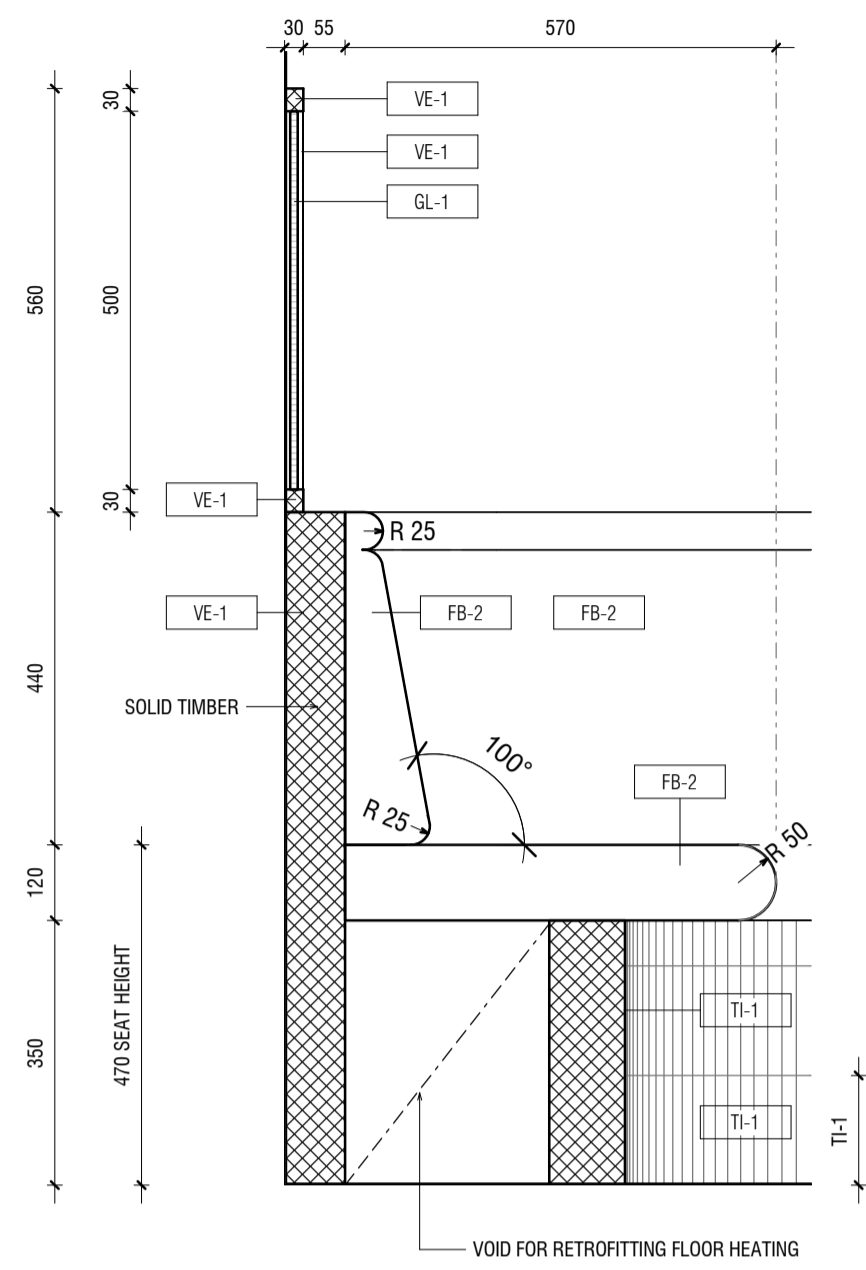


1 BANQUETTE SEAT - SECTION
1:10

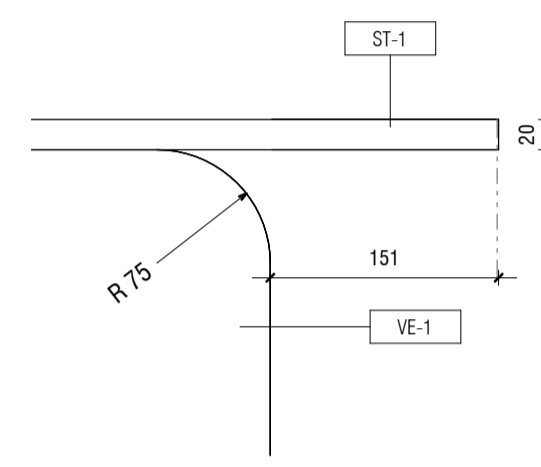


2 KITCHEN ISLAND BENCH - ELEVATION
1:5

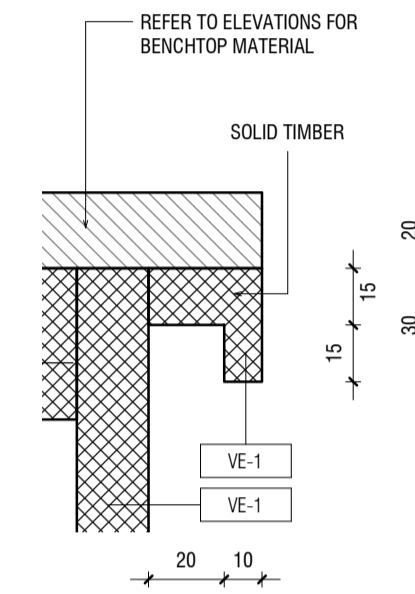


3 TYPICAL DRAWER HANDLE - SECTION
1:2

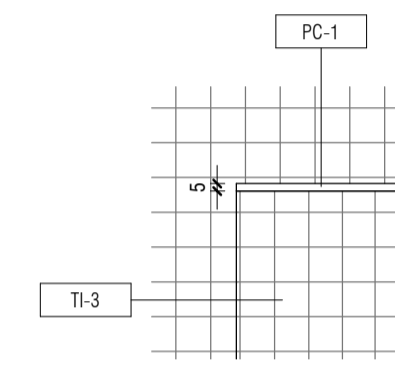


4 TYPICAL ENSUITE SHOWER SHELF - ELEVATION
1:5

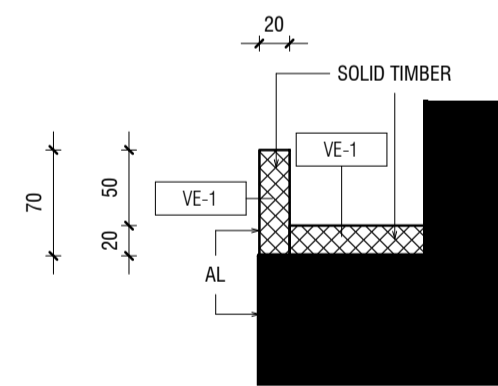

5 TOILET SHELF - SECTION
1:5

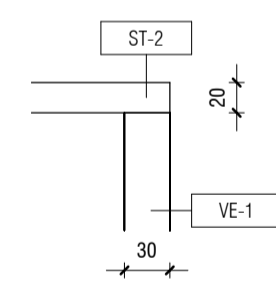

6 BEDROOM DRAWER - ELEVATION
1:5

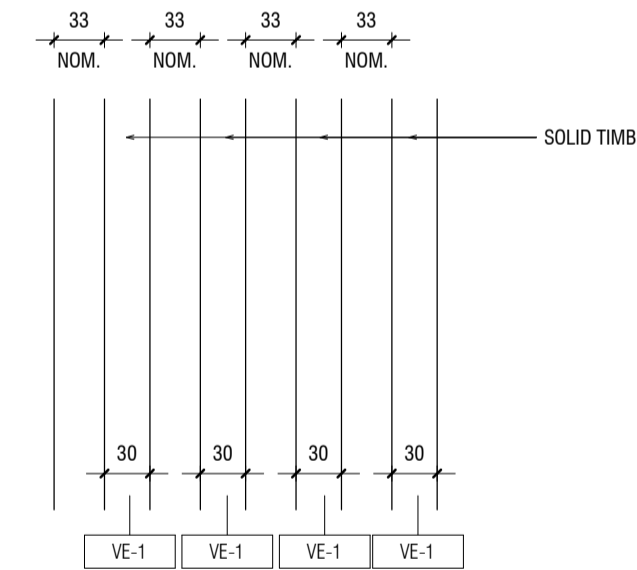


7 TYPICAL ROBE/DRAWERS - ELEVATION
1:5

JOINERY

AS	ADJUSTABLE SHELF
AL	ALIGN
BAL	BALANCE
BS	BIFOLD SLIDING
CL	CENTRE LINE
DA	DOOR ACTIVATED
DLFH	BLUM DRAWER LEGRABOX FREE HIGH - 177 MM
DLFL	BLUM DRAWER LEGRABOX FREE LOW - 177 MM
DLPC	BLUM DRAWER LEGRABOX PURE C - 177 MM
DLPF	BLUM DRAWER LEGRABOX PURE F - 241 MM
DLPK	BLUM DRAWER LEGRABOX PURE K - 128.5 MM
DLPM	BLUM DRAWER LEGRABOX PURE M - 90.5 MM
DM	BLUM DRAWER MOVENTO (MELAMINE DRAWER BOX)
EQ	EQUAL
FS	FIXED SHELF
FP	FIXED PANNEL
HDB	HINGE DOOR - BLUM ONYX BLACK HINGES
HDN	HINGE DOOR - BLUM NICKEL PLATED HINGES
HF	HINGE FLAP
HR	HANGING RAIL
IAS	INTERNAL ADJUSTABLE SHELF
IDLFH	BLUM INTERNAL DRAWER LEGRABOX FREE HIGH - 177 MM
IDLFL	BLUM INTERNAL DRAWER LEGRABOX FREE LOW - 177 MM
IDLPC	BLUM INTERNAL DRAWER LEGRABOX PURE C - 177 MM
IDLPF	BLUM INTERNAL DRAWER LEGRABOX PURE F - 241 MM
IDLPK	BLUM INTERNAL DRAWER LEGRABOX PURE K - 128.5 MM
IDLPM	BLUM INTERNAL DRAWER LEGRABOX PURE M - 90.5 MM
IDM	BLUM INTERNAL DRAWER MOVENTO (MELAMINE DRAWER BOX)
IFS	INTERNAL FIXED SHELF
IHDB	INTERNAL HINGE DOOR - BLUM ONYX BLACK HINGES
IHDN	INTERNAL HINGE DOOR - BLUM NICKEL PLATED HINGES
IPAS	INTERNAL PULLOUT ANGLED SHOE SHELF
IPS	INTERNAL PULLOUT SHELF
MJ	MITRE JOIN
PS	PULLOUT SHELF
RD	RETRACTABLE DOOR
SL	SEAM LINE
SP	SLIDING PANEL
STSM	SUBJECT TO SITE MEASURE
STAS	SUBJECT TO APPLIANCE SPECS
Ⓟ	BI-FOLD OPERATION
Ⓣ	FINGER GRIP OPERATION WITH BLUMOTION
Ⓜ	MANUAL OPERATION WITH BLUMOTION
Ⓟ	PUSH TOUCH OPERATION WITH BLUM TIP ON FOR DOORS
Ⓡ	TIP ON OPERATION WITH BLUMOTION FOR DRAWERS
Ⓢ	SERVO-DRIVE OPERATION - BLUM
Ⓛ	AMBIALINE - BLUM INNER DIVIDER SYSTEM - LEGRABOX
Ⓞ	ORGALINE - BLUM INNER DIVIDER SYSTEM - MOVENTO

SCALE BAR

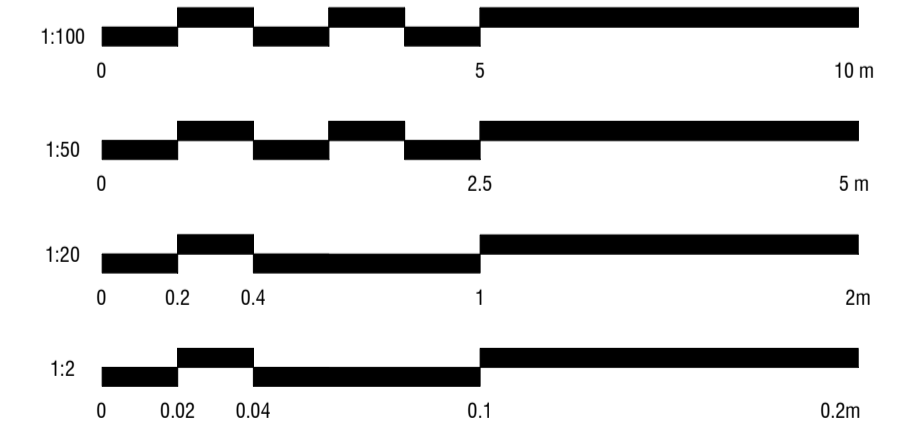

ALL MEASUREMENTS TO BE CHECKED BY TRADES ONSITE*

CHRISTOPHER
ELLIOTT


CHRISTOPHER ELLIOTT DESIGN PTY LTD
ABN 33131218650 ACN 131218650
T+61 (03)9077 8133 M +61 (0)403 653 649
INFO@CHRISTOPHERELLIOTTDESIGN.COM.AU
PO BOX 124 PRAHRAN 3181 VICTORIA AUSTRALIA

CLIENT AUSTRALIAN ALPINE CLUB
PROJECT ALPINE ROAD, HOTHAM HEIGHTS VIC 3741

All rights reserved. This document remains the property of Christopher Elliott Design Pty Ltd and is only to be used for its commissioned purpose. No part of this document may be reproduced, modified or transmitted in any form or by any means without the explicit written authority of Christopher Elliott Design Pty Ltd. Unauthorised use of this document in any form whatsoever is prohibited.


TITLE JOINERY DETAILS
SCALE @ A1 AS INDICATED
CHECKED BY CE
SHEET JD-01

PLOT DATE 05.06.20
DRAWN BY CA
REVISION A

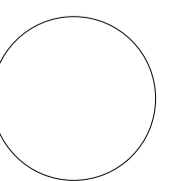


REVISION STATUS

REV.	DESCRIPTION	DATE
A	REVISION #3 CONSTRUCTION DOCS ISSUED	05.06.20

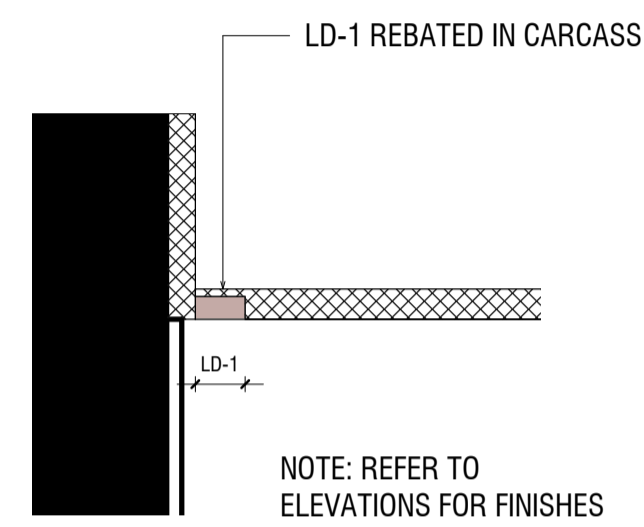


1 TYPICAL LED STRIP LIGHTING - SECTION
1:5

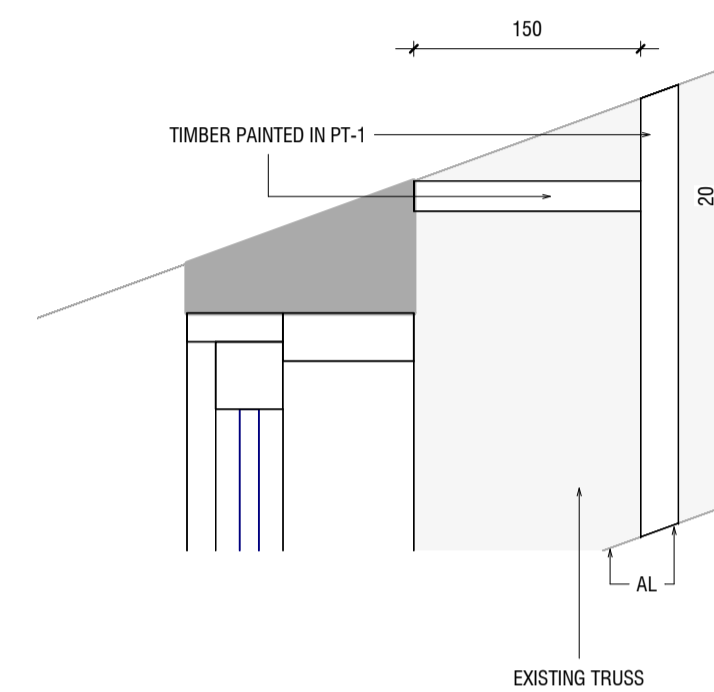


2 TYPICAL TIMBER PELMET - SECTION
1:5


NOTE: EZY REVEAL PRODUCT TO BE APPLIED TO ALL FACES OF WINDOW REVEALS

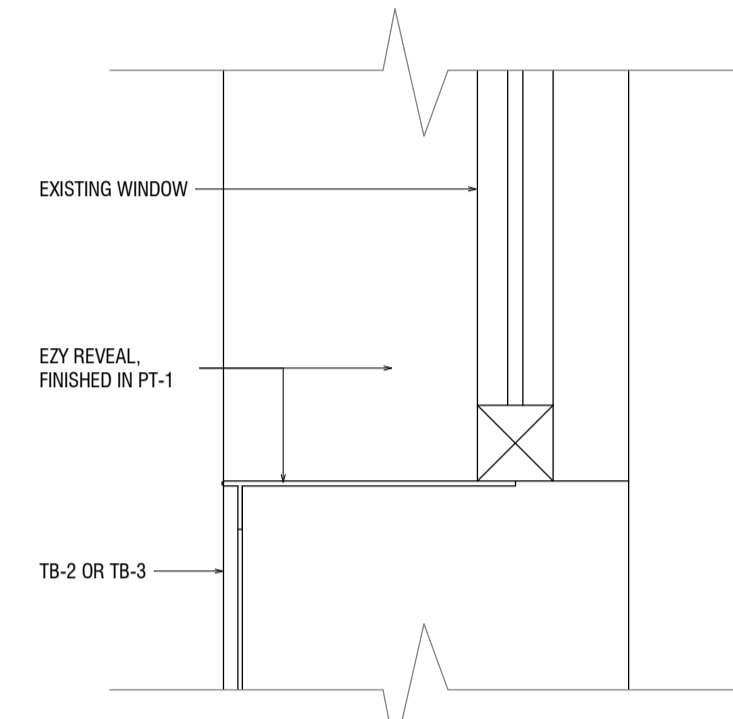


3 TYPICAL WINDOW REVEAL - SECTION
1:5

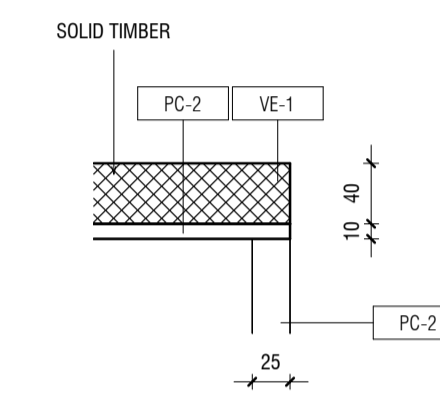


4 WOOD STORAGE - SECTION
1:5

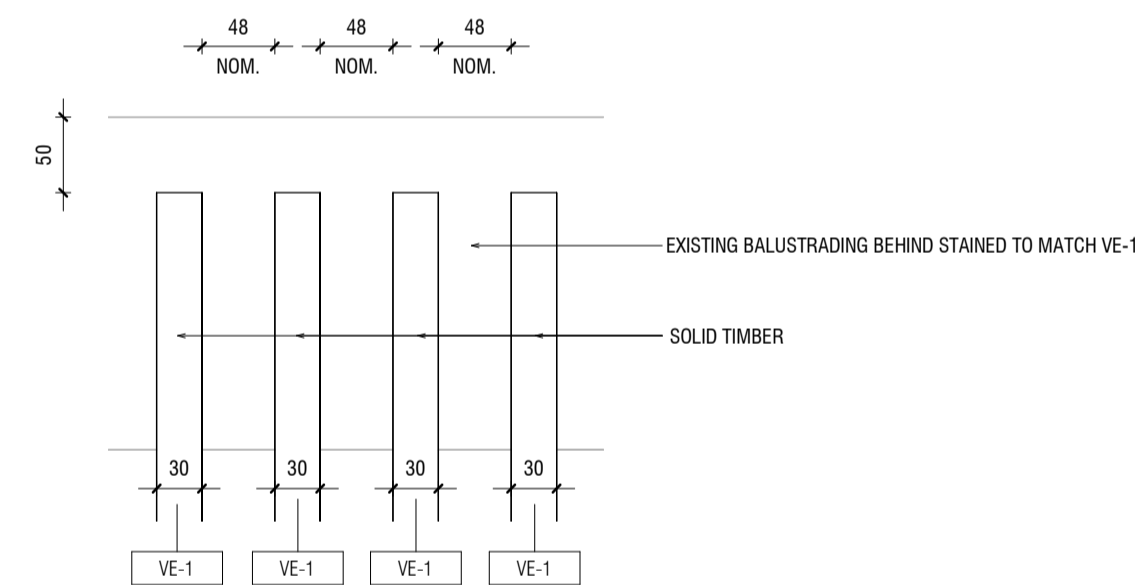


5 TYPICAL BALUSTRADE - ELEVATION
1:5

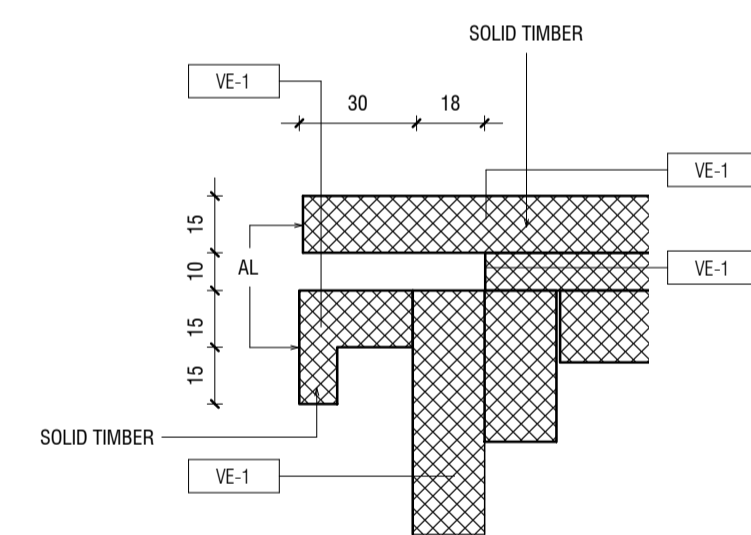

6 TV ROOM DRAWER HANDLE - SECTION
1:2

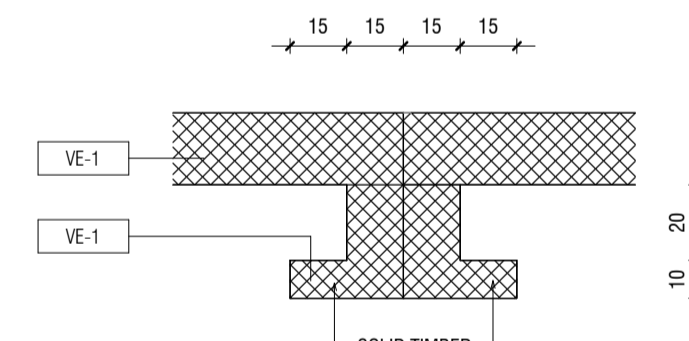

7 TV ROOM TALL UNIT HANDLE - PLAN
1:2

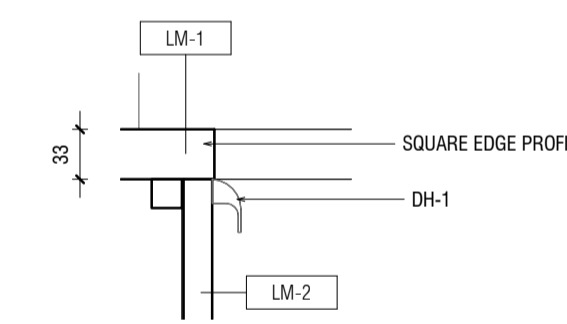


8 LAUNDRY BENCHTOP PROFILE - SECTION
1:5

JOINERY

AS	ADJUSTABLE SHELF
AL	ALIGN
BAL	BALANCE
BS	BIFOLD SLIDING
CL	CENTRE LINE
DA	DOOR ACTIVATED
DLFH	BLUM DRAWER LEGRABOX FREE HIGH - 177 MM
DLFL	BLUM DRAWER LEGRABOX FREE LOW - 177 MM
DLPC	BLUM DRAWER LEGRABOX PURE C - 177 MM
DLPF	BLUM DRAWER LEGRABOX PURE F - 241 MM
DLPK	BLUM DRAWER LEGRABOX PURE K - 128.5 MM
DLPM	BLUM DRAWER LEGRABOX PURE M - 90.5 MM
DM	BLUM DRAWER MOVENTO (MELAMINE DRAWER BOX)
EQ	EQUAL
FS	FIXED SHELF
FP	FIXED PANNEL
HDB	HINGE DOOR - BLUM ONYX BLACK HINGES
HDN	HINGE DOOR - BLUM NICKEL PLATED HINGES
HF	HINGE FLAP
HR	HANGING RAIL
IAS	INTERNAL ADJUSTABLE SHELF
IDLFH	BLUM INTERNAL DRAWER LEGRABOX FREE HIGH - 177 MM
IDLFL	BLUM INTERNAL DRAWER LEGRABOX FREE LOW - 177 MM
IDLPC	BLUM INTERNAL DRAWER LEGRABOX PURE C - 177 MM
IDLPF	BLUM INTERNAL DRAWER LEGRABOX PURE F - 241 MM
IDLPK	BLUM INTERNAL DRAWER LEGRABOX PURE K - 128.5 MM
IDLPM	BLUM INTERNAL DRAWER LEGRABOX PURE M - 90.5 MM
IDM	BLUM INTERNAL DRAWER MOVENTO (MELAMINE DRAWER BOX)
IFS	INTERNAL FIXED SHELF
IHDB	INTERNAL HINGE DOOR - BLUM ONYX BLACK HINGES
IHDN	INTERNAL HINGE DOOR - BLUM NICKEL PLATED HINGES
IPAS	INTERNAL PULLOUT ANGLED SHOE SHELF
IPS	INTERNAL PULLOUT SHELF
IJ	MITRE JOIN
PS	PULLOUT SHELF
RD	RETRACTABLE DOOR
SL	SEAM LINE
SP	SLIDING PANNEL
STSM	SUBJECT TO SITE MEASURE
STAS	SUBJECT TO APPLIANCE SPECS
ⓑ	BI-FOLD OPERATION
Ⓕ	FINGER GRIP OPERATION WITH BLUMOTION
Ⓜ	MANUAL OPERATION WITH BLUMOTION
Ⓟ	PUSH TOUCH OPERATION WITH BLUM TIP ON FOR DOORS
Ⓡ	TIP ON OPERATION WITH BLUMOTION FOR DRAWERS
Ⓢ	SERVO-DRIVE OPERATION - BLUM
Ⓣ	AMBIALINE - BLUM INNER DIVIDER SYSTEM - LEGRABOX
Ⓤ	ORGALINE - BLUM INNER DIVIDER SYSTEM - MOVENTO

SCALE BAR

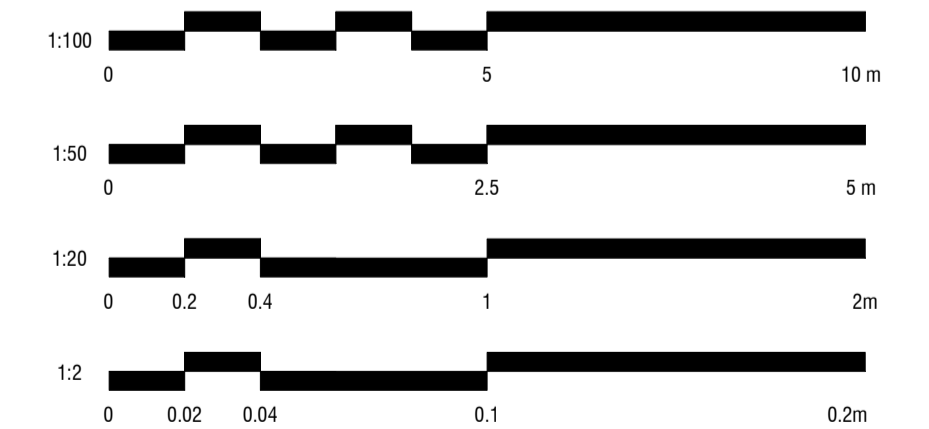

ALL MEASUREMENTS TO BE CHECKED BY TRADES ONSITE*

CHRISTOPHER
ELLIOTT


CHRISTOPHER ELLIOTT DESIGN PTY LTD
ABN 33131218650 ACN 131218650
T+61 (03)9077 8133 M +61 (0)403 653 649
INFO@CHRISTOPHERELLIOTTDESIGN.COM.AU
PO BOX 124 PRAHRAN 3181 VICTORIA AUSTRALIA

CLIENT AUSTRALIAN ALPINE CLUB
PROJECT ALPINE ROAD, HOTHAM HEIGHTS VIC 3741

All rights reserved. This document remains the property of Christopher Elliott Design Pty Ltd and is only to be used for its commissioned purpose. No part of this document may be reproduced, modified or transmitted in any form or by any means without the explicit written authority of Christopher Elliott Design Pty Ltd. Unauthorised use of this document in any form whatsoever is prohibited.

TITLE JOINERY DETAILS
SCALE @ A1 AS INDICATED
CHECKED BY CE
SHEET JD-02

PLOT DATE 05.06.20
DRAWN BY CA
REVISION A

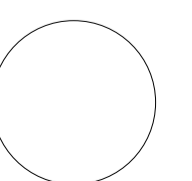

REVISION STATUS

REV.	DESCRIPTION	DATE
A	REVISION #3 CONSTRUCTION DOCS ISSUED	05.06.20




NOTE: REFERENCE JOINERY FOR WL-2 HEIGHT

JOINERY

AS	ADJUSTABLE SHELF
AL	ALIGN
BAL	BALANCE
BS	BIFOLD SLIDING
CL	CENTRE LINE
DA	DOOR ACTIVATED
DLFH	BLUM DRAWER LEGRABOX FREE HIGH - 177 MM
DLFL	BLUM DRAWER LEGRABOX FREE LOW - 177 MM
DLPC	BLUM DRAWER LEGRABOX PURE C - 177 MM
DLPF	BLUM DRAWER LEGRABOX PURE F - 241 MM
DLPK	BLUM DRAWER LEGRABOX PURE K - 128.5 MM
DLPM	BLUM DRAWER LEGRABOX PURE M - 90.5 MM
DM	BLUM DRAWER MOVENTO (MELAMINE DRAWER BOX)
EQ	EQUAL
FS	FIXED SHELF
FP	FIXED PANNEL
HDB	HINGE DOOR - BLUM ONYX BLACK HINGES
HDN	HINGE DOOR - BLUM NICKEL PLATED HINGES
HF	HINGE FLAP
HR	HANGING RAIL
IAS	INTERNAL ADJUSTABLE SHELF
IDLFH	BLUM INTERNAL DRAWER LEGRABOX FREE HIGH - 177 MM
IDFL	BLUM INTERNAL DRAWER LEGRABOX FREE LOW - 177 MM
IDLPC	BLUM INTERNAL DRAWER LEGRABOX PURE C - 177 MM
IDLPF	BLUM INTERNAL DRAWER LEGRABOX PURE F - 241 MM
IDLPK	BLUM INTERNAL DRAWER LEGRABOX PURE K - 128.5 MM
IDLPM	BLUM INTERNAL DRAWER LEGRABOX PURE M - 90.5 MM
IDM	BLUM INTERNAL DRAWER MOVENTO (MELAMINE DRAWER BOX)
IFS	INTERNAL FIXED SHELF
IHDB	INTERNAL HINGE DOOR - BLUM ONYX BLACK HINGES
IHDN	INTERNAL HINGE DOOR - BLUM NICKEL PLATED HINGES
IPAS	INTERNAL PULLOUT ANGLED SHOE SHELF
IPS	INTERNAL PULLOUT SHELF
IJ	INTERNAL MITRE JOIN
IS	INTERNAL PULLOUT SHELF
RD	RETRACTABLE DOOR
SL	SEAM LINE
SP	SLIDING PANEL
STSM	SUBJECT TO SITE MEASURE
STAS	SUBJECT TO APPLIANCE SPECS
Ⓟ	BI-FOLD OPERATION
Ⓛ	FINGER GRIP OPERATION WITH BLUMOTION
Ⓜ	MANUAL OPERATION WITH BLUMOTION
Ⓟ	PUSH TOUCH OPERATION WITH BLUM TIP ON FOR DOORS
Ⓡ	TIP ON OPERATION WITH BLUMOTION FOR DRAWERS
Ⓢ	SERVO-DRIVE OPERATION - BLUM
Ⓣ	AMBIALINE - BLUM INNER DIVIDER SYSTEM - LEGRABOX
Ⓤ	ORGALINE - BLUM INNER DIVIDER SYSTEM - MOVENTO

SCALE BAR

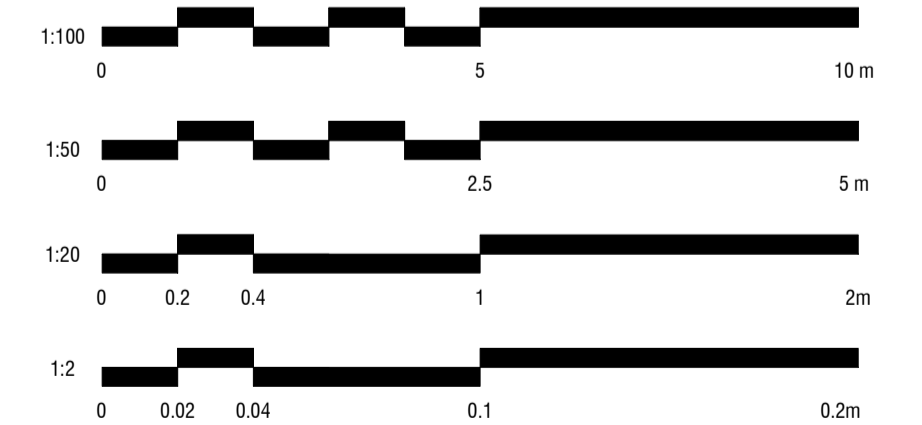

ALL MEASUREMENTS TO BE CHECKED BY TRADES ONSITE

1 GROUND FLOOR RCP & LIGHTING PLAN
1:50


CHRISTOPHER
ELLIOTT

CHRISTOPHER ELLIOTT DESIGN PTY LTD
ABN 33131218650 ACN 131218650
T+61 (03)9077 8133 M +61 (0)403 653 649
INFO@CHRISTOPHERELLIOTTDESIGN.COM.AU
PO BOX 124 PRAHRAN 3181 VICTORIA AUSTRALIA

CLIENT AUSTRALIAN ALPINE CLUB
PROJECT ALPINE ROAD, HOTHAM HEIGHTS VIC 3741


All rights reserved. This document remains the property of Christopher Elliott Design Pty Ltd and is only to be used for its commissioned purpose. No part of this document may be reproduced, modified or transmitted in any form or by any means without the explicit written authority of Christopher Elliott Design Pty Ltd. Unauthorised use of this document in any form whatsoever is prohibited.

TITLE GROUND FLOOR REFLECTED CEILING & LIGHTING PLAN
SCALE @ A1 AS INDICATED PLOT DATE 05.06.20
CHECKED BY CE DRAWN BY CA
SHEET RCP-01 REVISION A

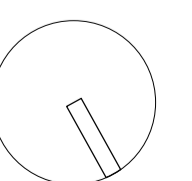

REVISION STATUS

REV.	DESCRIPTION	DATE
A	REVISION #3 CONSTRUCTION DOCS ISSUED	05.06.20

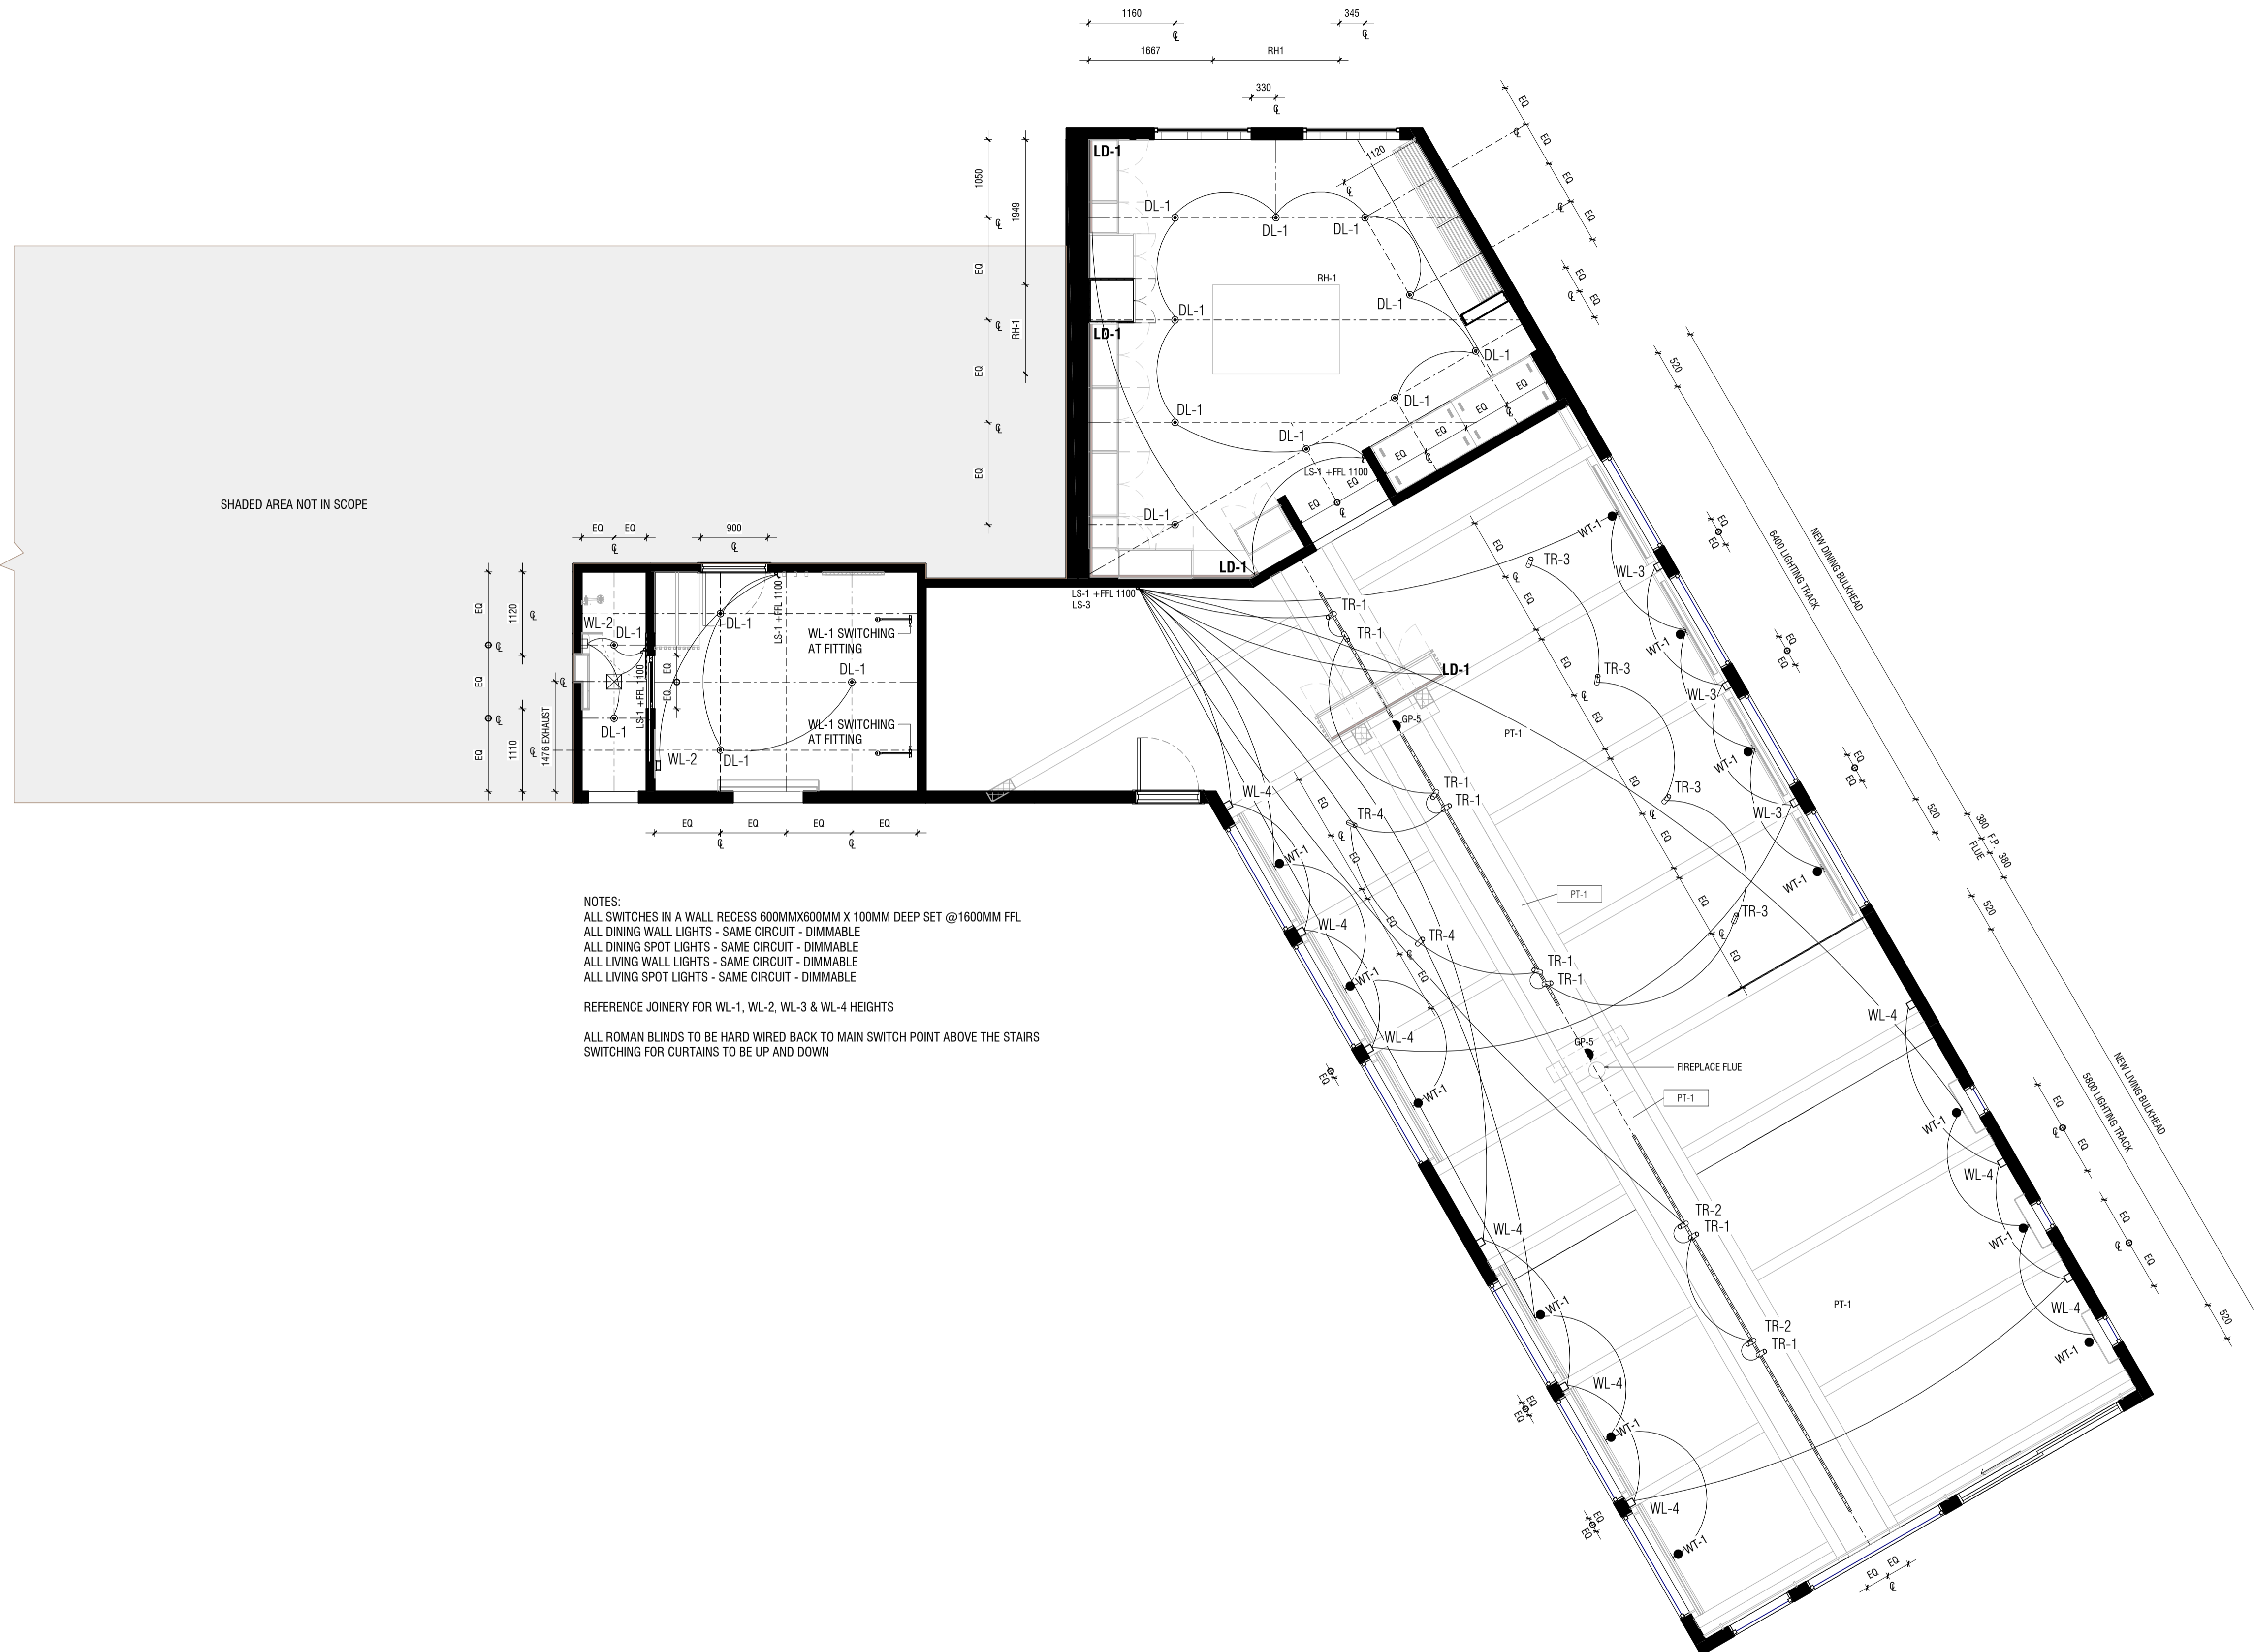


NOTES:
 ALL SWITCHES IN A WALL RECESS 600MMX600MM X 100MM DEEP SET @1600MM FFL
 ALL DINING WALL LIGHTS - SAME CIRCUIT - DIMMABLE
 ALL DINING SPOT LIGHTS - SAME CIRCUIT - DIMMABLE
 ALL LIVING WALL LIGHTS - SAME CIRCUIT - DIMMABLE
 ALL LIVING SPOT LIGHTS - SAME CIRCUIT - DIMMABLE
 REFERENCE JOINERY FOR WL-1, WL-2, WL-3 & WL-4 HEIGHTS
 ALL ROMAN BLINDS TO BE HARD WIRED BACK TO MAIN SWITCH POINT ABOVE THE STAIRS SWITCHING FOR CURTAINS TO BE UP AND DOWN

JOINERY

AS	ADJUSTABLE SHELF
AL	ALIGN
BAL	BALANCE
BS	BIFOLD SLIDING
CL	CENTRE LINE
DA	DOOR ACTIVATED
DLFH	BLUM DRAWER LEGRABOX FREE HIGH - 177 MM
DLFL	BLUM DRAWER LEGRABOX FREE LOW - 177 MM
DLPC	BLUM DRAWER LEGRABOX PURE C - 241 MM
DLPF	BLUM DRAWER LEGRABOX PURE F - 241 MM
DLPK	BLUM DRAWER LEGRABOX PURE K - 128.5 MM
DLPM	BLUM DRAWER LEGRABOX PURE M - 90.5 MM
DM	BLUM DRAWER MOVENTO (MELAMINE DRAWER BOX)
EQ	EQUAL
FS	FIXED SHELF
FP	FIXED PANNEL
HDB	HINGE DOOR - BLUM ONYX BLACK HINGES
HDN	HINGE DOOR - BLUM NICKEL PLATED HINGES
HF	HINGE FLAP
HR	HANGING RAIL
IAS	INTERNAL ADJUSTABLE SHELF
IDLFH	BLUM INTERNAL DRAWER LEGRABOX FREE HIGH - 177 MM
IDLFL	BLUM INTERNAL DRAWER LEGRABOX FREE LOW - 177 MM
IDLPC	BLUM INTERNAL DRAWER LEGRABOX PURE C - 241 MM
IDLPF	BLUM INTERNAL DRAWER LEGRABOX PURE F - 241 MM
IDLPK	BLUM INTERNAL DRAWER LEGRABOX PURE K - 128.5 MM
IDLPM	BLUM INTERNAL DRAWER LEGRABOX PURE M - 90.5 MM
IDM	BLUM INTERNAL DRAWER MOVENTO (MELAMINE DRAWER BOX)
IFS	INTERNAL FIXED SHELF
IHDB	INTERNAL HINGE DOOR - BLUM ONYX BLACK HINGES
IHDN	INTERNAL HINGE DOOR - BLUM NICKEL PLATED HINGES
IPAS	INTERNAL PULLOUT ANGLED SHOE SHELF
IPS	INTERNAL PULLOUT SHELF
MJ	MITRE JOIN
PS	PULLOUT SHELF
RD	RETRACTABLE DOOR
SL	SEAM LINE
SP	SLIDING PANNEL
STSM	SUBJECT TO SITE MEASURE
STAS	SUBJECT TO APPLIANCE SPECS
Ⓟ	BI-FOLD OPERATION
Ⓡ	FINGER GRIP OPERATION WITH BLUMOTION
Ⓢ	MANUAL OPERATION WITH BLUMOTION
Ⓣ	PUSH TOUCH OPERATION WITH BLUM TIP ON FOR DOORS
Ⓤ	TIP ON OPERATION WITH BLUMOTION FOR DRAWERS
Ⓦ	SERVO-DRIVE OPERATION - BLUM
Ⓧ	AMBIALINE - BLUM INNER DIVIDER SYSTEM - LEGRABOX
Ⓨ	ORGALINE - BLUM INNER DIVIDER SYSTEM - MOVENTO

SCALE BAR

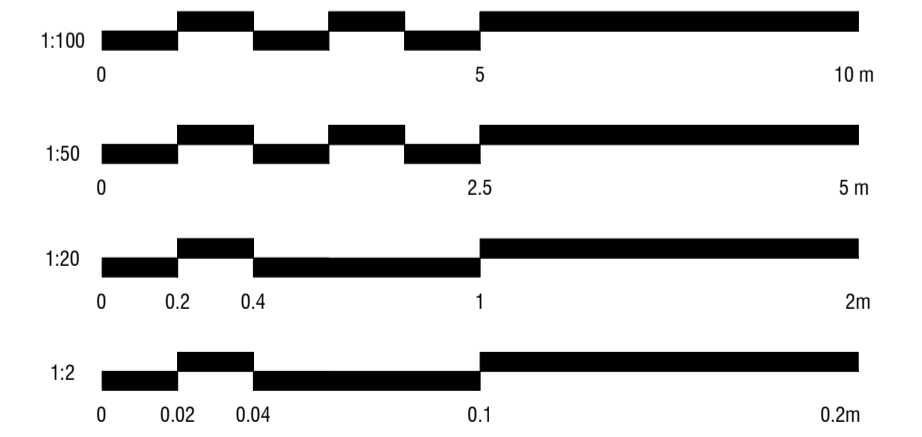

ALL MEASUREMENTS TO BE CHECKED BY TRADES ONSITE

1 FIRST FLOOR RCP & LIGHTING PLAN
1:50

